

AVALLEE BREININGER ARCHITECTS
 155 Dow Street, Suite 400, Manchester, NH 03109
 PH 603.622.5450, FAX 603.622.7283, www.ABRA.com



Allied Engineering
 National Mechanical Contractors Association
 148 Vermont Street
 Portland, Maine 04108
 P 207.271.2200
 F 207.271.2206
 www.alliedeng.com



GRAPHIC SCALE
 1" = 12'
 0 12 24

The Park Danforth


The Park Danforth -
 777 Stevens Avenue,
 Portland, ME, 04103

777 Stevens Ave, Portland, ME, 04103

NO.	DESCRIPTION	DATE
1.	ADDENDUM NO. 2	2015.05.25
2.	ADDENDUM NO. 4	2015.07.09



CONTRACT: MECHANICAL PLAN - LEVEL 2 - NEW BUILDING	
DRAWN BY: PROJECT NO: DATE: REVISION: SCALE:	RSM 200640 08/20/15 000000 AS-BUILT
MH1.2C Project Name: COMPLIANCE SET CONTRACT SET FOR ALL UTILITIES AND MECHANICAL SYSTEMS NOT FOR CONSTRUCTION WITHOUT PERMITS	

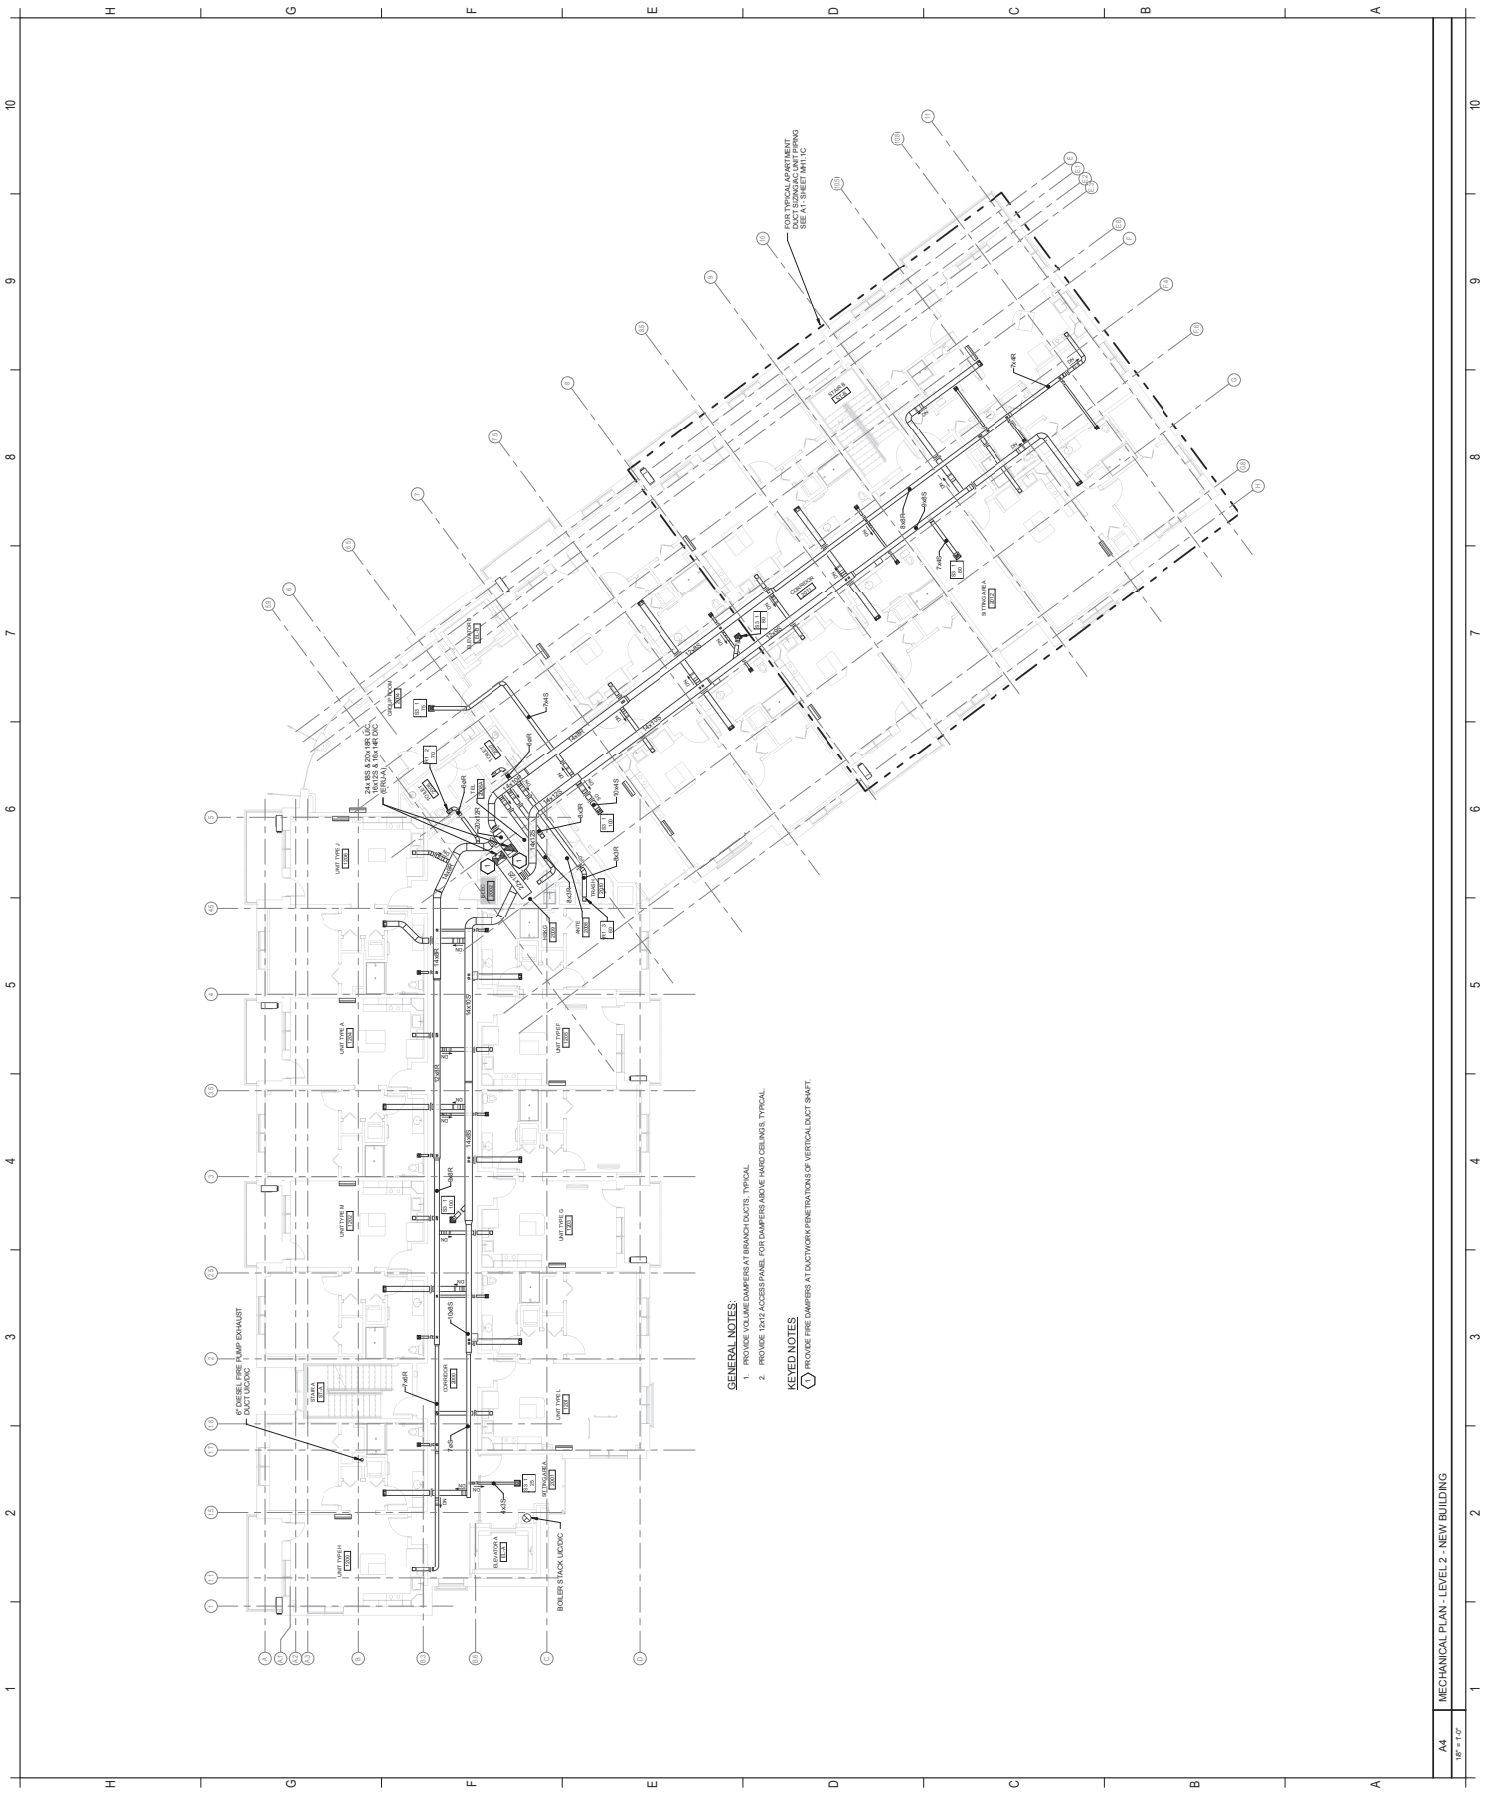

- GENERAL NOTES:**
1. PROVIDE VOLUME DAMPERS AT BRANCH DUCTS, TYPICAL.
 2. PROVIDE TIGHT ACCESS PANEL FOR DAMPERS ABOVE HAND CEILING, TYPICAL.
- KEYED NOTES:**
- PROVIDE FIRE DAMPERS AT DOORWAY/PENETRATIONS OF VERTICAL DUCT SHAFT.