

JAVALLE BREININGER ARCHITECTS  
 95 Dow Street, Suite 400, Manchester, NH 03103  
 PH 603.822.5450, FX 603.822.7283, www.jbrna.com



**Allied Engineering**  
 National Network of Licensed Mechanical Engineers  
 148 Vermont Street  
 Portland, Maine 04108  
 P 207.271.2200  
 F 207.271.2206  
 www.alliedeng.com



The Park Danforth

The Park Danforth -  
 777 Stevens Avenue,  
 Portland, ME, 04103

777 Stevens Ave, Portland, ME, 04103

NO.	DESCRIPTION	DATE
1	Address: No. 2	2015.05.25




CONTRACT: MECHANICAL PIPING PLAN - GARAGE LEVEL

DRAWN BY	RBH
PROJECT NO.	1206430
DATE	08/08/2015
REVISED	OCTOBER 16, 2015
SCALE	AS SHOWN

**MP1.0C**

Sheet Title: MECHANICAL PIPING PLAN - GARAGE LEVEL  
 CONFORMANCE SET  
 CONTRACT NO. 1206430 - GREENLAND PARK CENTER  
 1000 BURNHAM PLACE, PORTLAND, ME 04103

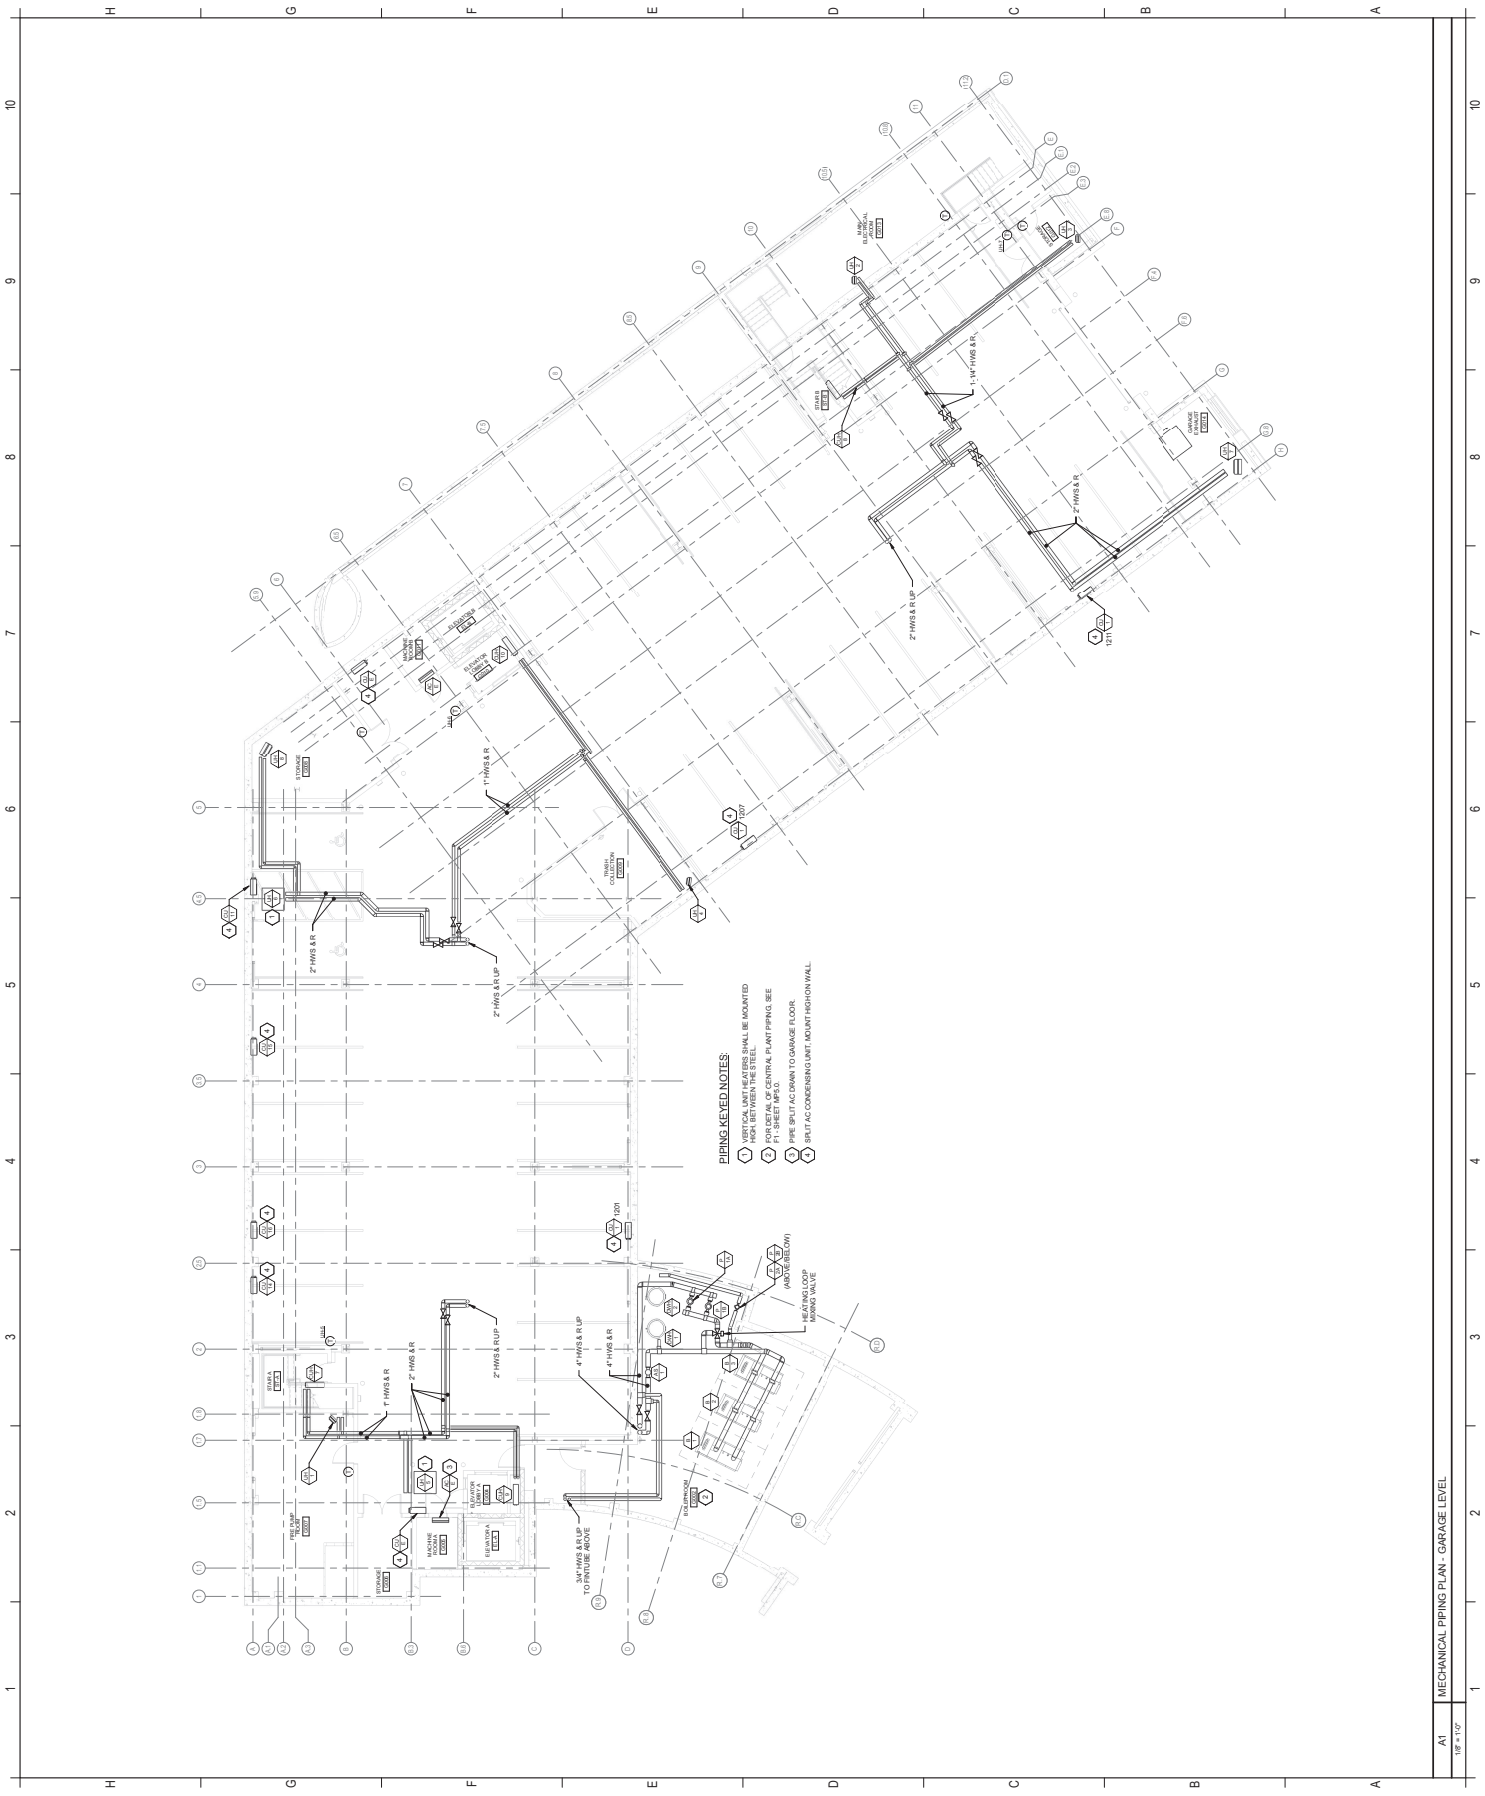

**PIPING KEYED NOTES:**

- 1. MECHANICAL PIPING SHALL BE MOUNTED HIGH BETWEEN THE STEEL
- 2. FOR DETAIL OF CENTRAL PLANT PIPING, SEE P1 - SHEET MP-3.03
- 3. PIPE SPLIT AND DOWN TO GARAGE FLOOR
- 4. MULTIPLE CONDENSING UNIT MOUNTATION WALL

A1 MECHANICAL PIPING PLAN - GARAGE LEVEL  
 1/8" = 1'-0"