



NO.	DESCRIPTION	DATE
1	Addendum No 2	2015-06-25

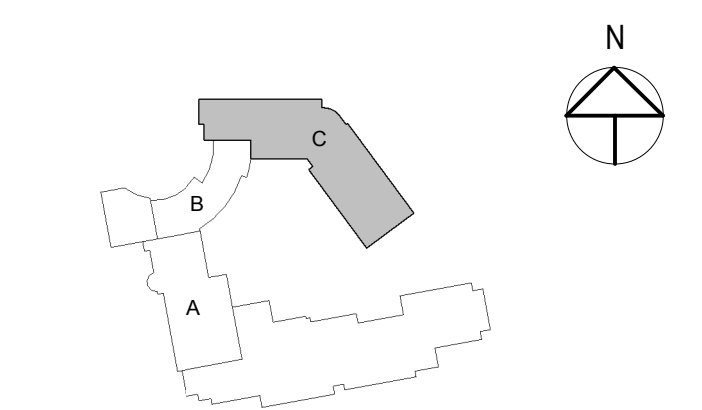


CONTENT:	
ENLARGED PLANS	
DRAWN BY:	Author
PROJECT NO.:	-
DATE:	06/05/2015
REVISED:	
SCALE:	AS NOTED
<b>E4.1</b>	
Project Phase	
100% CONSTRUCTION DOCUMENTS	
COPYRIGHT © 2014 BY LAVALLEE BRENSINGER PROFESSIONAL ASSOCIATION. ALL RIGHTS RESERVED. NO REPRODUCTION WITHOUT PERMISSION.	

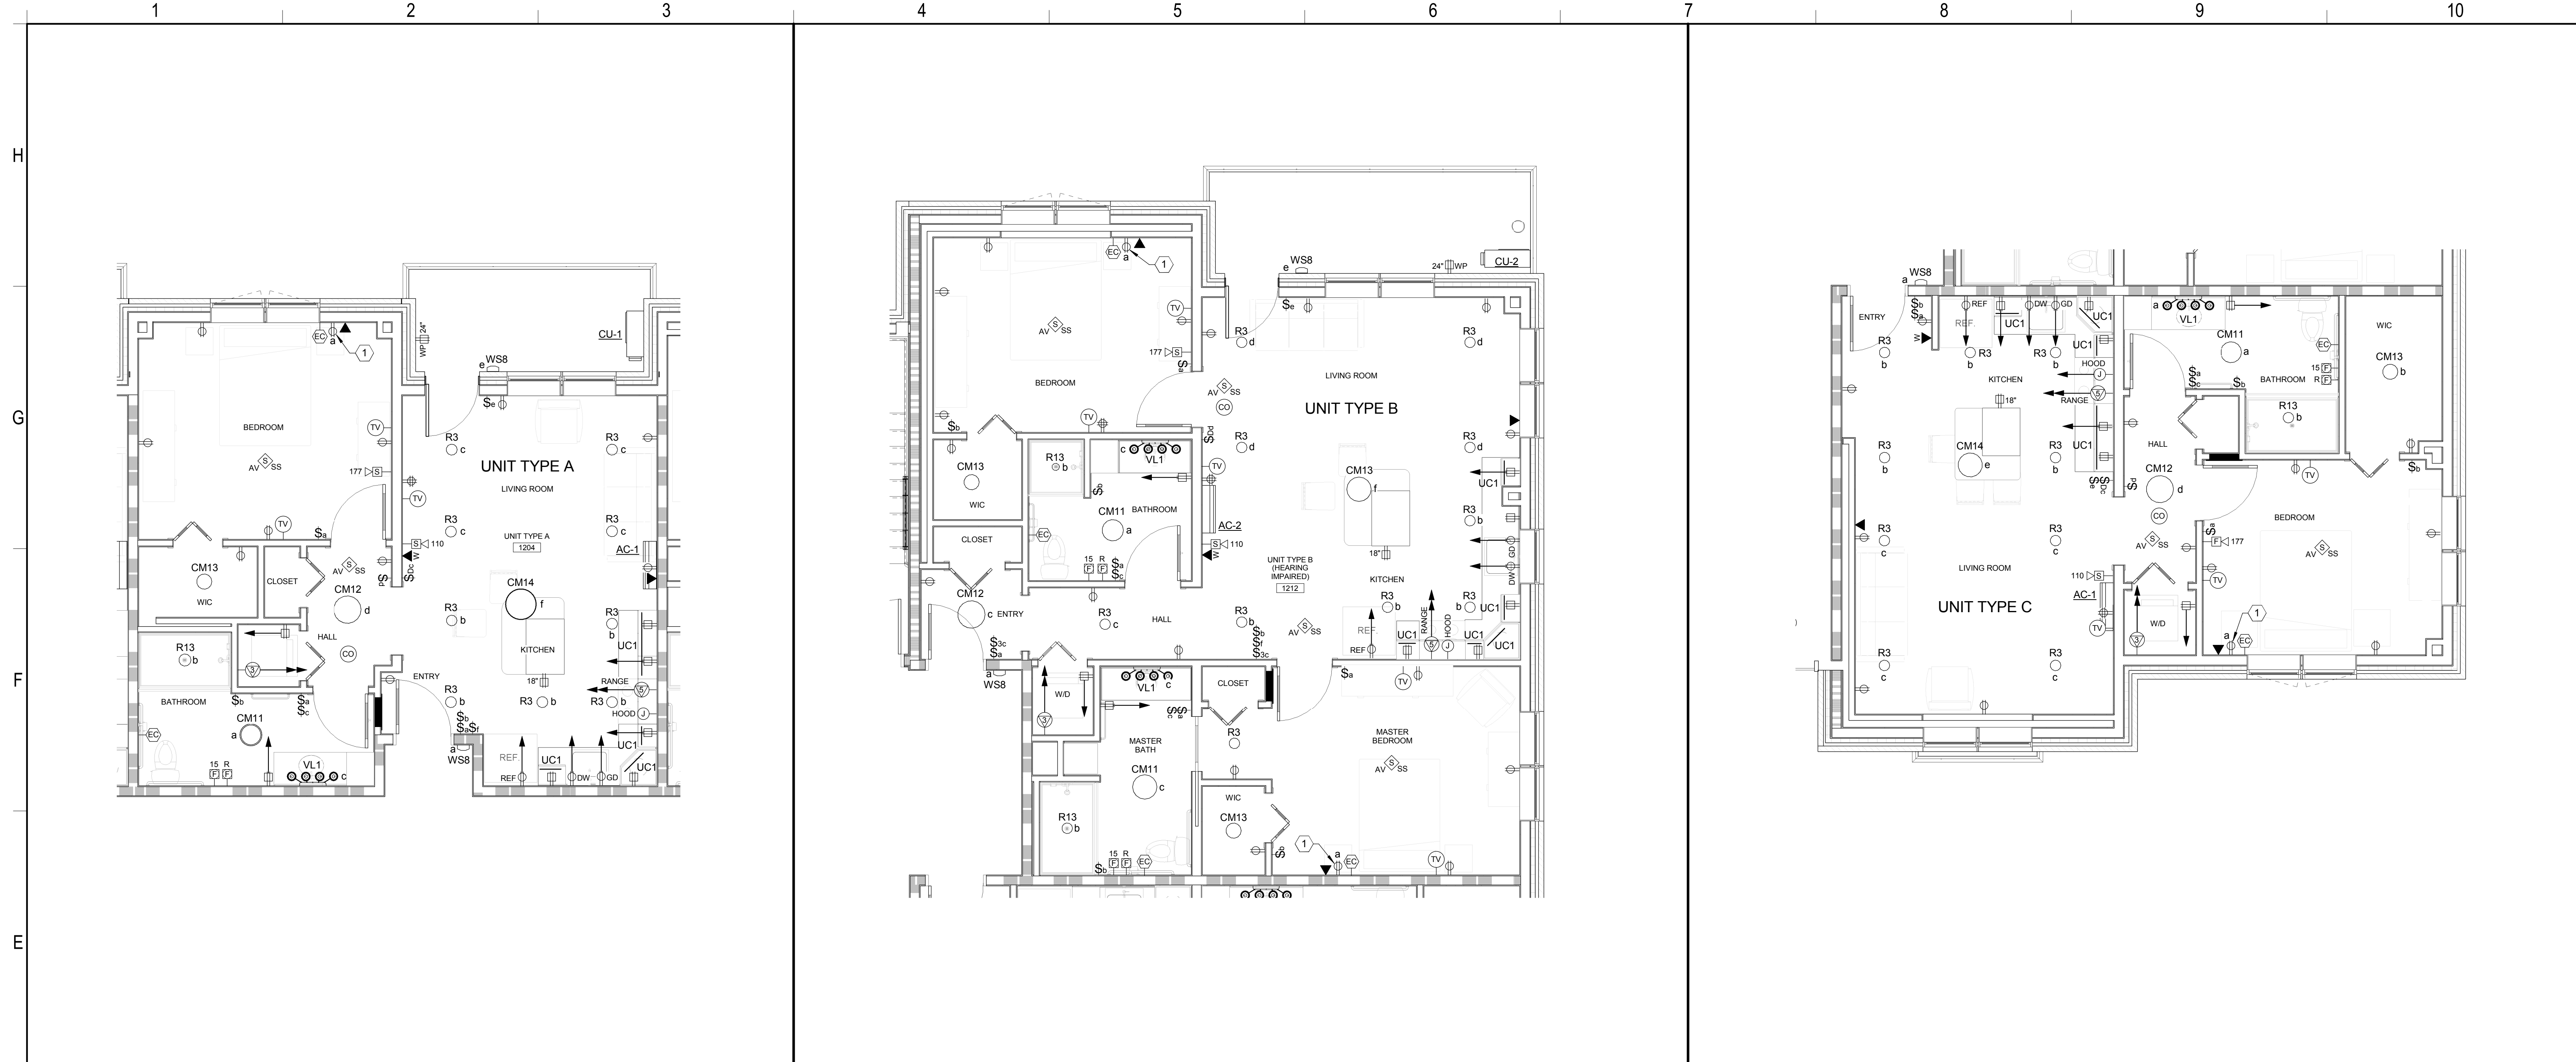

E1	TYPICAL UNIT TYPE A	E4	TYPICAL UNIT TYPE B	E7	TYPICAL UNIT TYPE C
----	---------------------	----	---------------------	----	---------------------

1/4" = 1'-0"

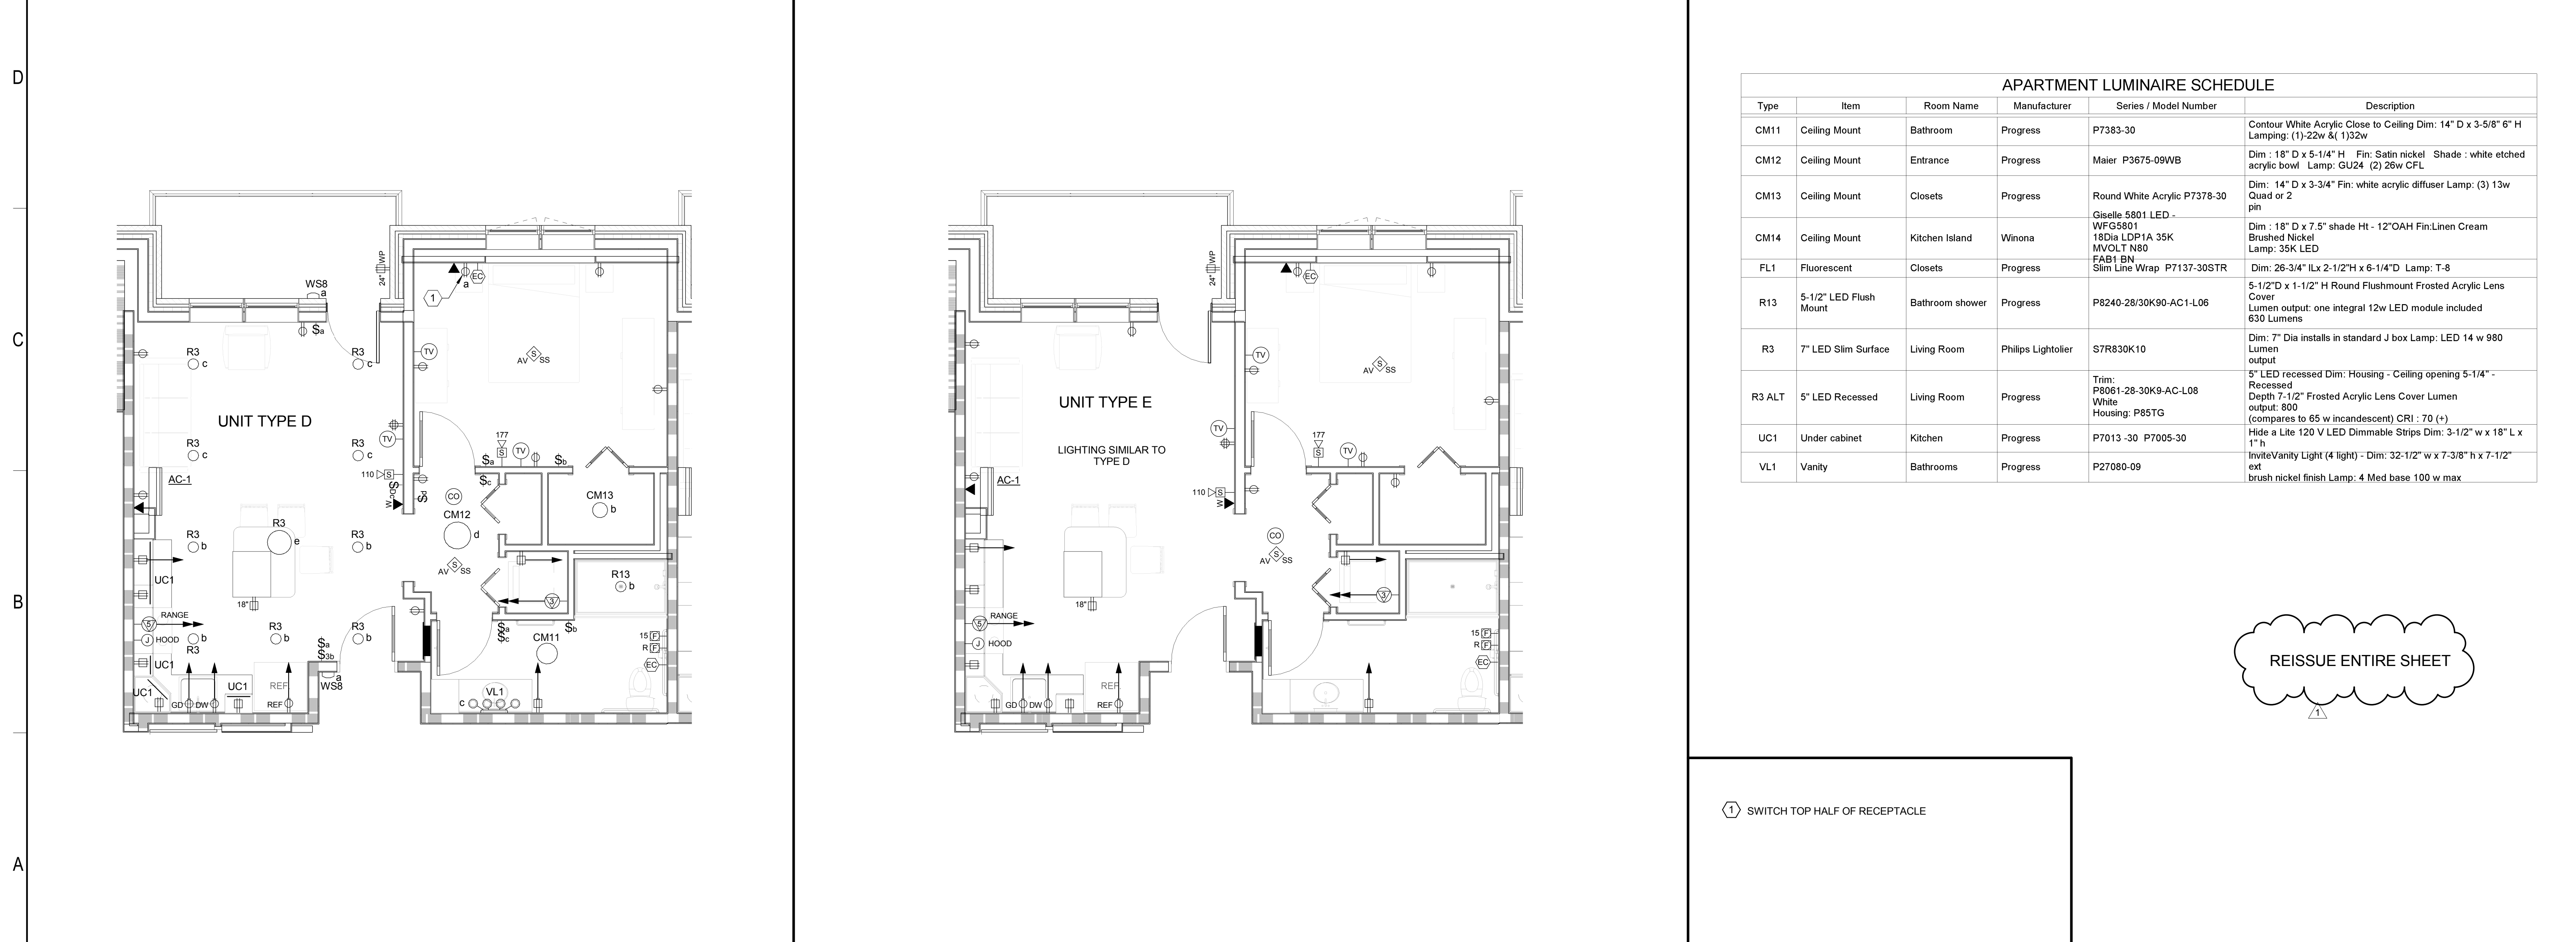

A1	TYPICAL UNIT TYPE D	A5	TYPICAL UNIT TYPE E	A7	KEY NOTES
----	---------------------	----	---------------------	----	-----------

1/4" = 1'-0"

APARTMENT LUMINAIRE SCHEDULE					
Type	Item	Room Name	Manufacturer	Series / Model Number	Description
CM11	Ceiling Mount	Bathroom	Progress	P7383-30	Contour White Acrylic Close to Ceiling Dim: 14" D x 3-5/8" 6" H Lamping: (1)-22w & (1)32w
CM12	Ceiling Mount	Entrance	Progress	Maier P3675-09WB	Dim: 18" D x 5-1/4" H Fin: Satin nickel Shade: white etched acrylic bowl Lamp: GU24 (2) 26w CFL
CM13	Ceiling Mount	Closets	Progress	Round White Acrylic P7378-30	Dim: 14" D x 3-3/4" Fin: white acrylic diffuser Lamp: (3) 13w Quad or 2 pin
CM14	Ceiling Mount	Kitchen Island	Winona	Giselle 5801 LED - WFG5801 18Dia LDP1A 35K MVOLT N80 FAB1 BN Slim Line Wrap P7137-30STR	Dim: 18" D x 7.5" shade Ht - 12" OAH Fin: Linen Cream Brushed Nickel Lamp: 35K LED
FL1	Fluorescent	Closets	Progress	P7137-30STR	Dim: 26-3/4" L x 2-1/2" H x 6-1/4" D Lamp: T-8
R13	5-1/2" LED Flush Mount	Bathroom shower	Progress	P8240-28/30K90-AC1-L06	5-1/2" D x 1-1/2" H Round Flushmount Frosted Acrylic Lens Cover Lumen output: one integral 12w LED module included 630 Lumens
R3	7" LED Slim Surface	Living Room	Philips Lightolier	S7R830K10	Dim: 7" Dia installs in standard J box Lamp: LED 14 w 980 Lumen output 5" LED recessed Dim: Housing - Ceiling opening 5-1/4" - Recessed Depth 7-1/2" Frosted Acrylic Lens Cover Lumen output: 800 (compares to 65 w incandescent) CRI: 70 (+) InviteVanity Light (4 light) - Dim: 32-1/2" w x 7-3/8" h x 7-1/2" ext brush nickel finish Lamp: 4 Med base 100 w max
R3 ALT	5" LED Recessed	Living Room	Progress	Trim: P8061-28-30K9-AC-L08 White Housing: P85TG	5" LED recessed Dim: Housing - Ceiling opening 5-1/4" - Recessed Depth 7-1/2" Frosted Acrylic Lens Cover Lumen output: 800 (compares to 65 w incandescent) CRI: 70 (+) InviteVanity Light (4 light) - Dim: 32-1/2" w x 7-3/8" h x 7-1/2" ext brush nickel finish Lamp: 4 Med base 100 w max
UC1	Under cabinet	Kitchen	Progress	P7013-30 P7005-30	Hide a Lite 120 V LED Dimmable Strips Dim: 3-1/2" w x 18" L x 1" h InviteVanity Light (4 light) - Dim: 32-1/2" w x 7-3/8" h x 7-1/2" ext brush nickel finish Lamp: 4 Med base 100 w max
VL1	Vanity	Bathrooms	Progress	P27080-09	InviteVanity Light (4 light) - Dim: 32-1/2" w x 7-3/8" h x 7-1/2" ext brush nickel finish Lamp: 4 Med base 100 w max

① SWITCH TOP HALF OF RECEPTACLE

REISSUE ENTIRE SHEET

6/5/2015 2:45:03 PM N:\Projects\2014\1018 - Park Danforth\100 Drawing Files - REVIT\2015\1018.rvt