


verizon wireless
 400 FRIBERG PARKWAY
 WESTBOROUGH, MA 01581
 PHONE: (508) 330-3300
 FAX: (781) 481-1396

amec
 343 Gorham Road, South Portland ME 04108
 P: (207) 761-1770 F: (207) 774-1246 www.amec.com

PROJECT COORDINATION BY:

SURVEYOR

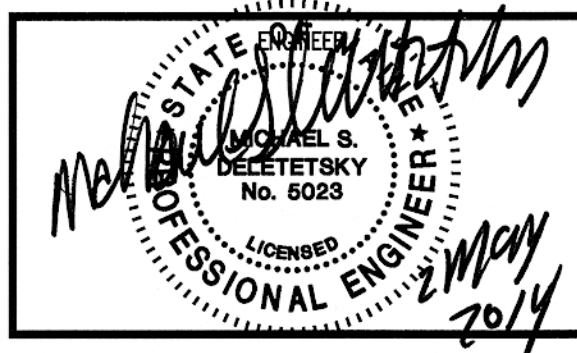

PROJECT NO: 3618148351

DRAWN BY: CBM

RELEASED BY: MSD

SUBMITTALS

5/2/14 ISSUED FOR CONSTRUCTION

PORTLAND 5
 20130930169


52 CANCO ROAD
 PORTLAND, ME 04103

SHEET TITLE

SHELTER FLOOR PLAN

SHEET NUMBER

D-3

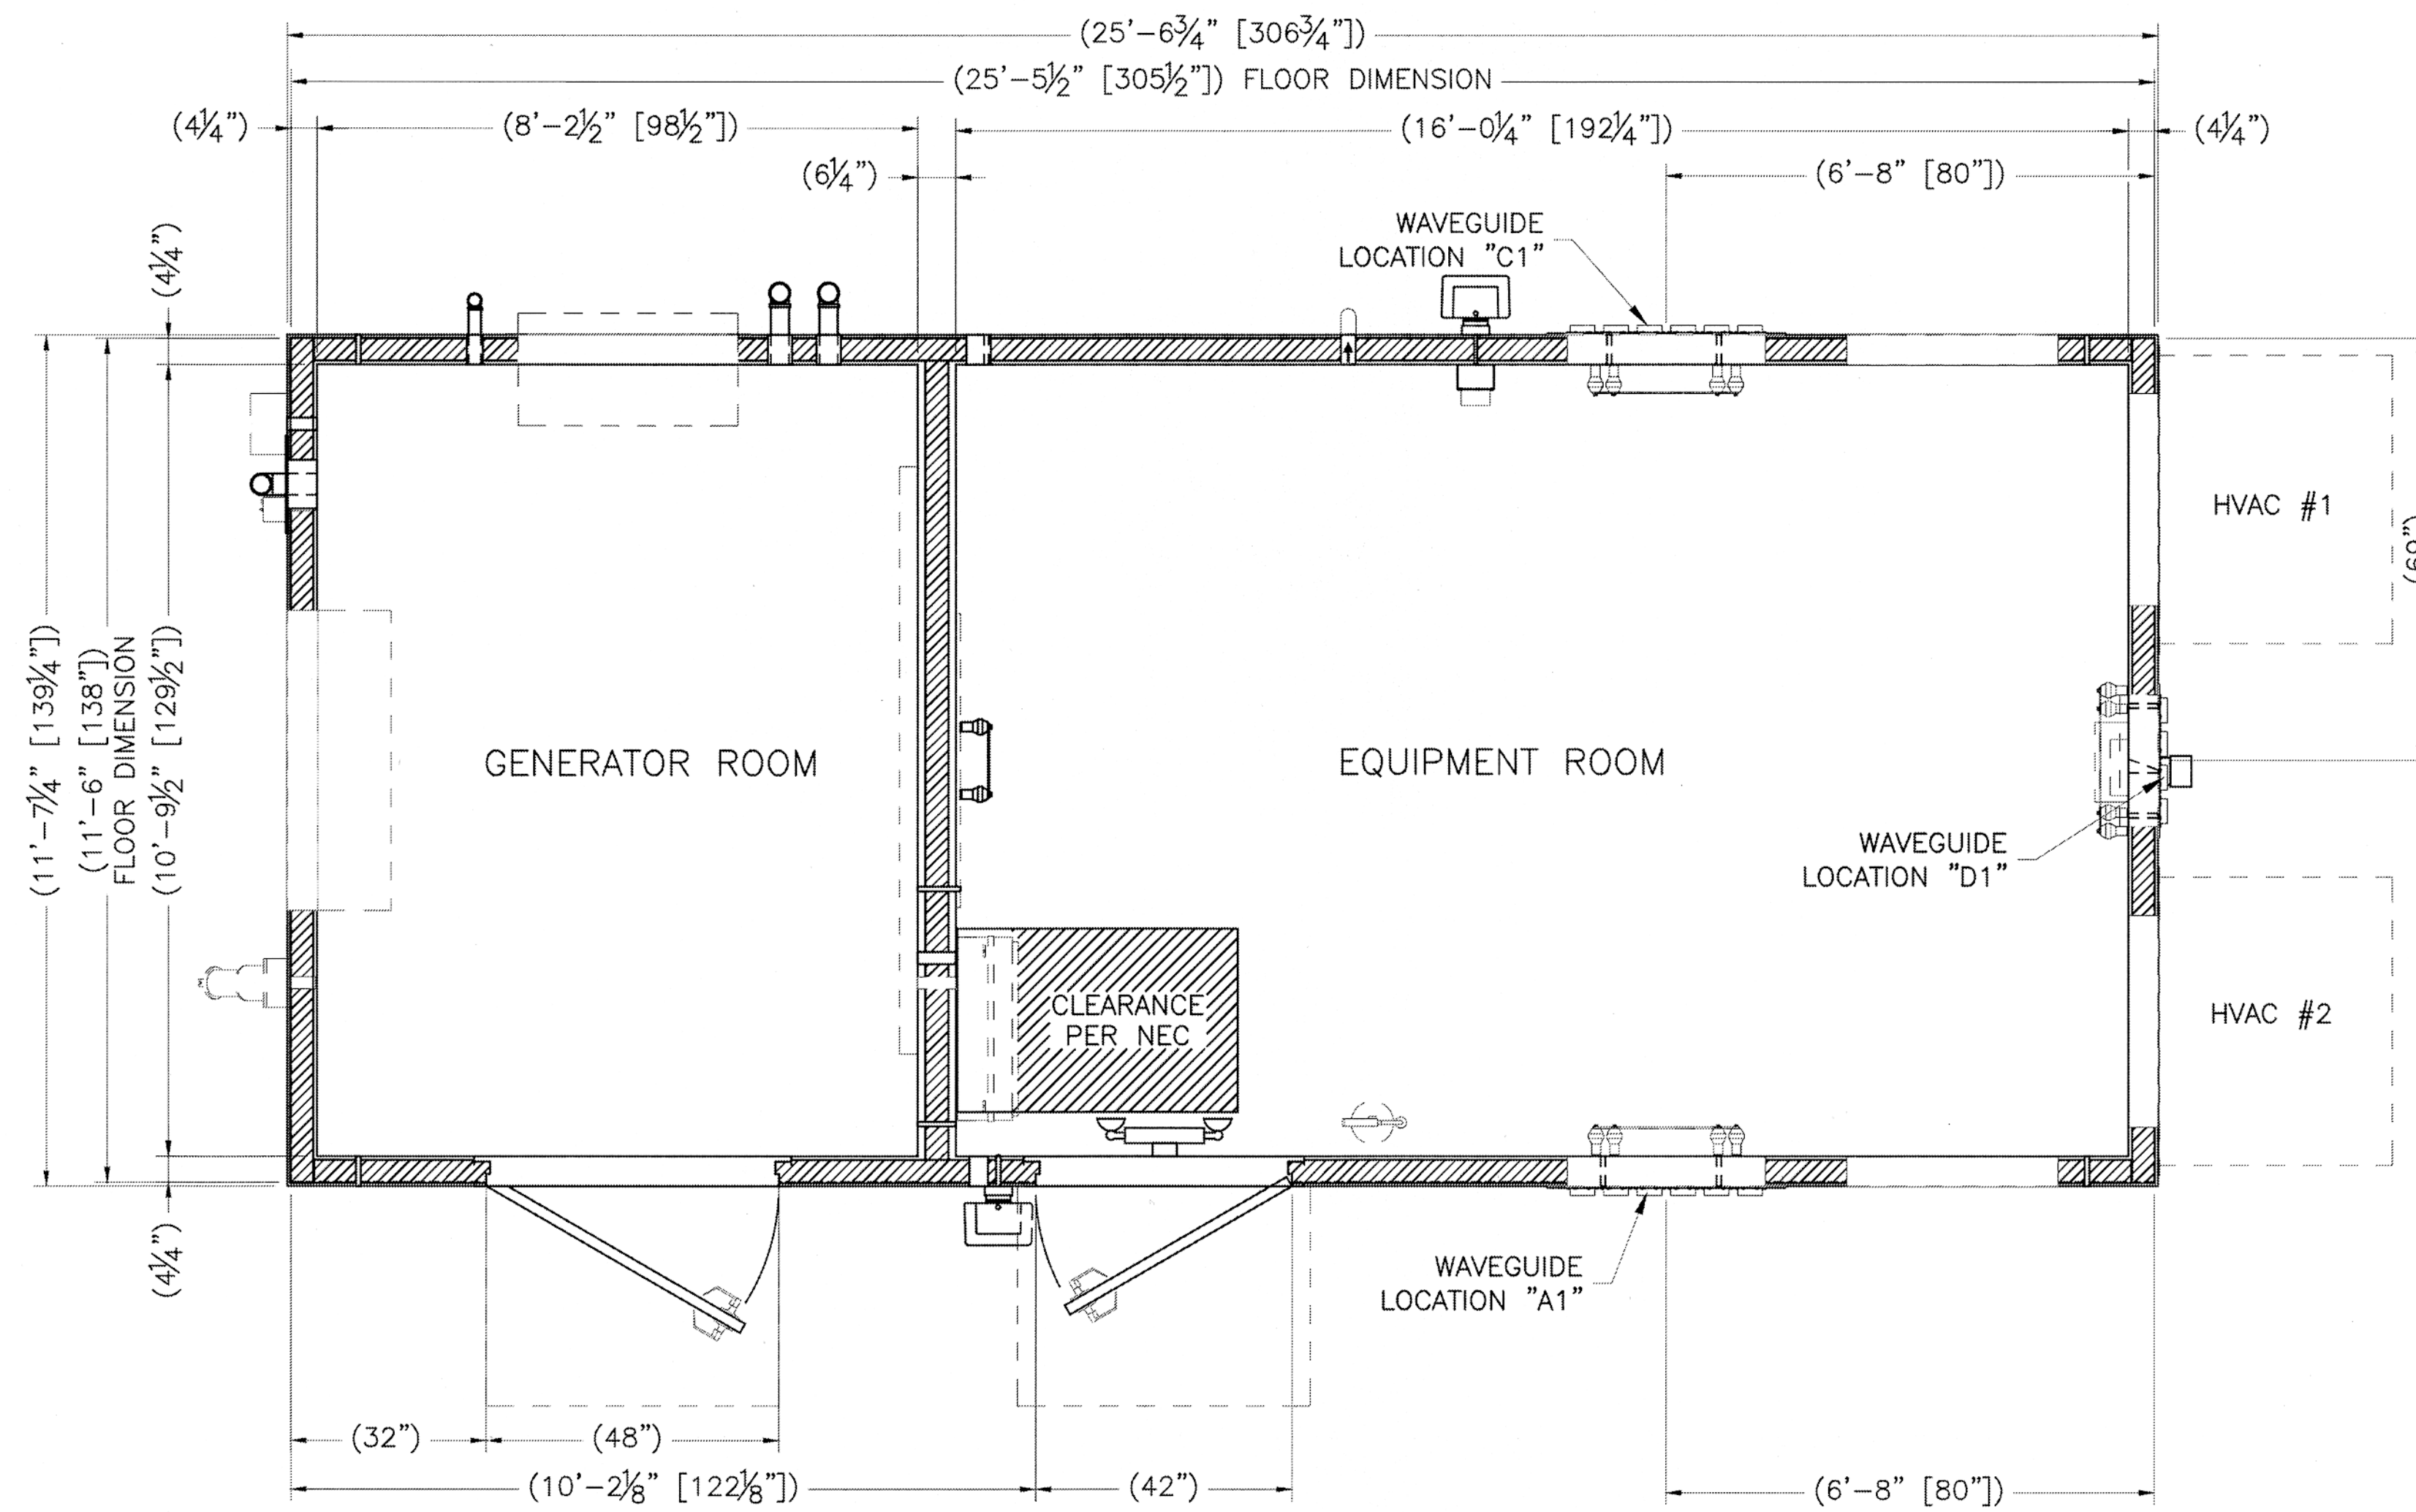

FLOOR PLAN
 296.63 SQ. FT. EXTERIOR AREA
 172.89 SQ. FT. EQUIPMENT ROOM
 88.58 SQ. FT. GENERATOR ROOM

