



WINTON SCOTT ARCHITECTS

5 Milk Street, Portland, ME 04101
207.774.4811 | wintonscott.com

Structural Engineering:
STRUCTURAL INTEGRITY CONSULTING ENGINEERS, INC.

46 Forest Avenue
Portland, ME 04101
T. 207.774.4614
structuralinteg.com

HVAC & Plumbing Engineering:
HOLBROOK ENGINEERING, LLC

52 Heath Rd
Saco, ME 04072
T. 207.283.9127
holbrookengineering.com

Electrical Engineering:
SWIFT CURRENT ENGINEERING SERVICES


Royal River Center, Unit 8B
10 Forest Falls Drive
Yarmouth, ME 04096
T. 207.847.9280

CITY OF PORTLAND
DEPARTMENT
HEADQUARTERS:

-Parks, Recreation &
Facilities
-Public Works

RENOVATION PROJECT

212 Conco Road,
Portland

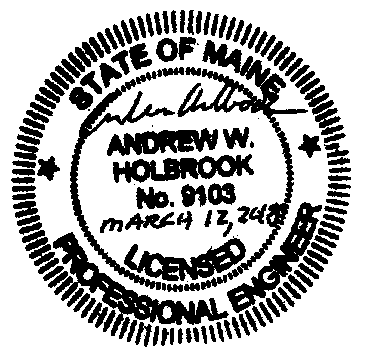


REVIEW SET

Scale: 1/16" = 1'-0"

HVAC DEMOLITION
PLANS

M1.1


March 12, 2018

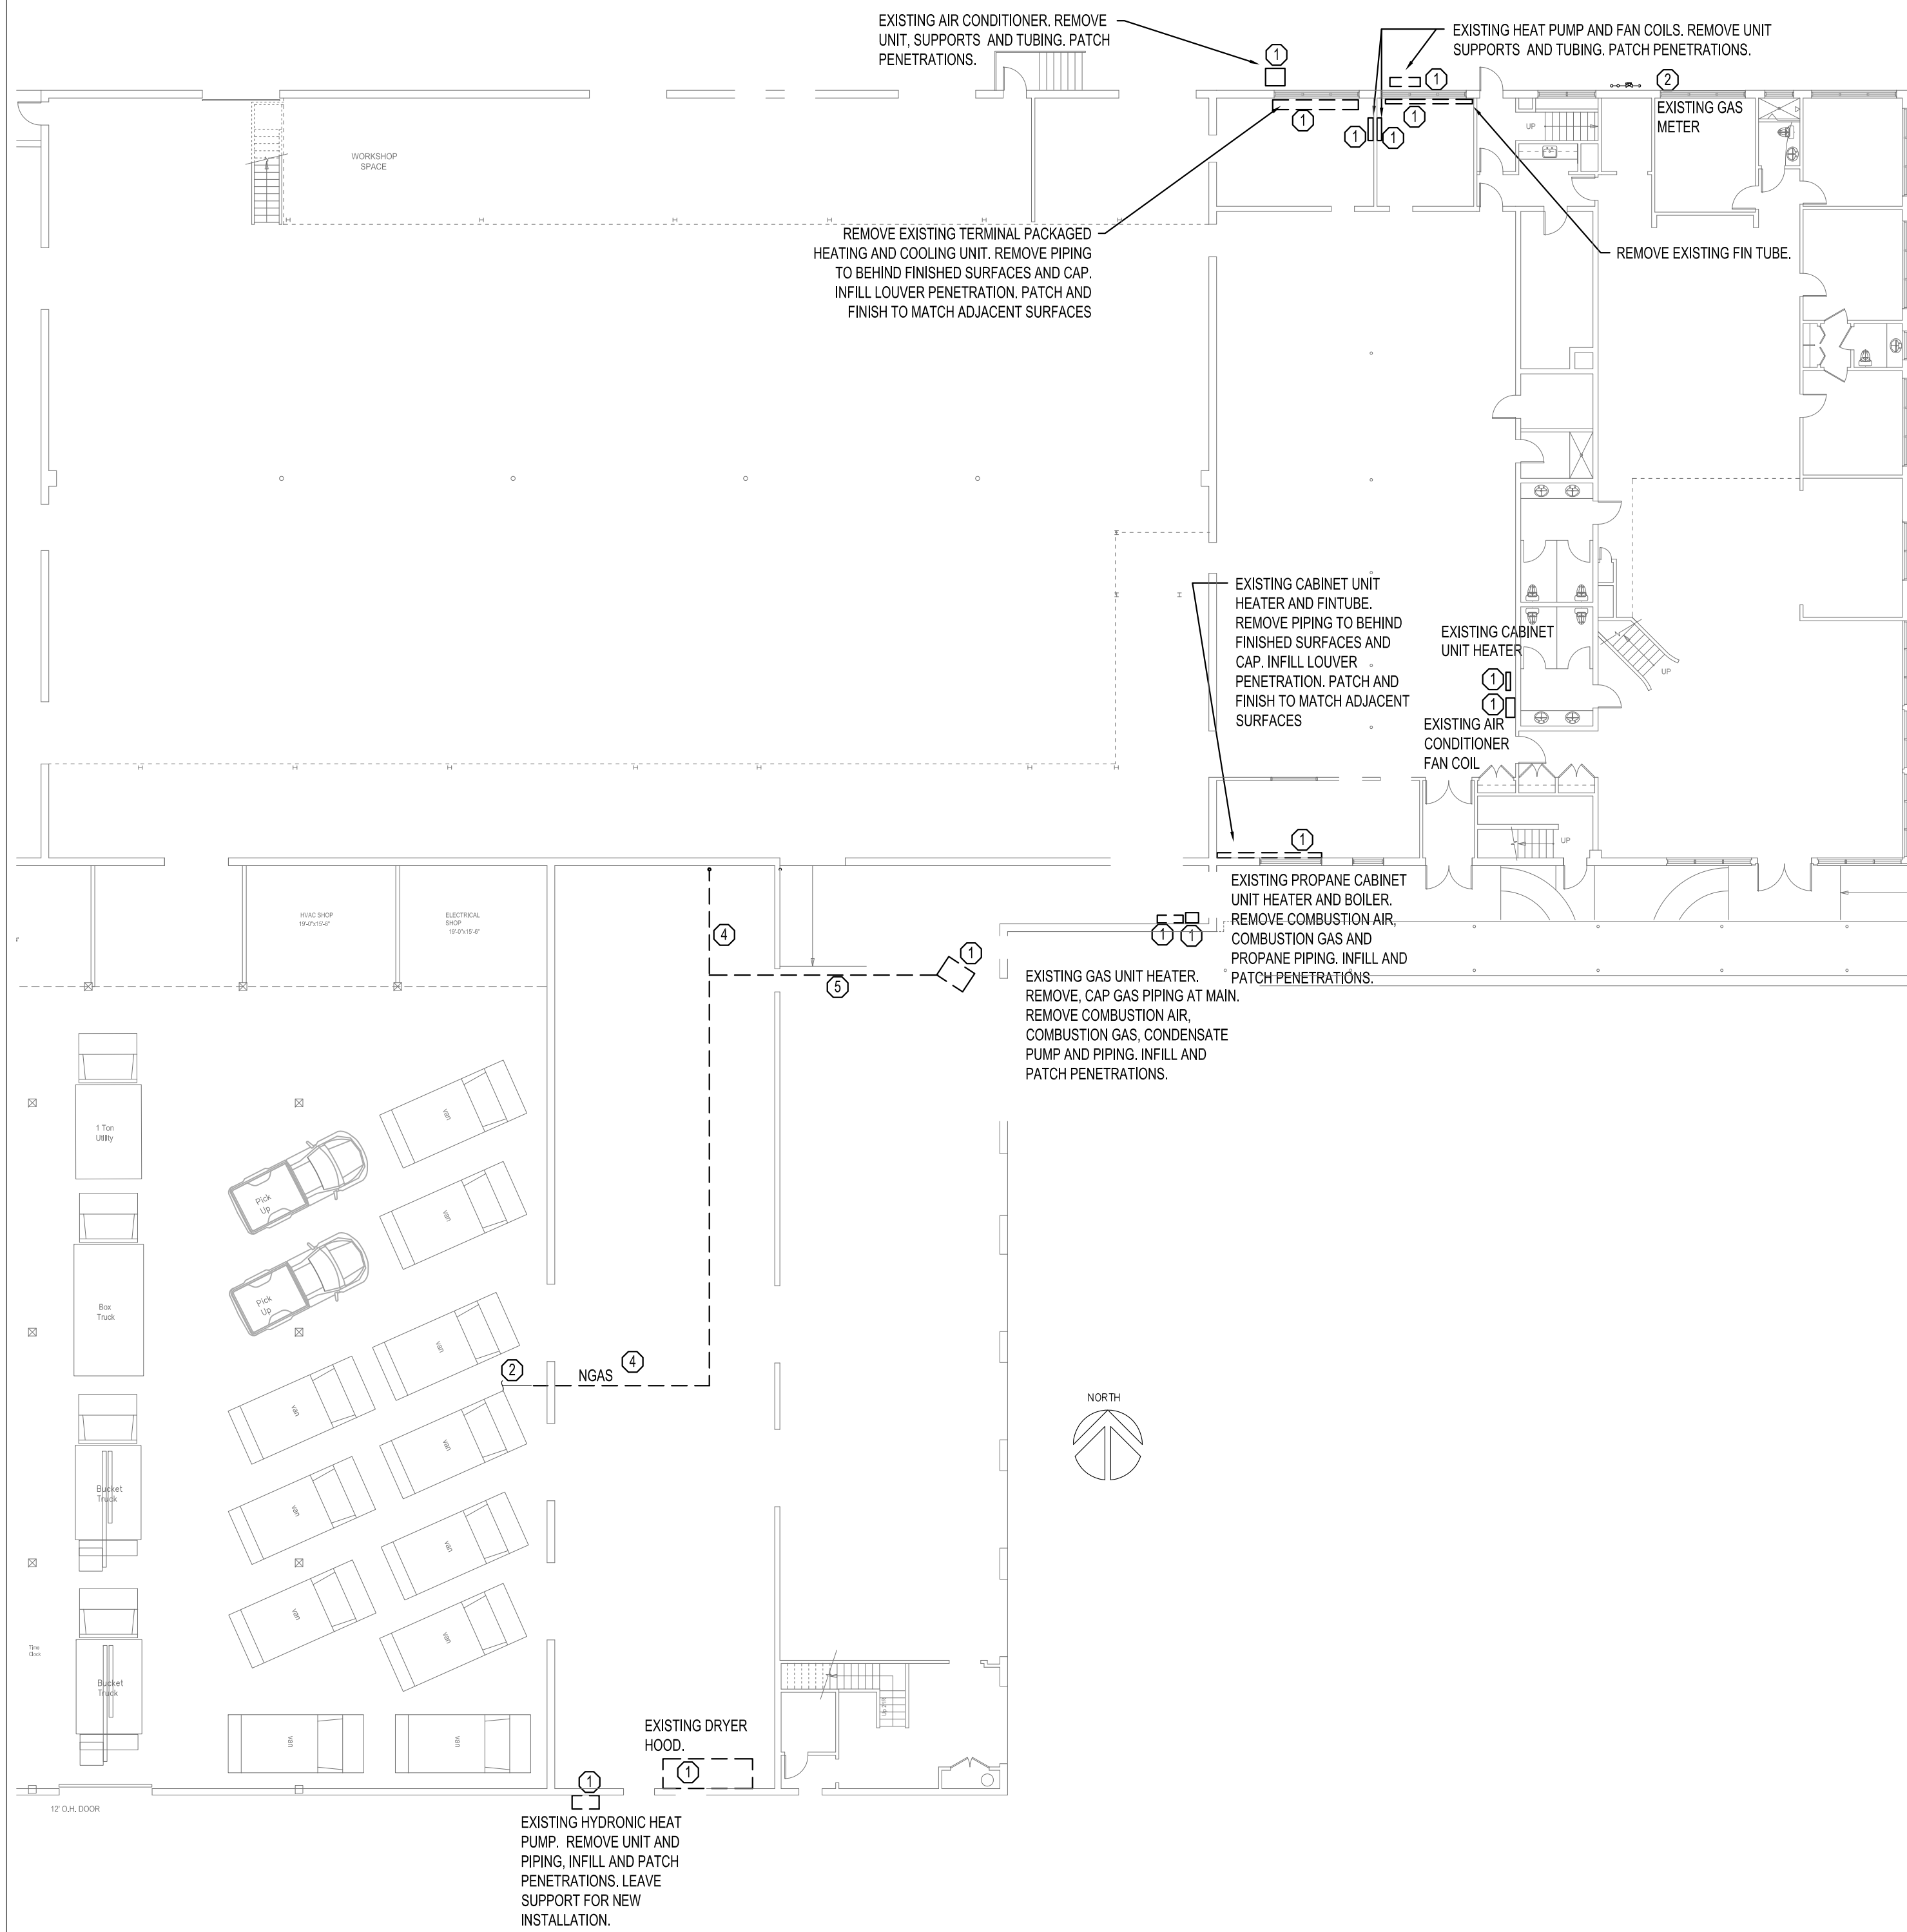

FIRST FLOOR HVAC PLAN - DEMOLITION
SCALE: 1/16"=1'-0"

KEYED DEMOLITION NOTES:

- ① REMOVE ITEM. CAP ANY CONNECTIONS TO REMAIN BEHIND FINISHED SURFACE. INFILL AND PATCH SURFACE TO MATCH ADJACENT FINISH.
- ② EXISTING TO REMAIN.
- ③ REMOVE AND DELIVER TO CITY PERSONNEL FOR REUSE.
- ④ REMOVE ALL PIPING IN THIS AREA TO ALLOW FOR ARCHIVE VAULT. SEE NEW PLANS FOR NEW CONNECTING PIPING.
- ⑤ REMOVE PIPING. CAP ANY PIPING TO REMAIN.
- ⑥ DIFFUSER/GRILLE AND DUCT TO BE RELOCATED.
- ⑦ THERMOSTAT TO BE RELOCATED.

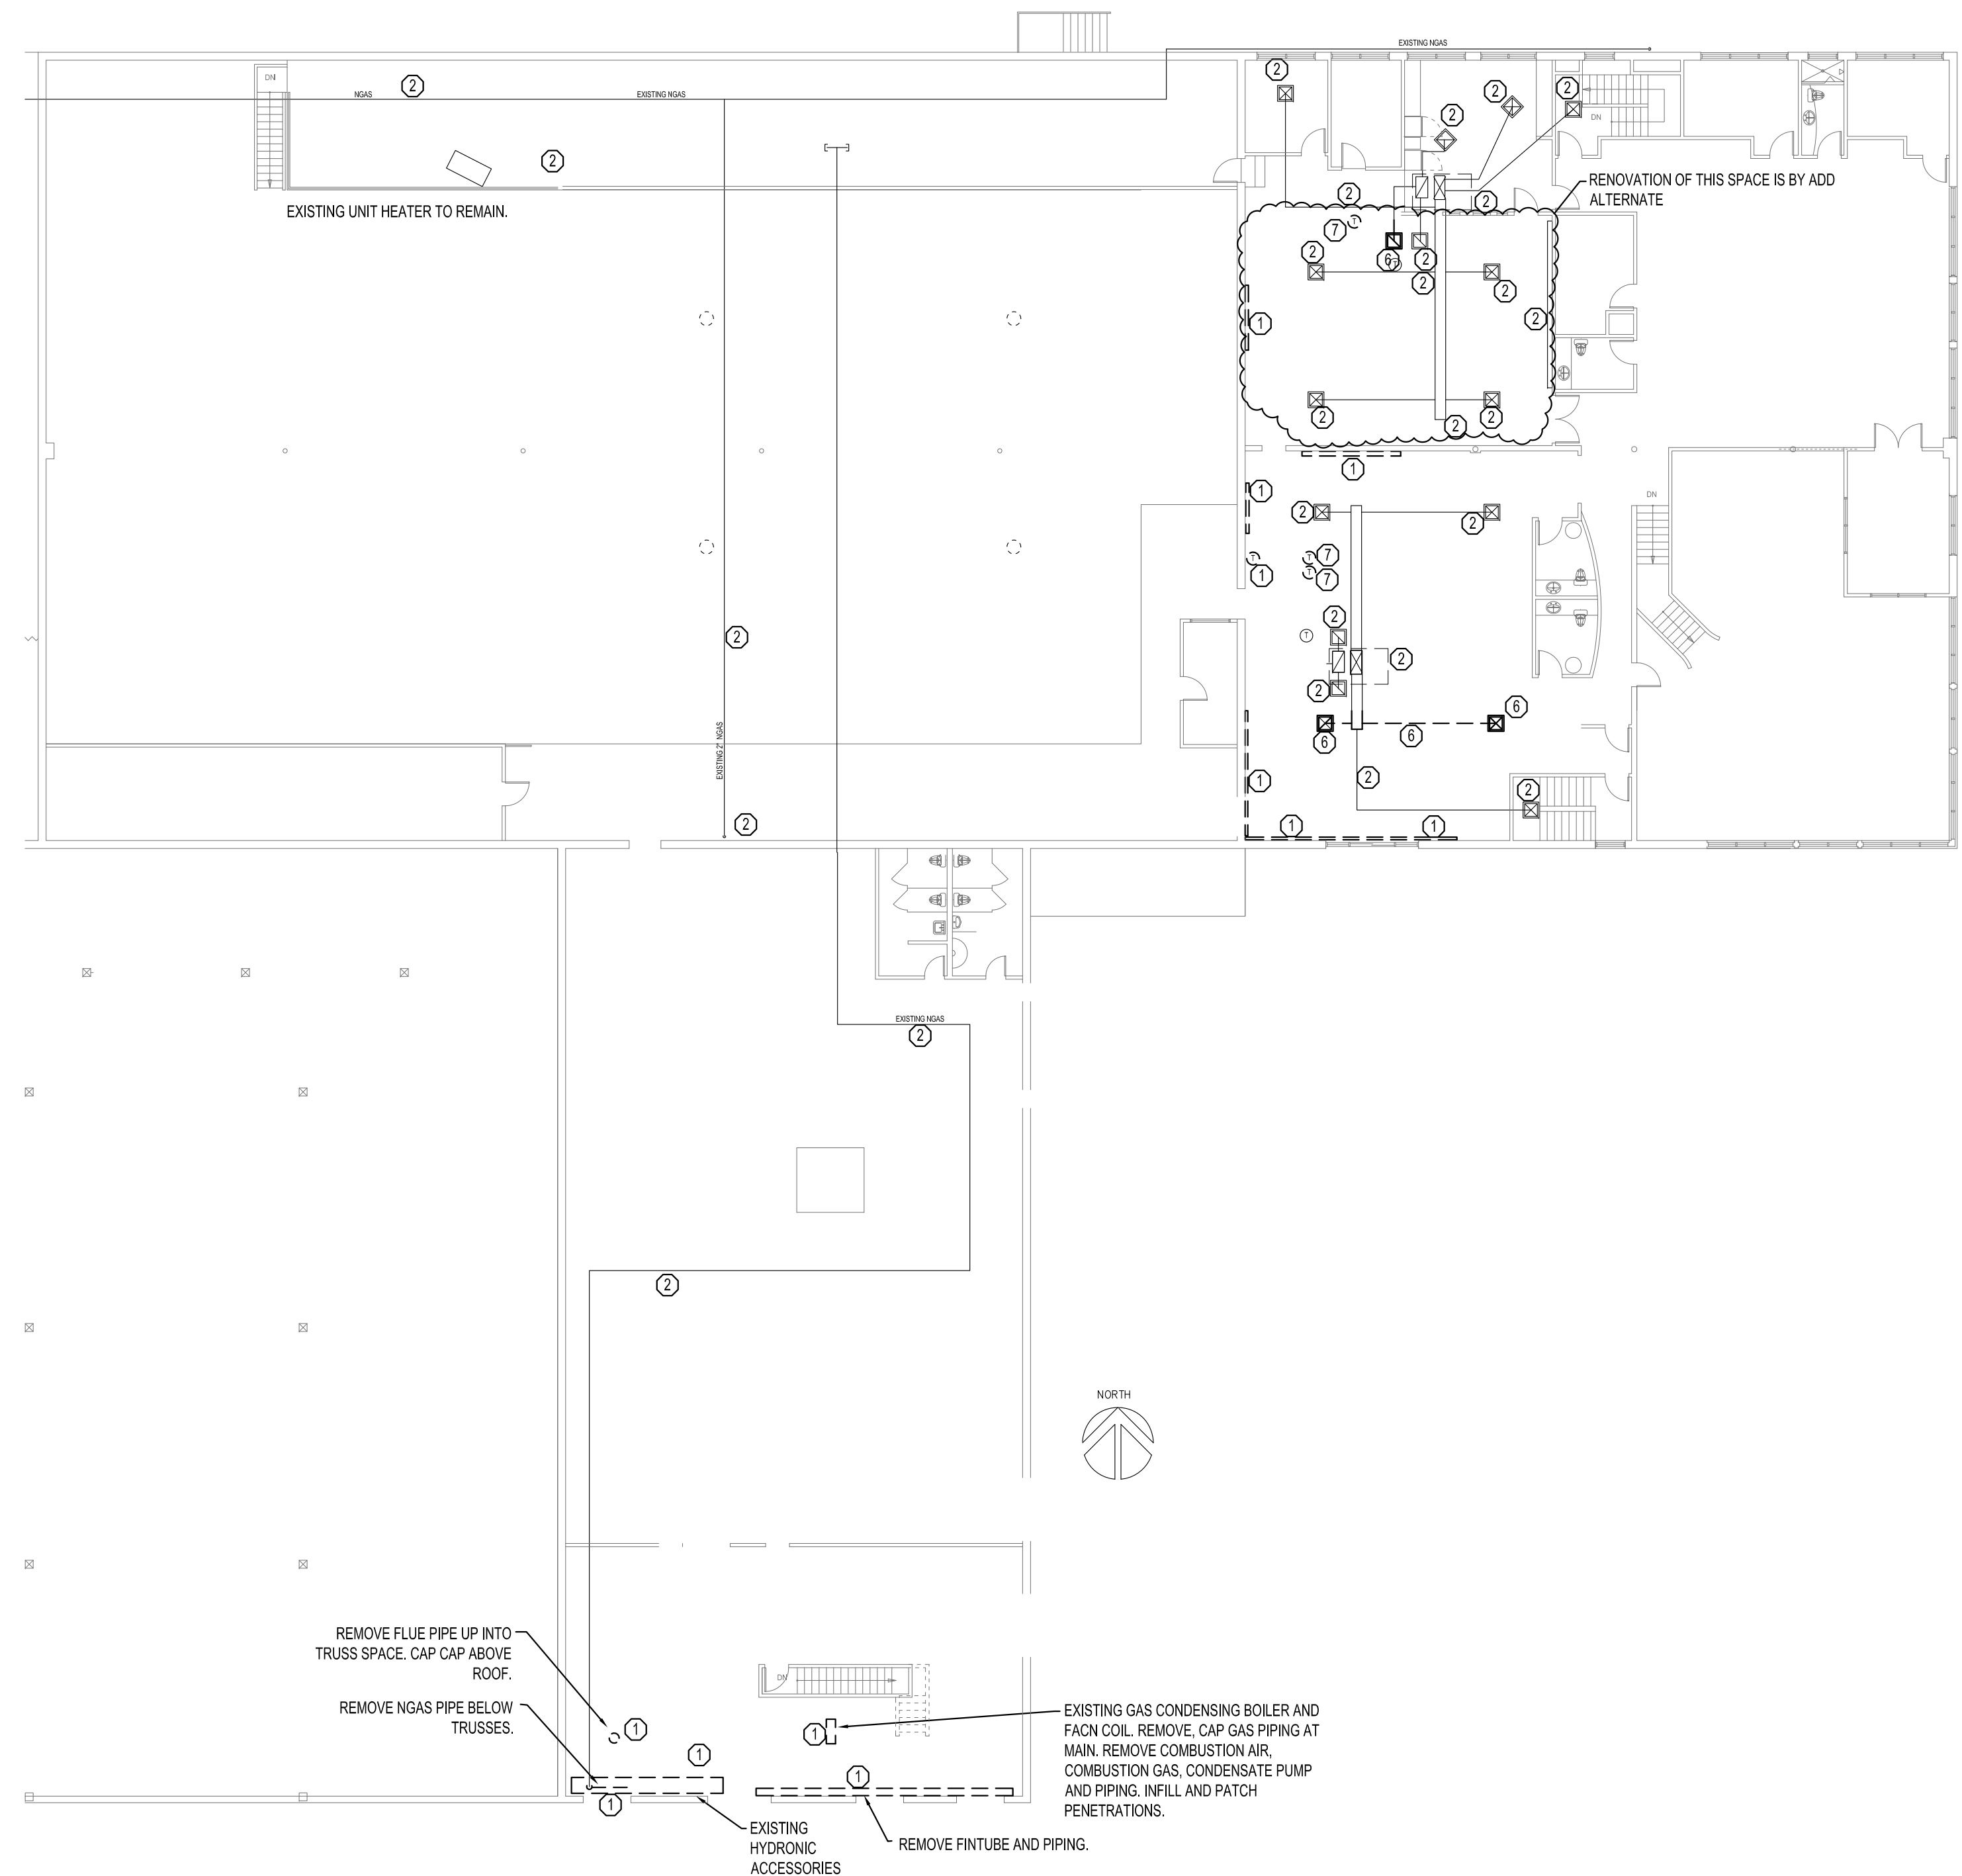

SECOND FLOOR HVAC PLAN - DEMOLITION
SCALE: 1/16"=1'-0"

STATE FIRE MARSHAL REVIEW
03/12/2018