



WINTON SCOTT ARCHITECTS

5 Milk Street, Portland, ME 04101  
207.774.4811 | wintonscott.com

Structural Engineering:  
STRUCTURAL INTEGRITY CONSULTING ENGINEERS, INC.

46 Forest Avenue  
Portland, ME 04101  
T. 207.774.4614  
structuralinteg.com

HVAC & Plumbing Engineering:  
HOLBROOK ENGINEERING, LLC

52 Heath Rd  
Saco, ME 04072  
T. 207.283.9127  
holbrookengineering.com

Electrical Engineering:  
SWIFT CURRENT ENGINEERING SERVICES


Royal River Center, Unit 8B  
10 Forest Falls Drive  
Yarmouth, ME 04096  
T. 207.847.9280

CITY OF PORTLAND  
DEPARTMENT HEADQUARTERS:

-Parks, Recreation & Facilities  
-Public Works

RENOVATION PROJECT

212 Conco Road,  
Portland

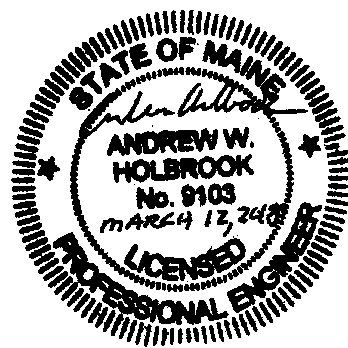

REVIEW SET



Scale: 1/16" = 1'-0"

HVAC ROOF PLAN

M2.7

March 12, 2018

STATE FIRE MARSHAL REVIEW  
03/12/2018

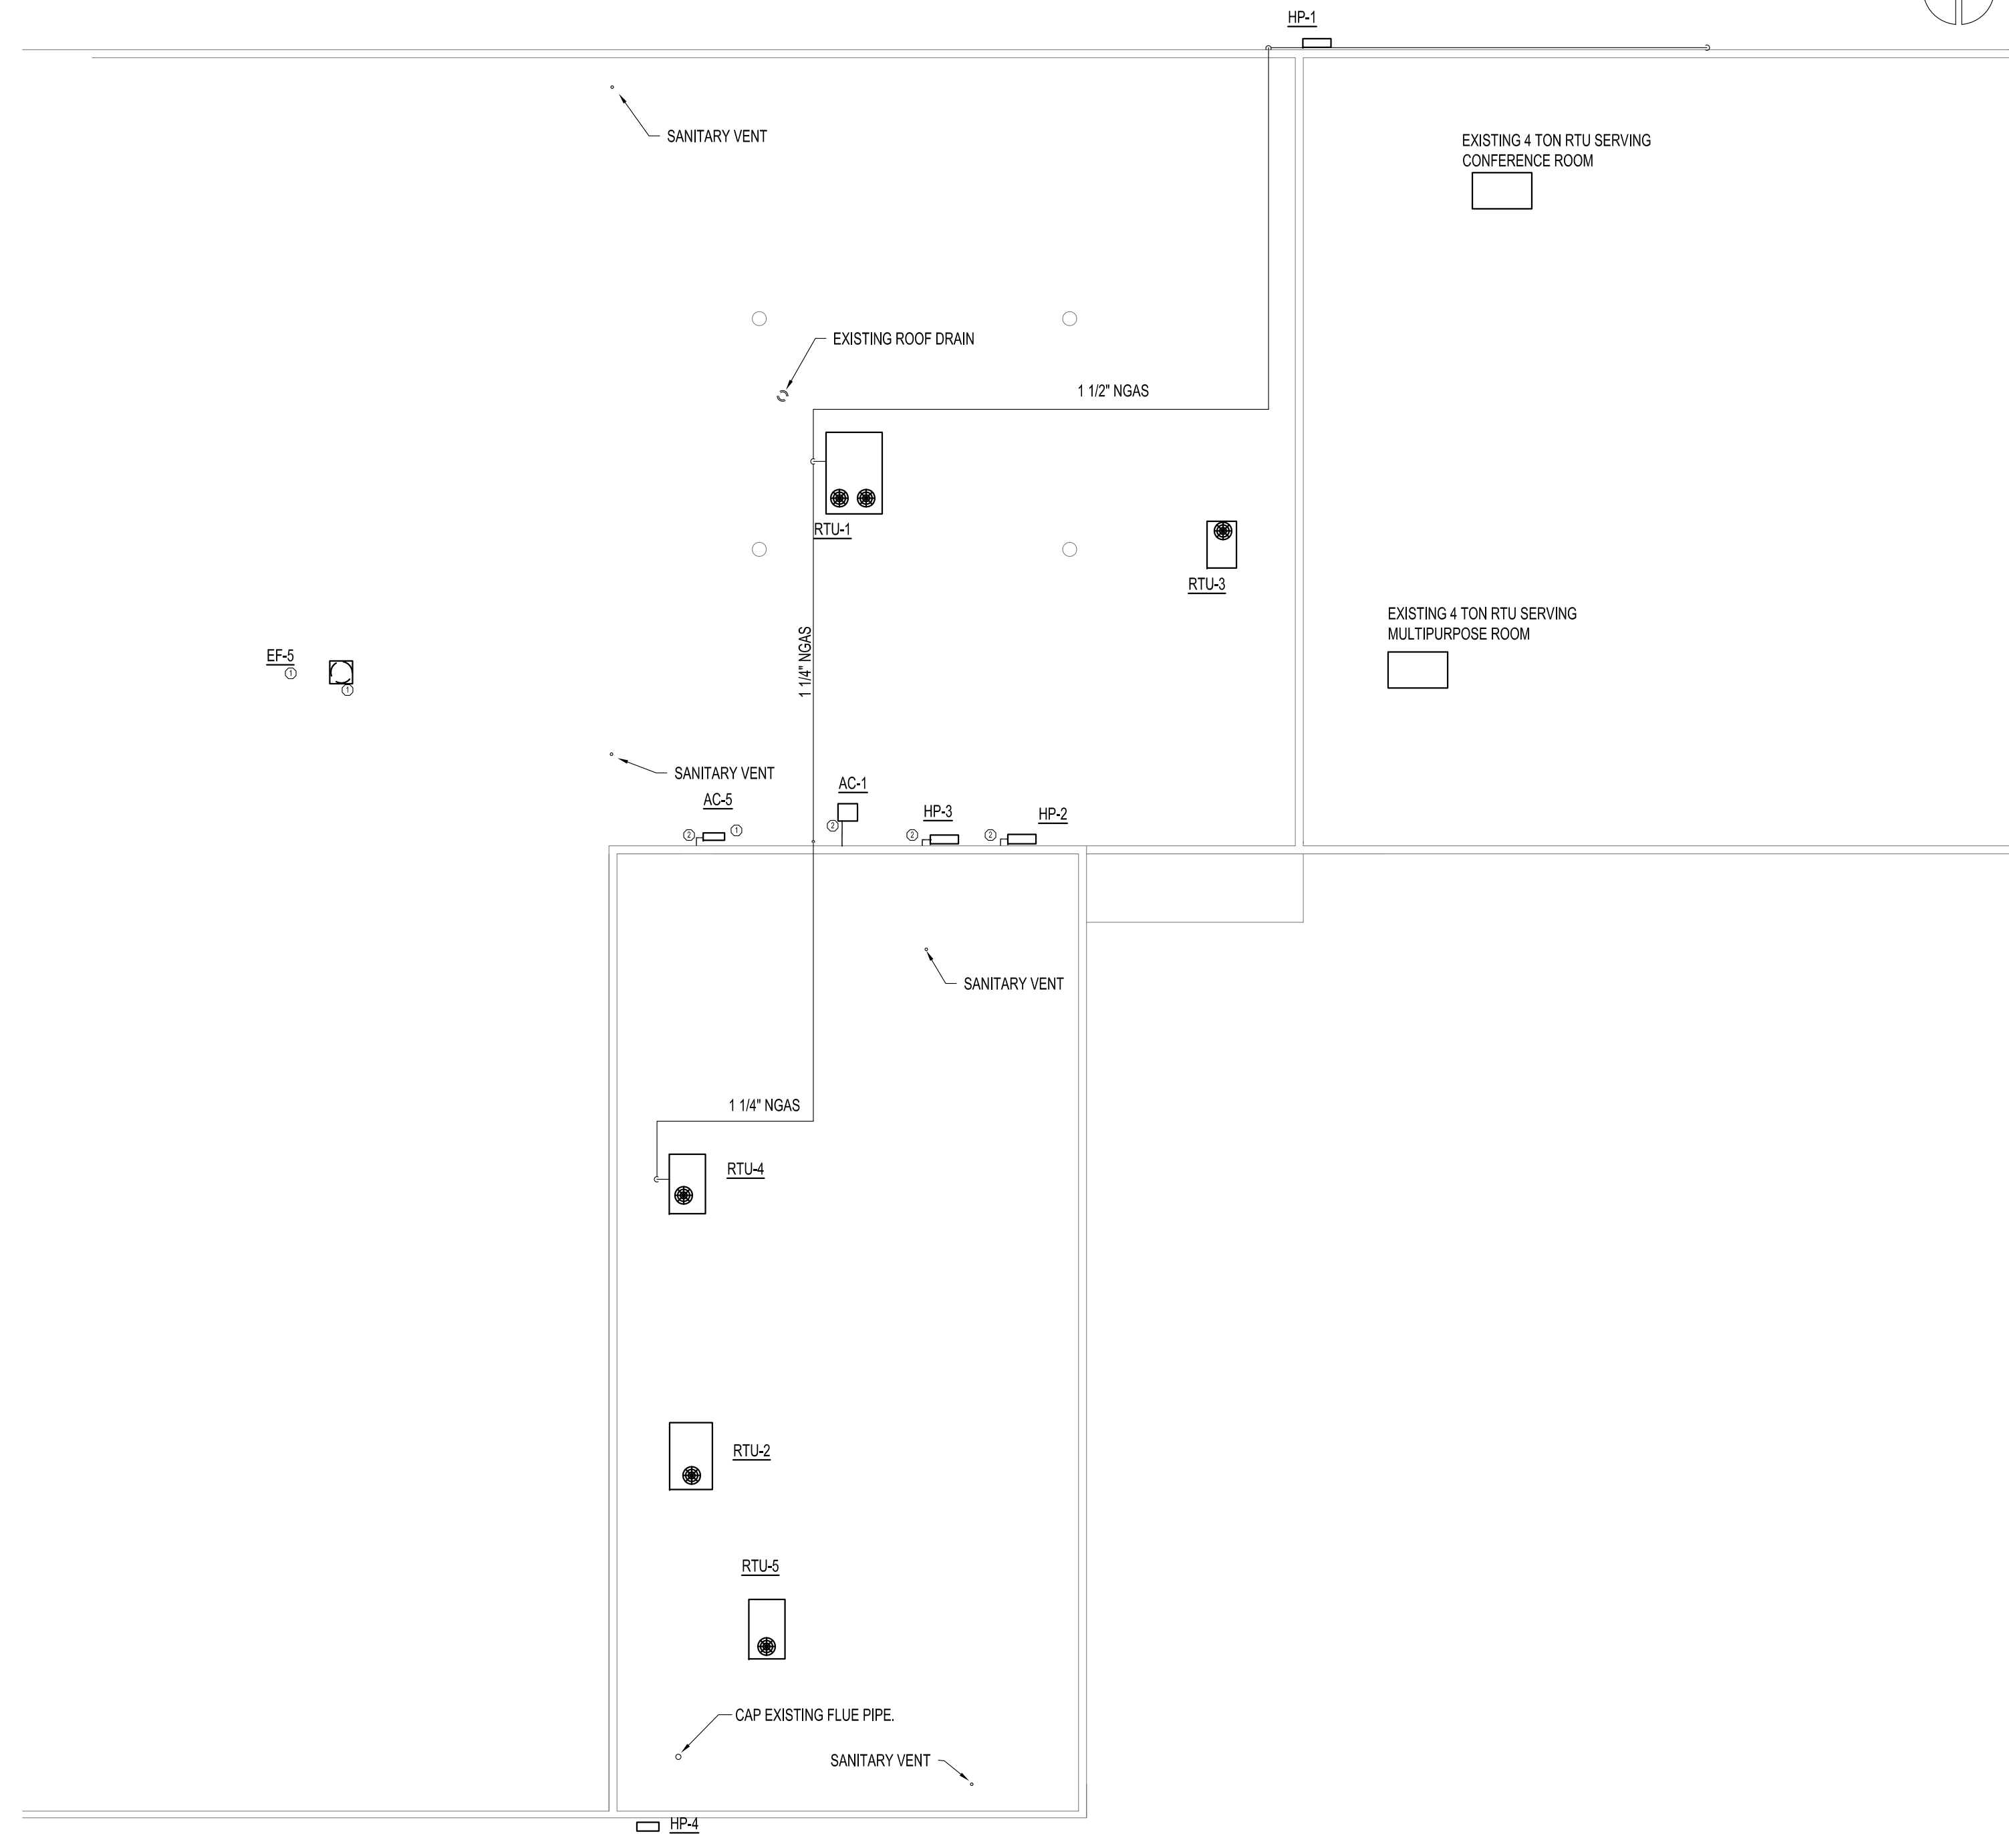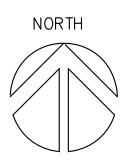

HVAC ROOF PLAN - NEW WORK  
SCALE: 1/16"=1'-0"

- KEYED NOTES:
- ① NOT IN CONTRACT. TO BE INSTALLED BY OTHERS.
  - ② INDICATES REFRIGERANT LIQUID AND VAPOR TUBING. SIZED PER EQUIPMENT MANUFACTURER'S INSTRUCTIONS.