

REVIEW SET



Scale: 1/8" = 1'-0"

1ST FLOOR PLUMBING
PLAN NORTH

P2.1

March 12, 2018

NORTH

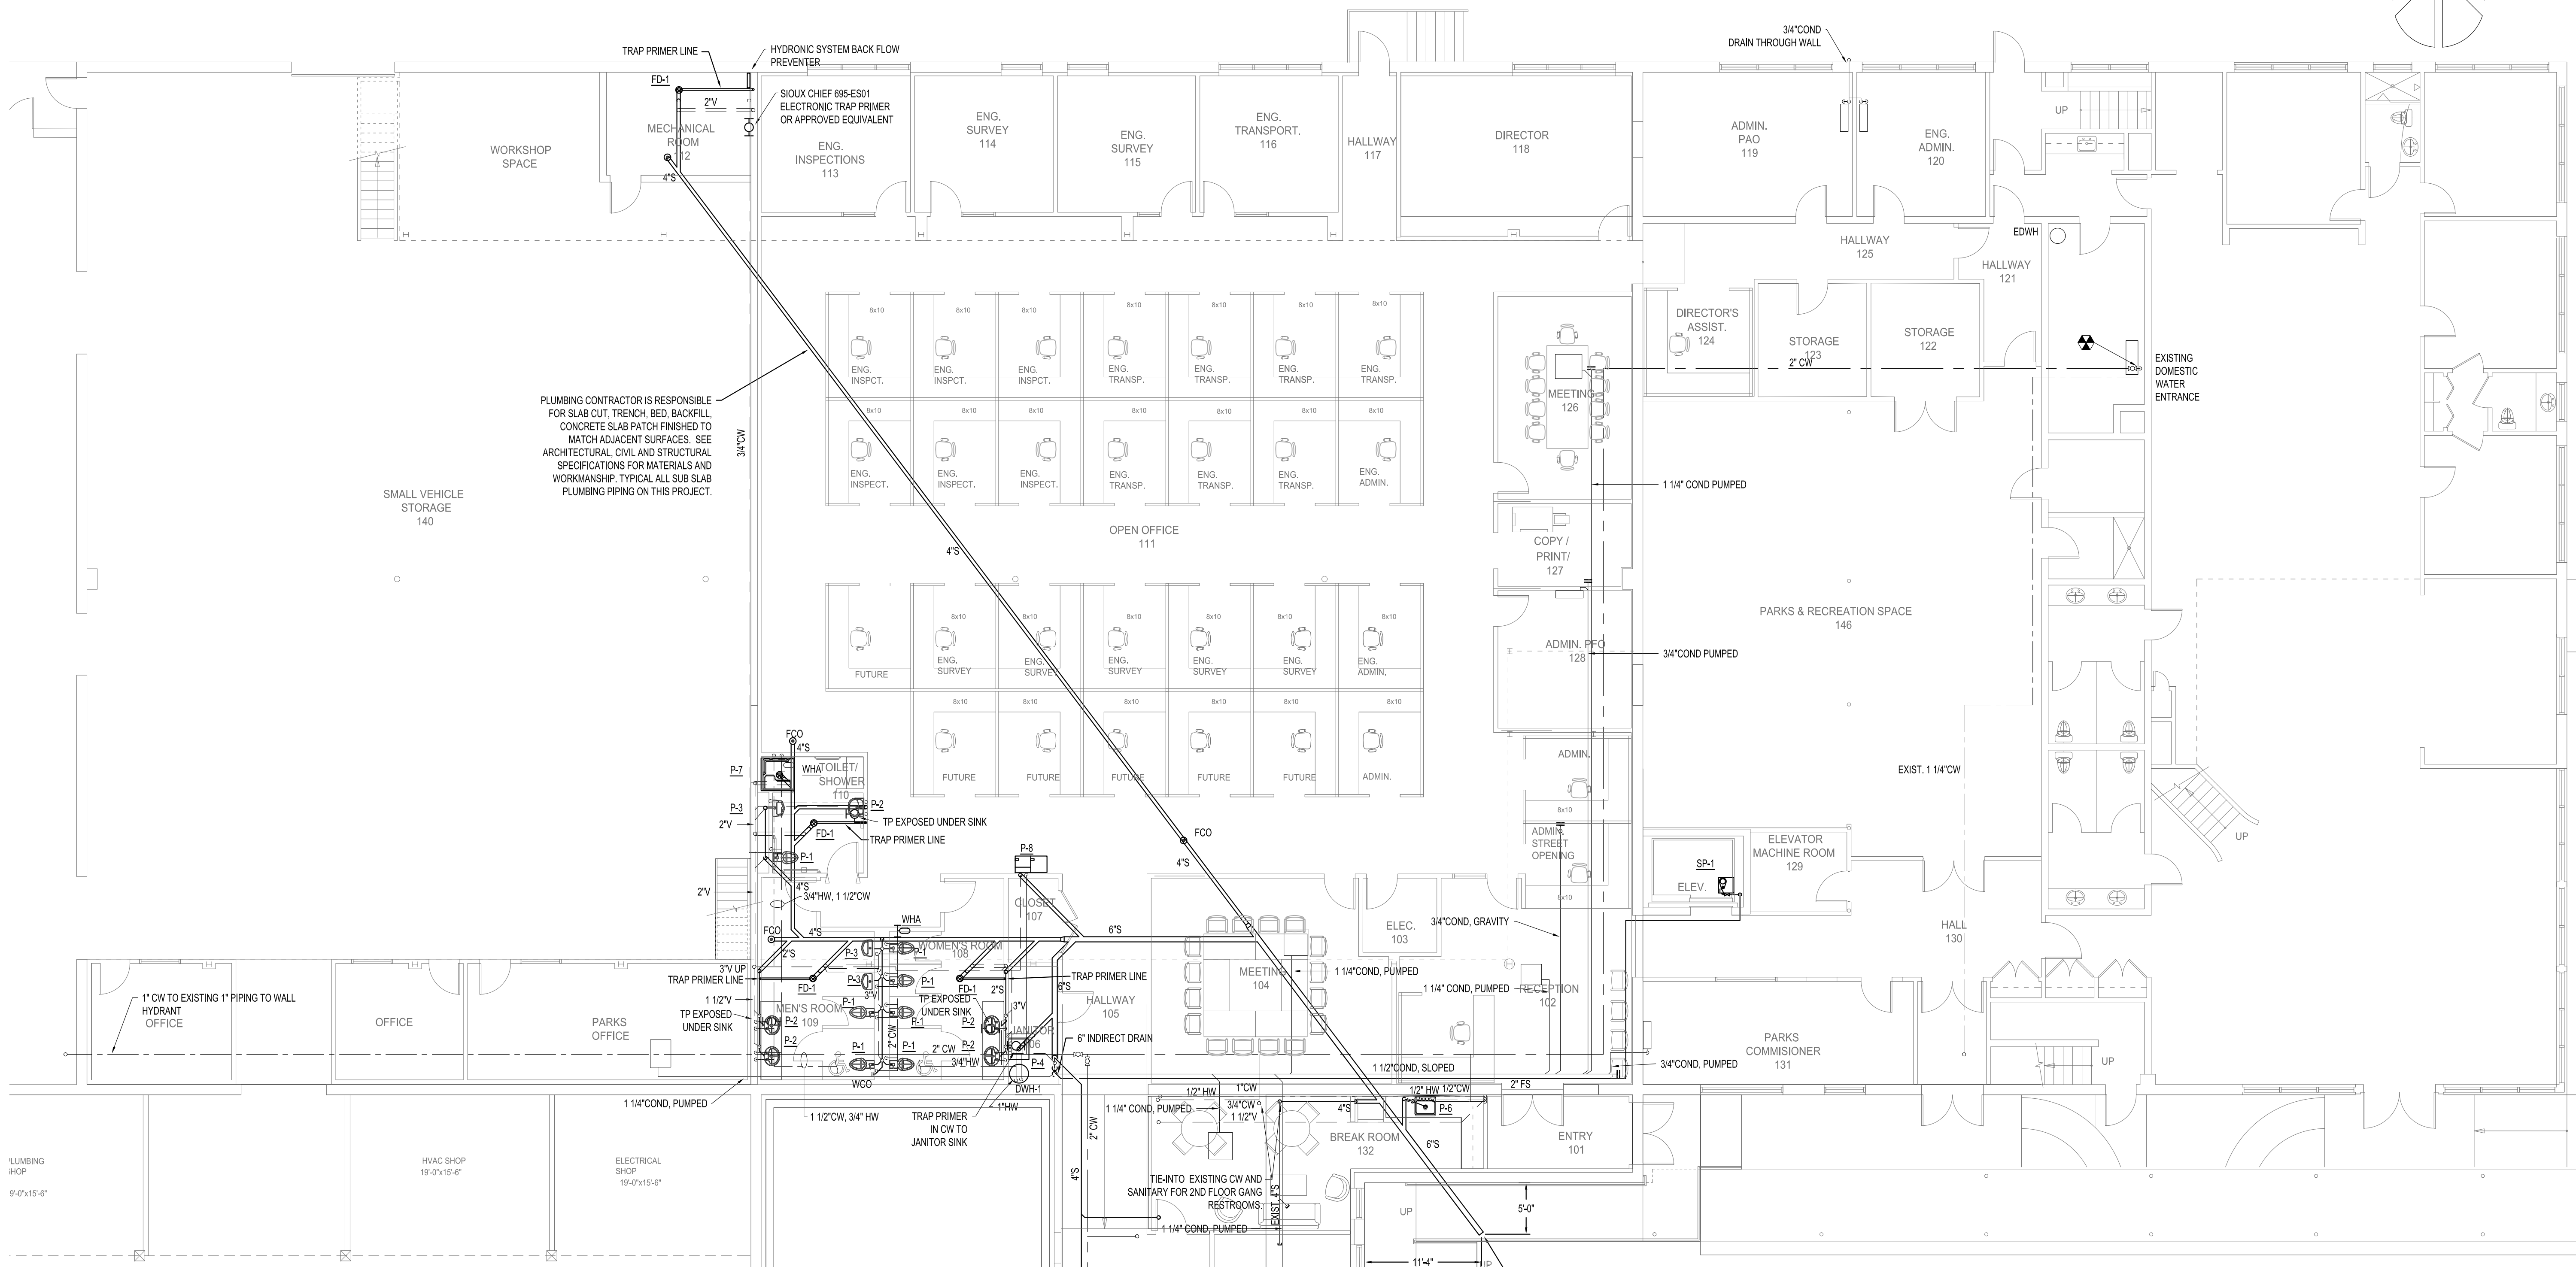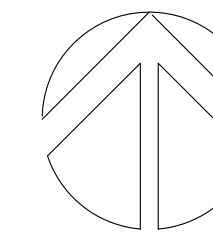

PLUMBING CONTRACTOR IS RESPONSIBLE FOR SLAB CUT, TRENCH, BED, BACKFILL, CONCRETE SLAB PATCH FINISHED TO MATCH ADJACENT SURFACES. SEE ARCHITECTURAL, CIVIL AND STRUCTURAL SPECIFICATIONS FOR MATERIALS AND WORKMANSHIP. TYPICAL ALL SUB SLAB PLUMBING PIPING ON THIS PROJECT.

FIRST FLOOR NORTH - PLUMBING PLAN - NEW WORK
SCALE: 1/8"=1'-0"

STATE FIRE MARSHAL REVIEW
03/12/2018