

5 Milk Street, Portland, ME 04101
207.774.4811 | wintonscott.com

Structural Engineering:
STRUCTURAL INTEGRITY
CONSULTING ENGINEERS, INC.
46 Forest Avenue
Portland, ME 04101
T. 207.774.4614
structuralinteg.com

HVAC & Plumbing Engineering:
HOLBROOK ENGINEERING, LLC
52 Heath Rd
Saco, ME 04072
T. 207.283.9127
holbrookengineering.com


Electrical Engineering:
SWIFT CURRENT
ENGINEERING SERVICES
Royal River Center, Unit 8B
10 Forest Falls Drive
Yarmouth, ME 04096
T. 207.847.9280

CITY OF PORTLAND
DEPARTMENT
HEADQUARTERS:

-Parks, Recreation &
Facilities
-Public Works

RENOVATION PROJECT

212 Conco Road,
Portland

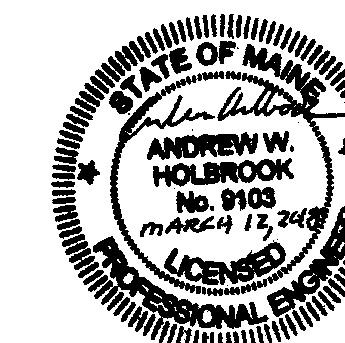


REVIEW SET

Scale: 1/8" = 1'-0"

SECOND FLOOR
PLUMBING PLAN NORTH

P2.3

March 12, 2018

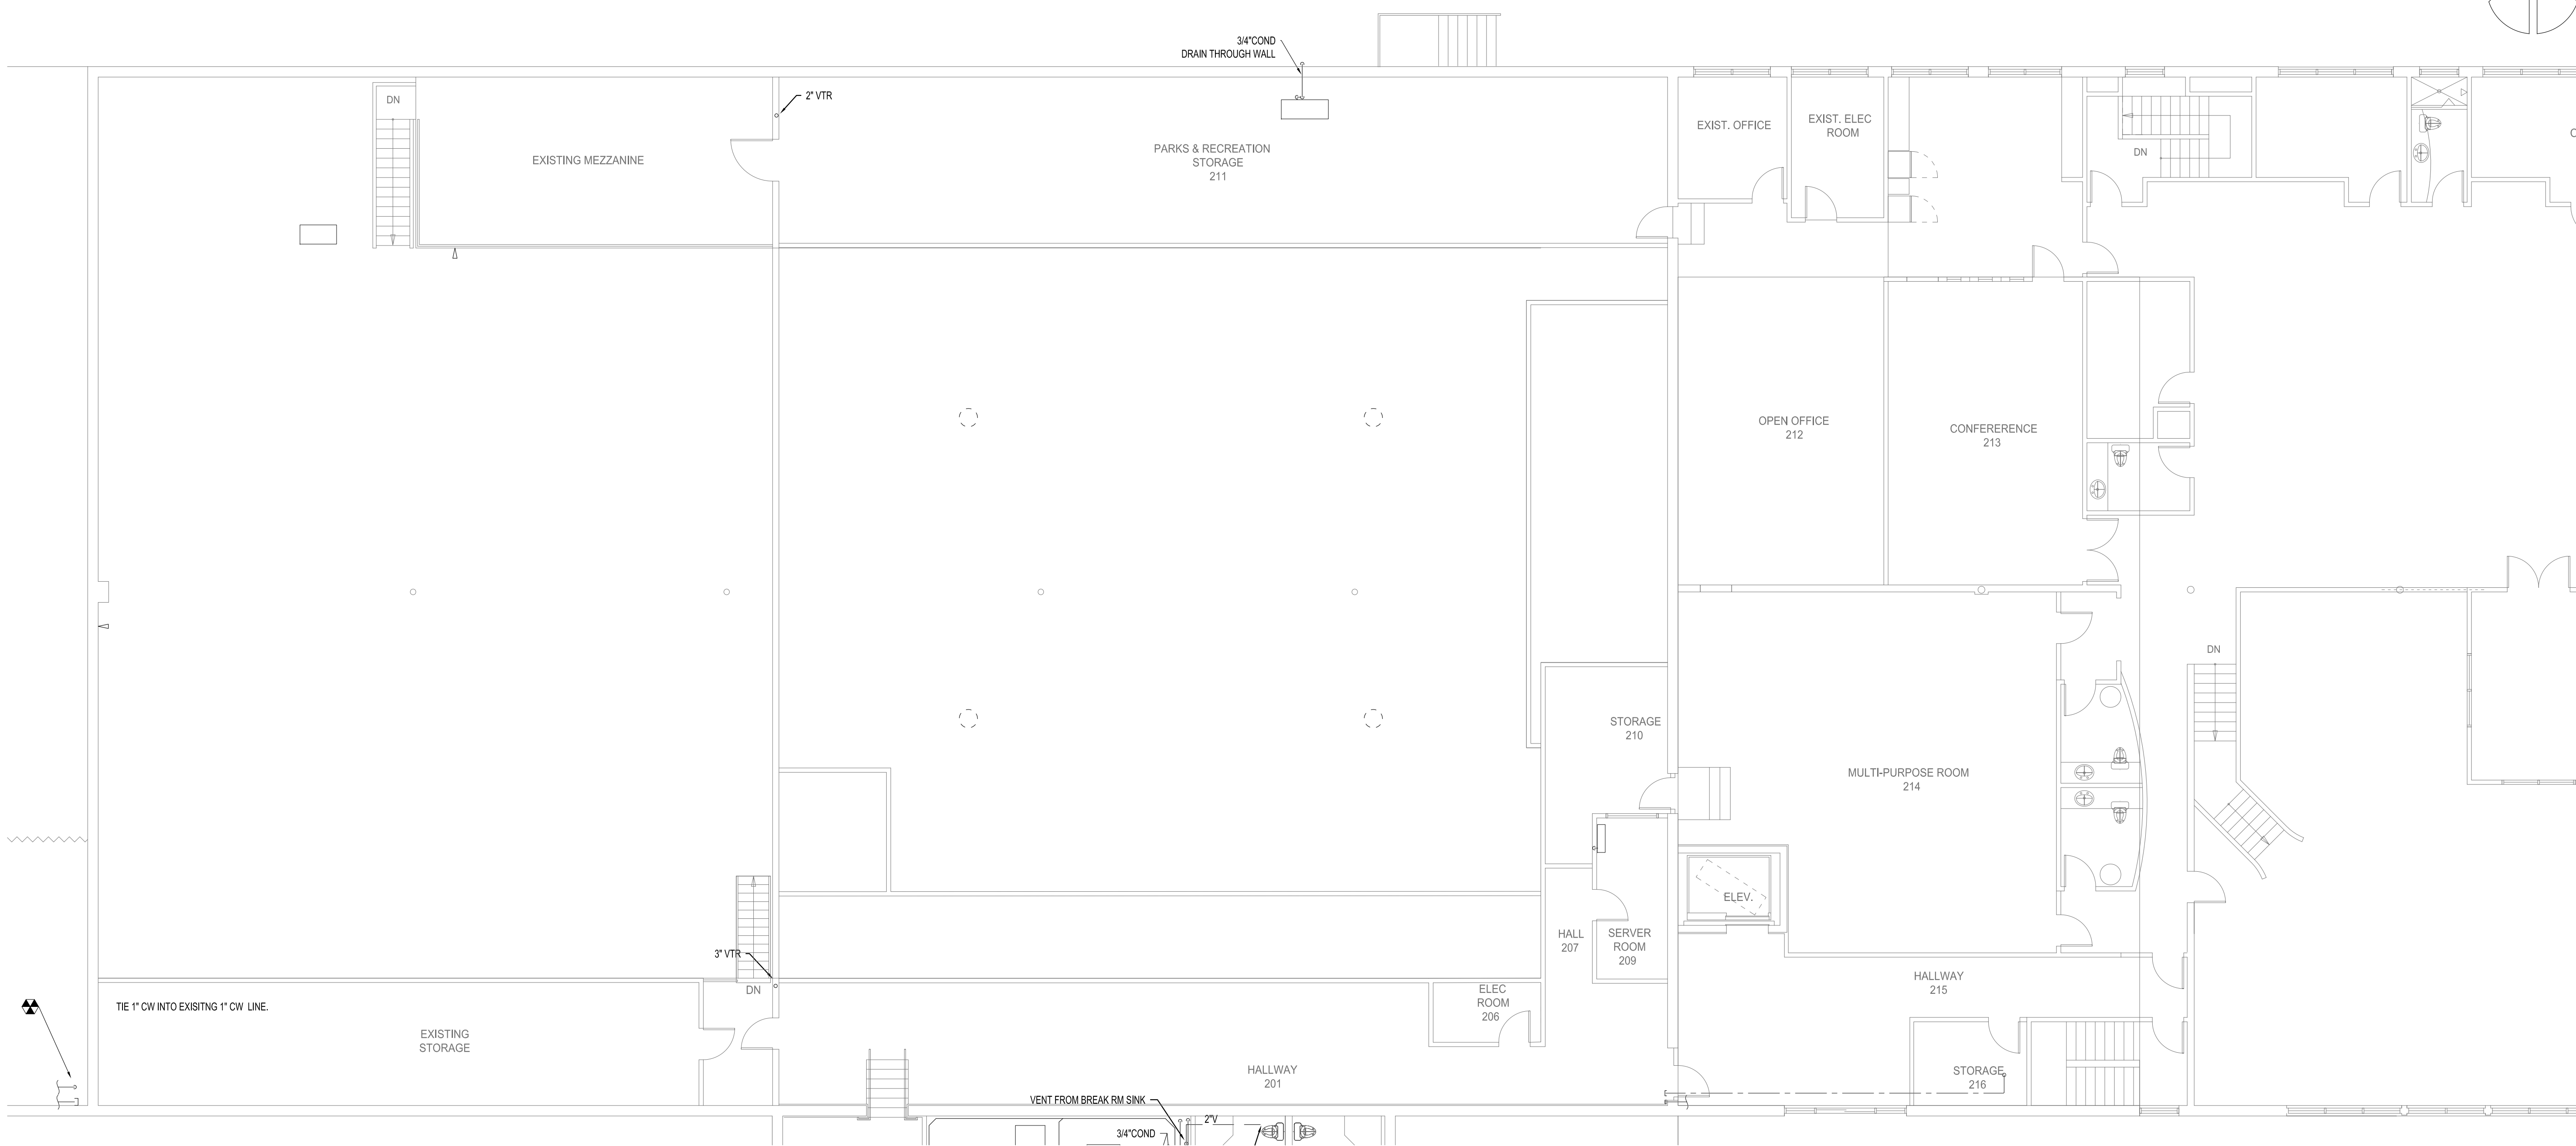

SECOND FLOOR NORTH - PLUMBING PLAN - NEW WORK
SCALE: 1/8"=1'-0"

STATE FIRE MARSHAL REVIEW
03/12/2018