



WINTON SCOTT ARCHITECTS

5 Milk Street, Portland, ME 04101
207.774.4811 | wintonscott.com

Structural Engineering:
STRUCTURAL INTEGRITY CONSULTING ENGINEERS, INC.

46 Forest Avenue
Portland, ME 04101
T. 207.774.4614
structuralinteg.com

HVAC & Plumbing Engineering:
HOLBROOK ENGINEERING, LLC

52 Heath Rd
Saco, ME 04072
T. 207.283.9127
holbrookengineering.com

Electrical Engineering:
SWIFT CURRENT ENGINEERING SERVICES


Royal River Center, Unit 8B
10 Forest Falls Drive
Yarmouth, ME 04096
T. 207.847.9280

CITY OF PORTLAND
DEPARTMENT HEADQUARTERS:

- Parks, Recreation & Facilities
- Public Works

RENOVATION PROJECT

212 Conco Road,
Portland

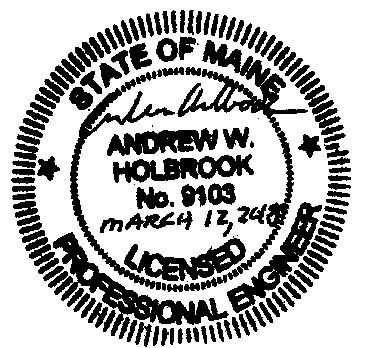


REVIEW SET

Scale: 1/8" = 1'-0"

SECOND FLOOR
PLUMBING PLAN SOUTH

P2.4

March 12, 2018

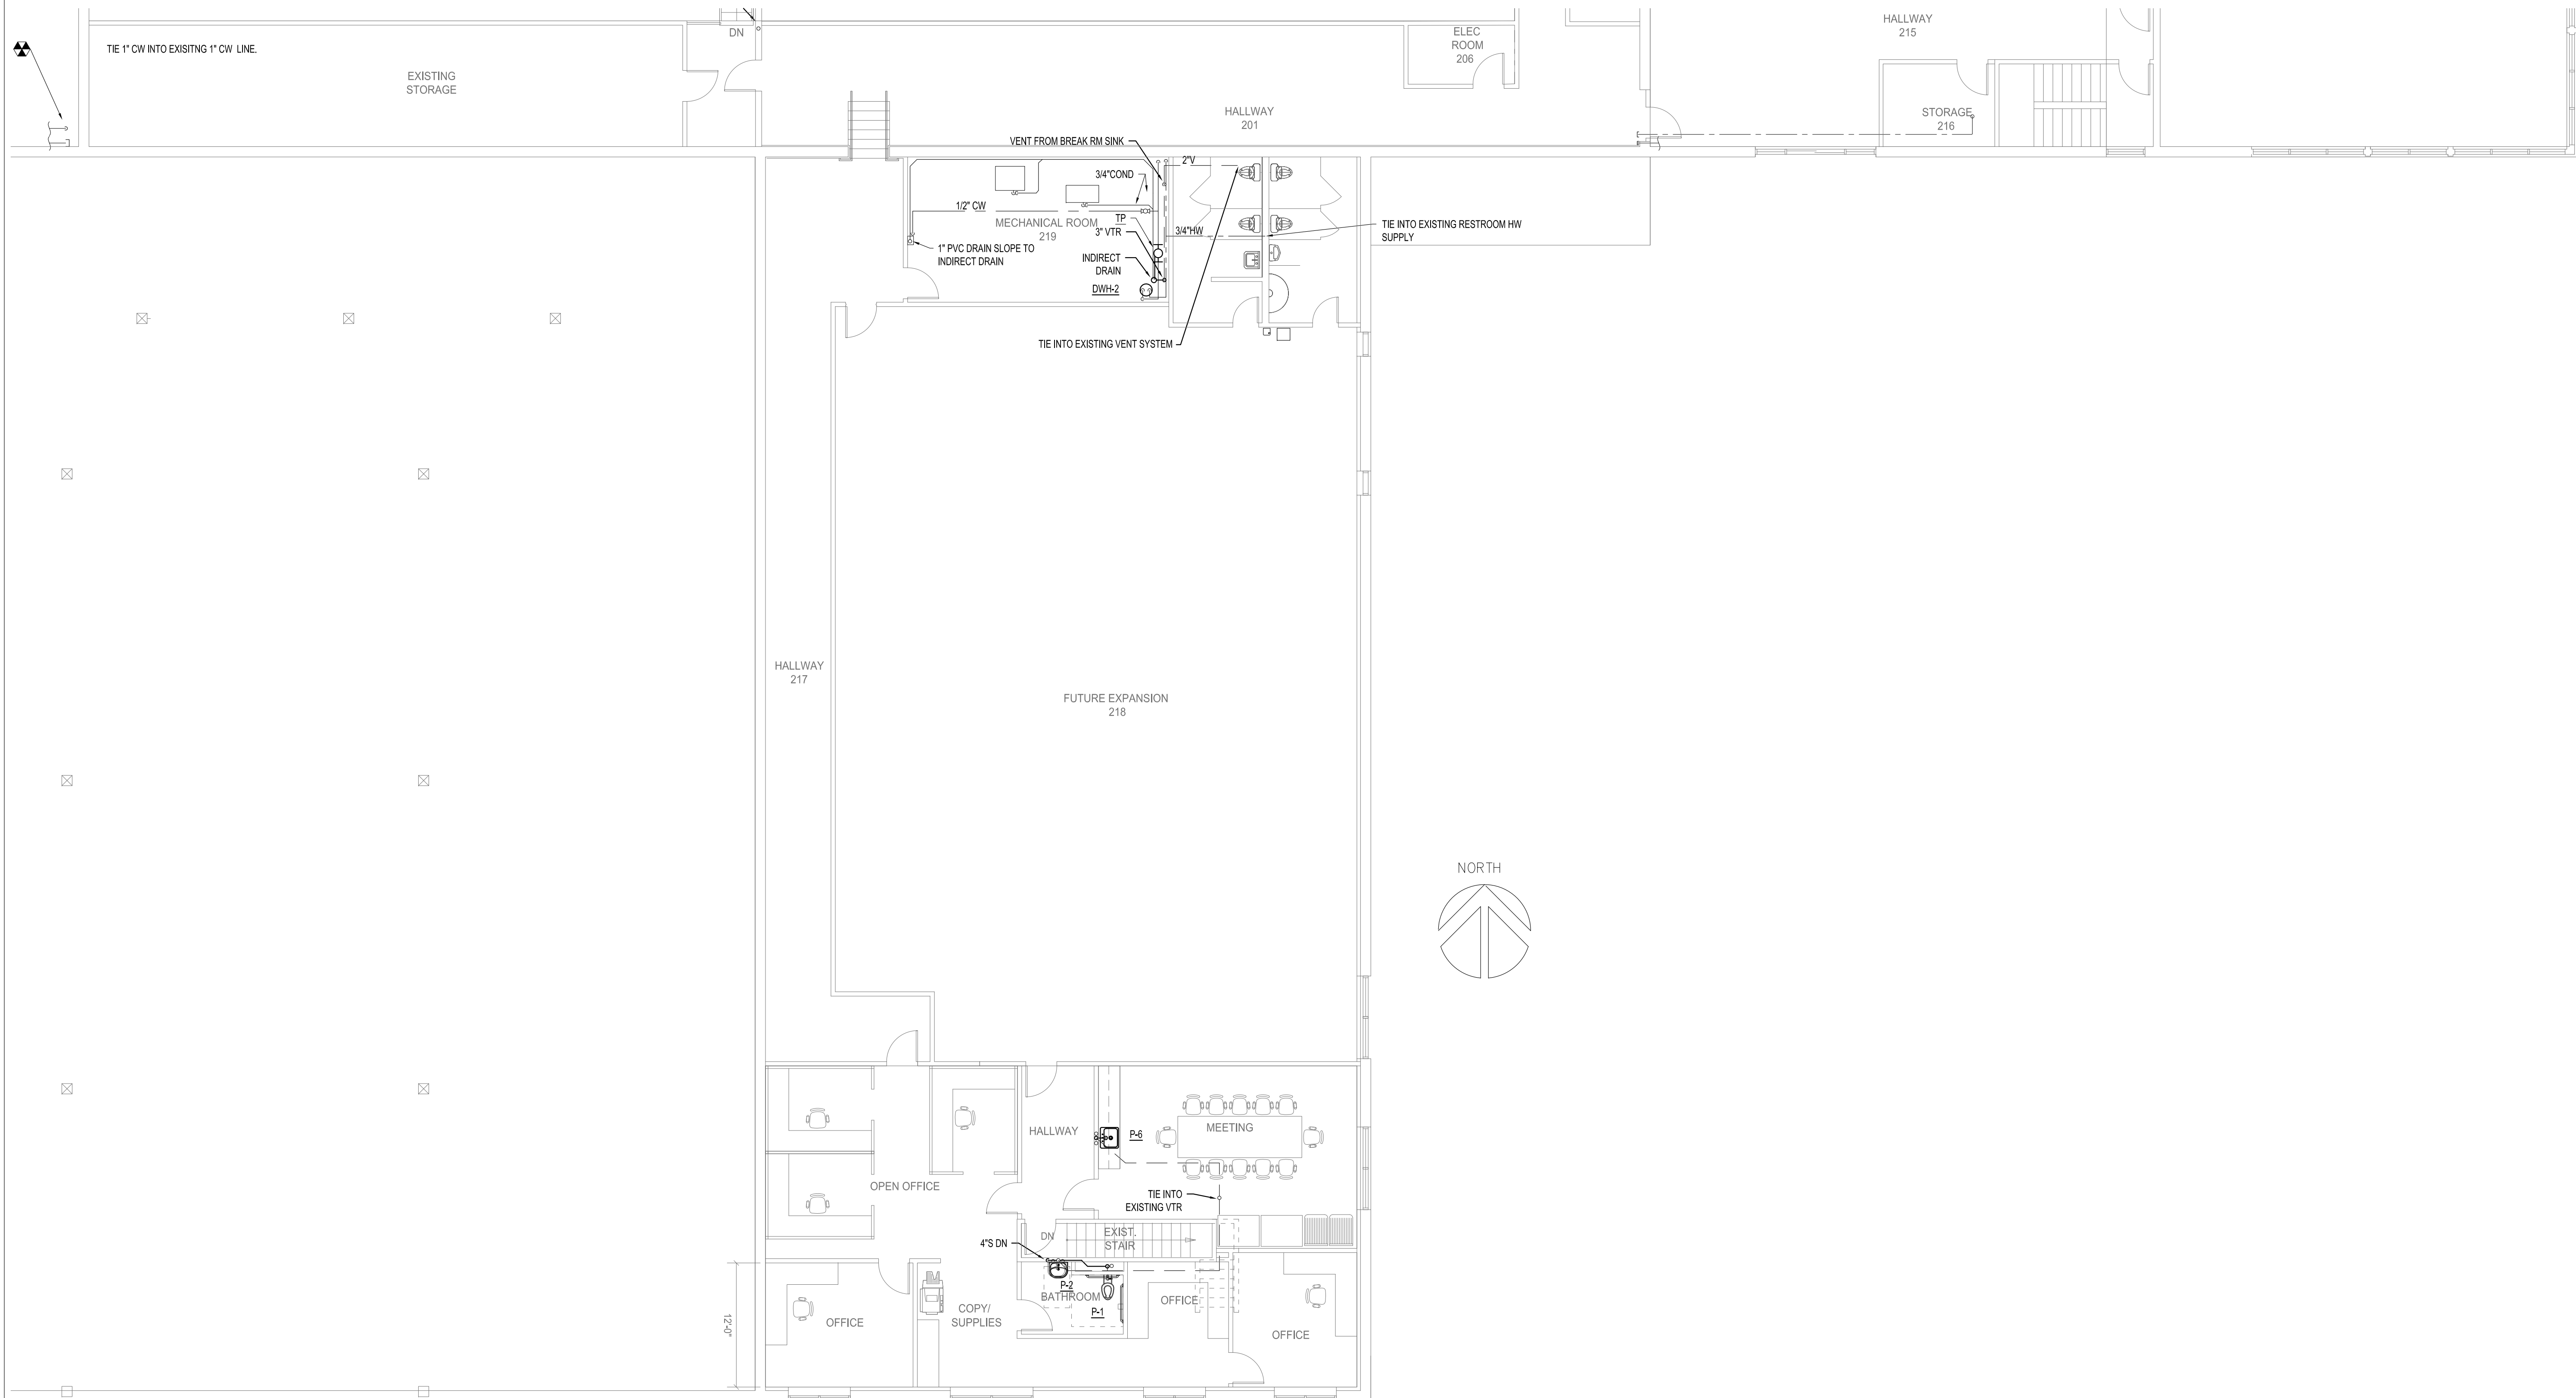

SECOND FLOOR SOUTH - PLUMBING PLAN - NEW WORK
SCALE: 1/8"=1'-0"

STATE FIRE MARSHAL REVIEW
03/12/2018