



5 Milk Street, Portland, ME
04101
207.774.4811 |
wintonscott.com

Structural Engineering:
STRUCTURAL INTEGRITY
CONSULTING ENGINEERS, INC.

46 Forest Avenue
Portland, ME 04101
T. 207.774.4614
structuralintg.com

HVAC & Plumbing
Engineering:
HOLBRICK ENGINEERING, LLC

52 Heath Road
Saco, ME 04072
T. 207.283.9127
aholbrick@maine.rr.com

Electrical Engineering:
SWIFT CURRENT ENGINEERING
SERVICES

Royal River Center, Unit 8B
10 Forest Falls Drive
Yarmouth, ME 04096
T. 207.847.9280

CITY OF PORTLAND
DEPARTMENT
HEADQUARTERS:

-Parks, Recreation &
Facilities
-Public Works

RENOVATION PROJECT
212 Canco Road,
Portland

REVIEW SET
NOT FOR CONSTRUCTION

Scale: AS NOTED

ELECTRICAL LIGHTING &
SYSTEMS PLAN -
(PARTIAL) SECOND FLOOR,
LIGHTING SCHEDULE &
FIRE ALARM RISER
DIAGRAM

E2.3


March 12, 2018

NOTES:

1. SEE E0.0 FOR LEGEND, ABBREVIATIONS AND GENERAL NOTES.

KEYED NOTES:

- ① LIGHTING AND SWITCHING EXISTING TO REMAIN.
- ② MOUNT REMOTE TEST INDICATOR AT FIRE ALARM CONTROL PANEL.
- ③ CITY OF PORTLAND IS REQUIRING INSTALLATION OF NEW RADIO-BASED TELEMETRY EQUIPMENT WHEN ALTERATIONS/UPGRADES ARE MADE TO FIRE ALARM PANELS. COORDINATE EQUIPMENT WITH PORTLAND FIRE DEPT. TO BE FURNISHED AND INSTALLED BY CONTRACTOR.
- ④ ELEVATOR AND ELEVATOR MACHINE ROOM ARE ADD ALTERNATE.

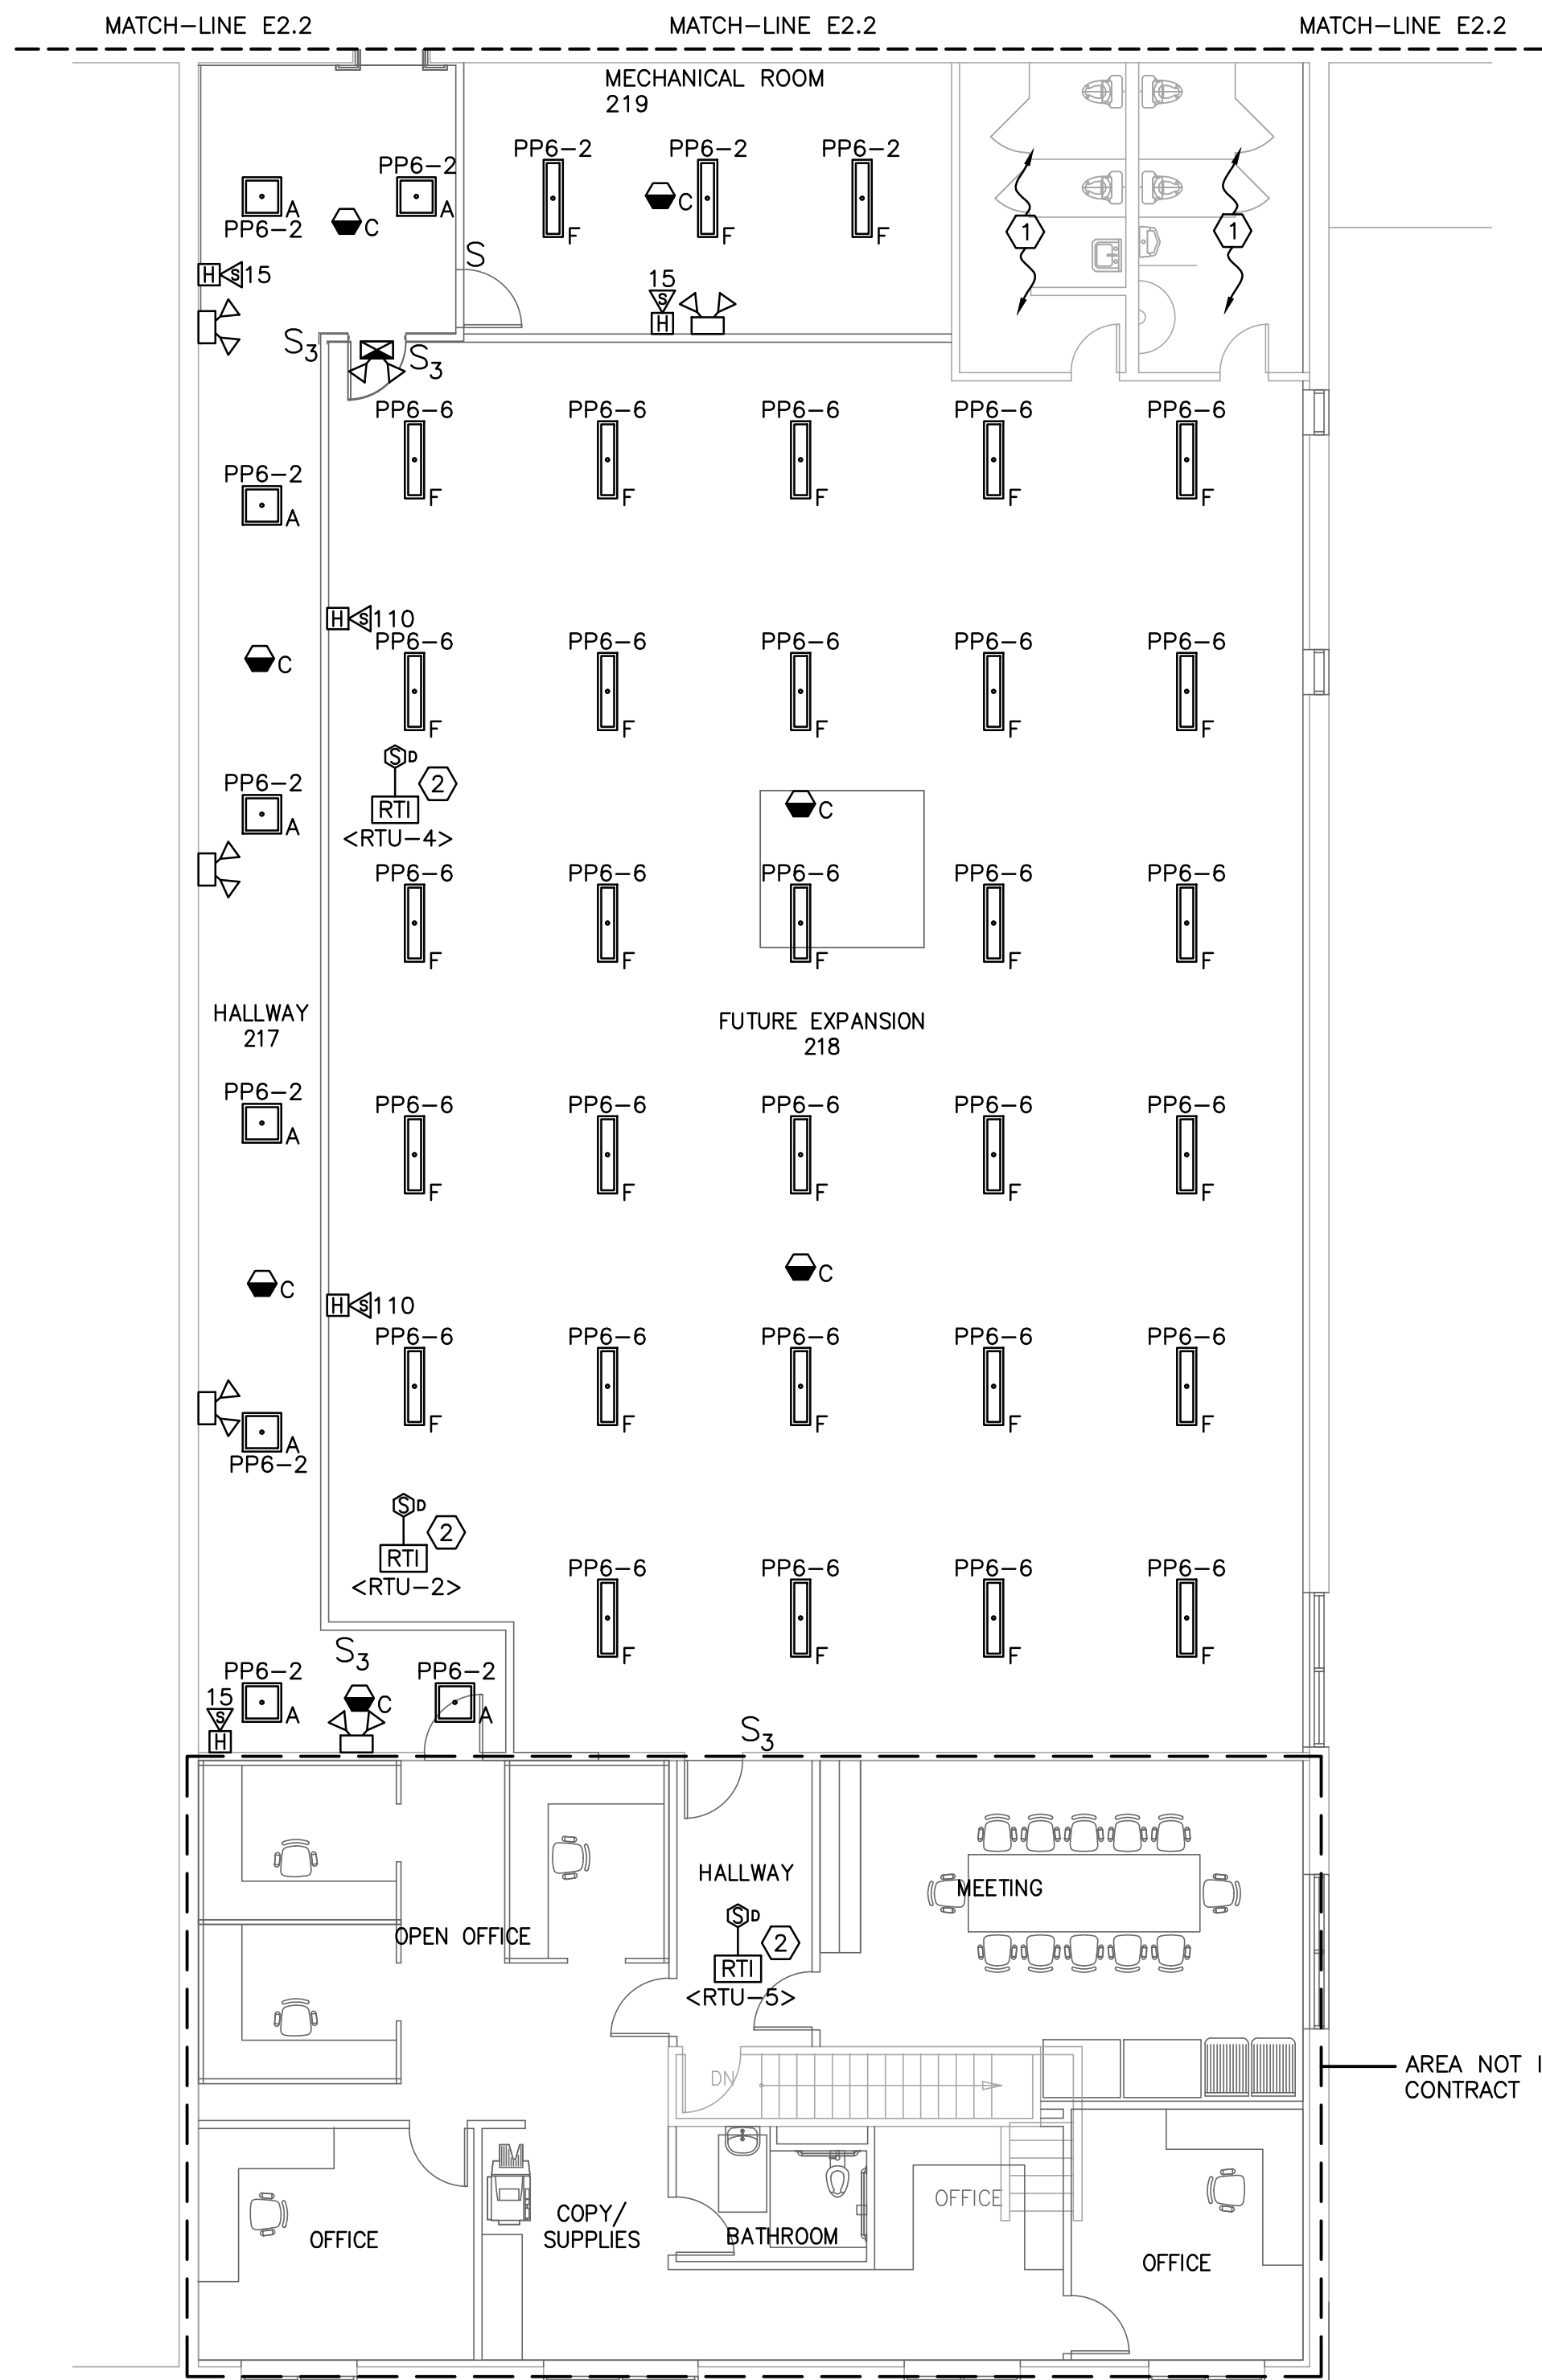


1 ELECTRICAL LIGHTING & SYSTEMS PLAN - (PARTIAL)
SECOND FLOOR

SCALE: 1/8"=1'

Room #	Room Name	FIXTURE "ON" BY	FIXTURE "OFF" BY
1st FLOOR			
101	ENTRY	CEILING SENSOR	CEILING SENSOR
102	ADMIN. RECEPT.	SWITCH	SWITCH/CEILING SENSOR
103	ELECTRICAL	WALL SENSOR	WALL SENSOR
104	MEETING	DIMMER SWITCH	SWITCH/CEILING SENSOR
105	HALLWAY	SWITCH	SWITCH/CEILING SENSOR
106	JANITOR CLOSET	WALL SENSOR	WALL SENSOR
107	CLOSET	WALL SENSOR	WALL SENSOR
108	WOMEN'S ROOM	SWITCH	SWITCH/CEILING SENSOR
109	MEN'S ROOM	SWITCH	SWITCH/CEILING SENSOR
110	TOILET/SHOWER	WALL SENSOR	WALL SENSOR
111	OPEN OFFICE	SWITCH	FIXTURE MOUNTED SENSOR
112	MECHANICAL ROOM	WALL SENSOR	WALL SENSOR
113	ENG. INSPECTIONS	WALL DIMMER	WALL DIMMER/SENSOR
114	ENG. SURVEY	WALL DIMMER	WALL DIMMER/SENSOR
115	ENG. SURVEY	WALL DIMMER	WALL DIMMER/SENSOR
116	ENG. TRANSPORT	WALL DIMMER	WALL DIMMER/SENSOR
117	HALLWAY	SWITCH	SWITCH/CEILING SENSOR
118	DIRECTOR	DIMMER SWITCH	SWITCH/CEILING SENSOR
119	ADMIN. PAO	DIMMER SWITCH	SWITCH/CEILING SENSOR
120	ENG ADMIN	WALL DIMMER	WALL DIMMER/SENSOR
121	HALLWAY	SWITCH	SWITCH/CEILING SENSOR
122	STORAGE	WALL SENSOR	WALL SENSOR
123	STORAGE	WALL SENSOR	WALL SENSOR
124	DIRECTOR'S ASST.	SWITCH	SWITCH/CEILING SENSOR
125	HALLWAY	SWITCH	SWITCH/CEILING SENSOR
126	MEETING	DIMMER SWITCH	SWITCH/CEILING SENSOR
127	COPY/PRINT/COFFEE	WALL SENSOR	WALL SENSOR
128	ADMIN PAO	WALL DIMMER	WALL DIMMER/SENSOR
129	ELEV. MACHINE ROOM	WALL SENSOR	WALL SENSOR
130	HALLWAY	CEILING SENSOR	CEILING SENSOR
131	PARKS COMMISSIONER	DIMMER SWITCH	SWITCH/CEILING SENSOR
132	BREAK ROOM	DIMMER SWITCH	SWITCH/CEILING SENSOR
133	WR ADMIN	WALL DIMMER	WALL DIMMER/SENSOR
134	WR ENG	WALL DIMMER	WALL DIMMER/SENSOR
135	WR ASSET MGMT	WALL DIMMER	WALL DIMMER/SENSOR
136	WR COMPL. STORM WATER	WALL DIMMER	WALL DIMMER/SENSOR
137	OPEN OFFICE	SWITCH	SWITCH/CEILING SENSOR
138	STAIR 1	CEILING SENSOR	CEILING SENSOR
138A	STORAGE	WALL SENSOR	WALL SENSOR
139	ENG. ARCHIVES	SWITCH	SWITCH/CEILING SENSOR
140	SMALL VEHICLE STORAGE	SWITCH	FIXTURE MOUNTED SENSOR
140	MEETING	DIMMER SWITCH	SWITCH/CEILING SENSOR
141	OFFICE SUPPLIES	WALL SENSOR	WALL SENSOR
142	COPY/PLOT	WALL SENSOR	WALL SENSOR
143	OPEN OFFICE	SWITCH	SWITCH/CEILING SENSOR
145	ENGINEERING VAULT	SWITCH	SWITCH/CEILING SENSOR
146	PARKS & RECREATION SPACE	DIMMER SWITCH	SWITCH/CEILING SENSOR
	WORKSHOP SPACE	SWITCH	SWITCH/CEILING SENSOR
	ADMIN.	CEILING SENSOR	CEILING SENSOR
	ADMIN. STREET OPENING	CEILING SENSOR	CEILING SENSOR
	FUTURE ELEV.	WALL SWITCH	WALL SWITCH
2nd FLOOR			
201	HALLWAY	SWITCH	SWITCH/CEILING SENSOR
202	STORAGE	WALL SENSOR	WALL SENSOR
203	STORAGE	WALL SENSOR	WALL SENSOR
204	STORAGE	WALL SENSOR	WALL SENSOR
205	STORAGE	WALL SENSOR	WALL SENSOR
206	ELEC ROOM	WALL SENSOR	WALL SENSOR
207	HALL	CEILING SENSOR	CEILING SENSOR
208	STORAGE	WALL SENSOR	WALL SENSOR
209	SERVER ROOM	WALL SENSOR	WALL SENSOR
210	STORAGE	WALL SENSOR	WALL SENSOR
212	OPEN OFFICE	SWITCH	SWITCH/CEILING SENSOR
213	CONFERENCE	DIMMER SWITCH	SWITCH/CEILING SENSOR
214	MULTI-PURPOSE ROOM	SWITCH	SWITCH/CEILING SENSOR
215	HALLWAY	SWITCH	SWITCH/CEILING SENSOR
216	STORAGE	WALL SENSOR	WALL SENSOR
217	HALLWAY	SWITCH	SWITCH/CEILING SENSOR
218	FUTURE EXPANSION	SWITCH	SWITCH/CEILING SENSOR
219	MECHANICAL ROOM	SWITCH	SWITCH/CEILING SENSOR

2 LIGHTING CONTROL SCHEDULE

SCALE: NOT TO SCALE

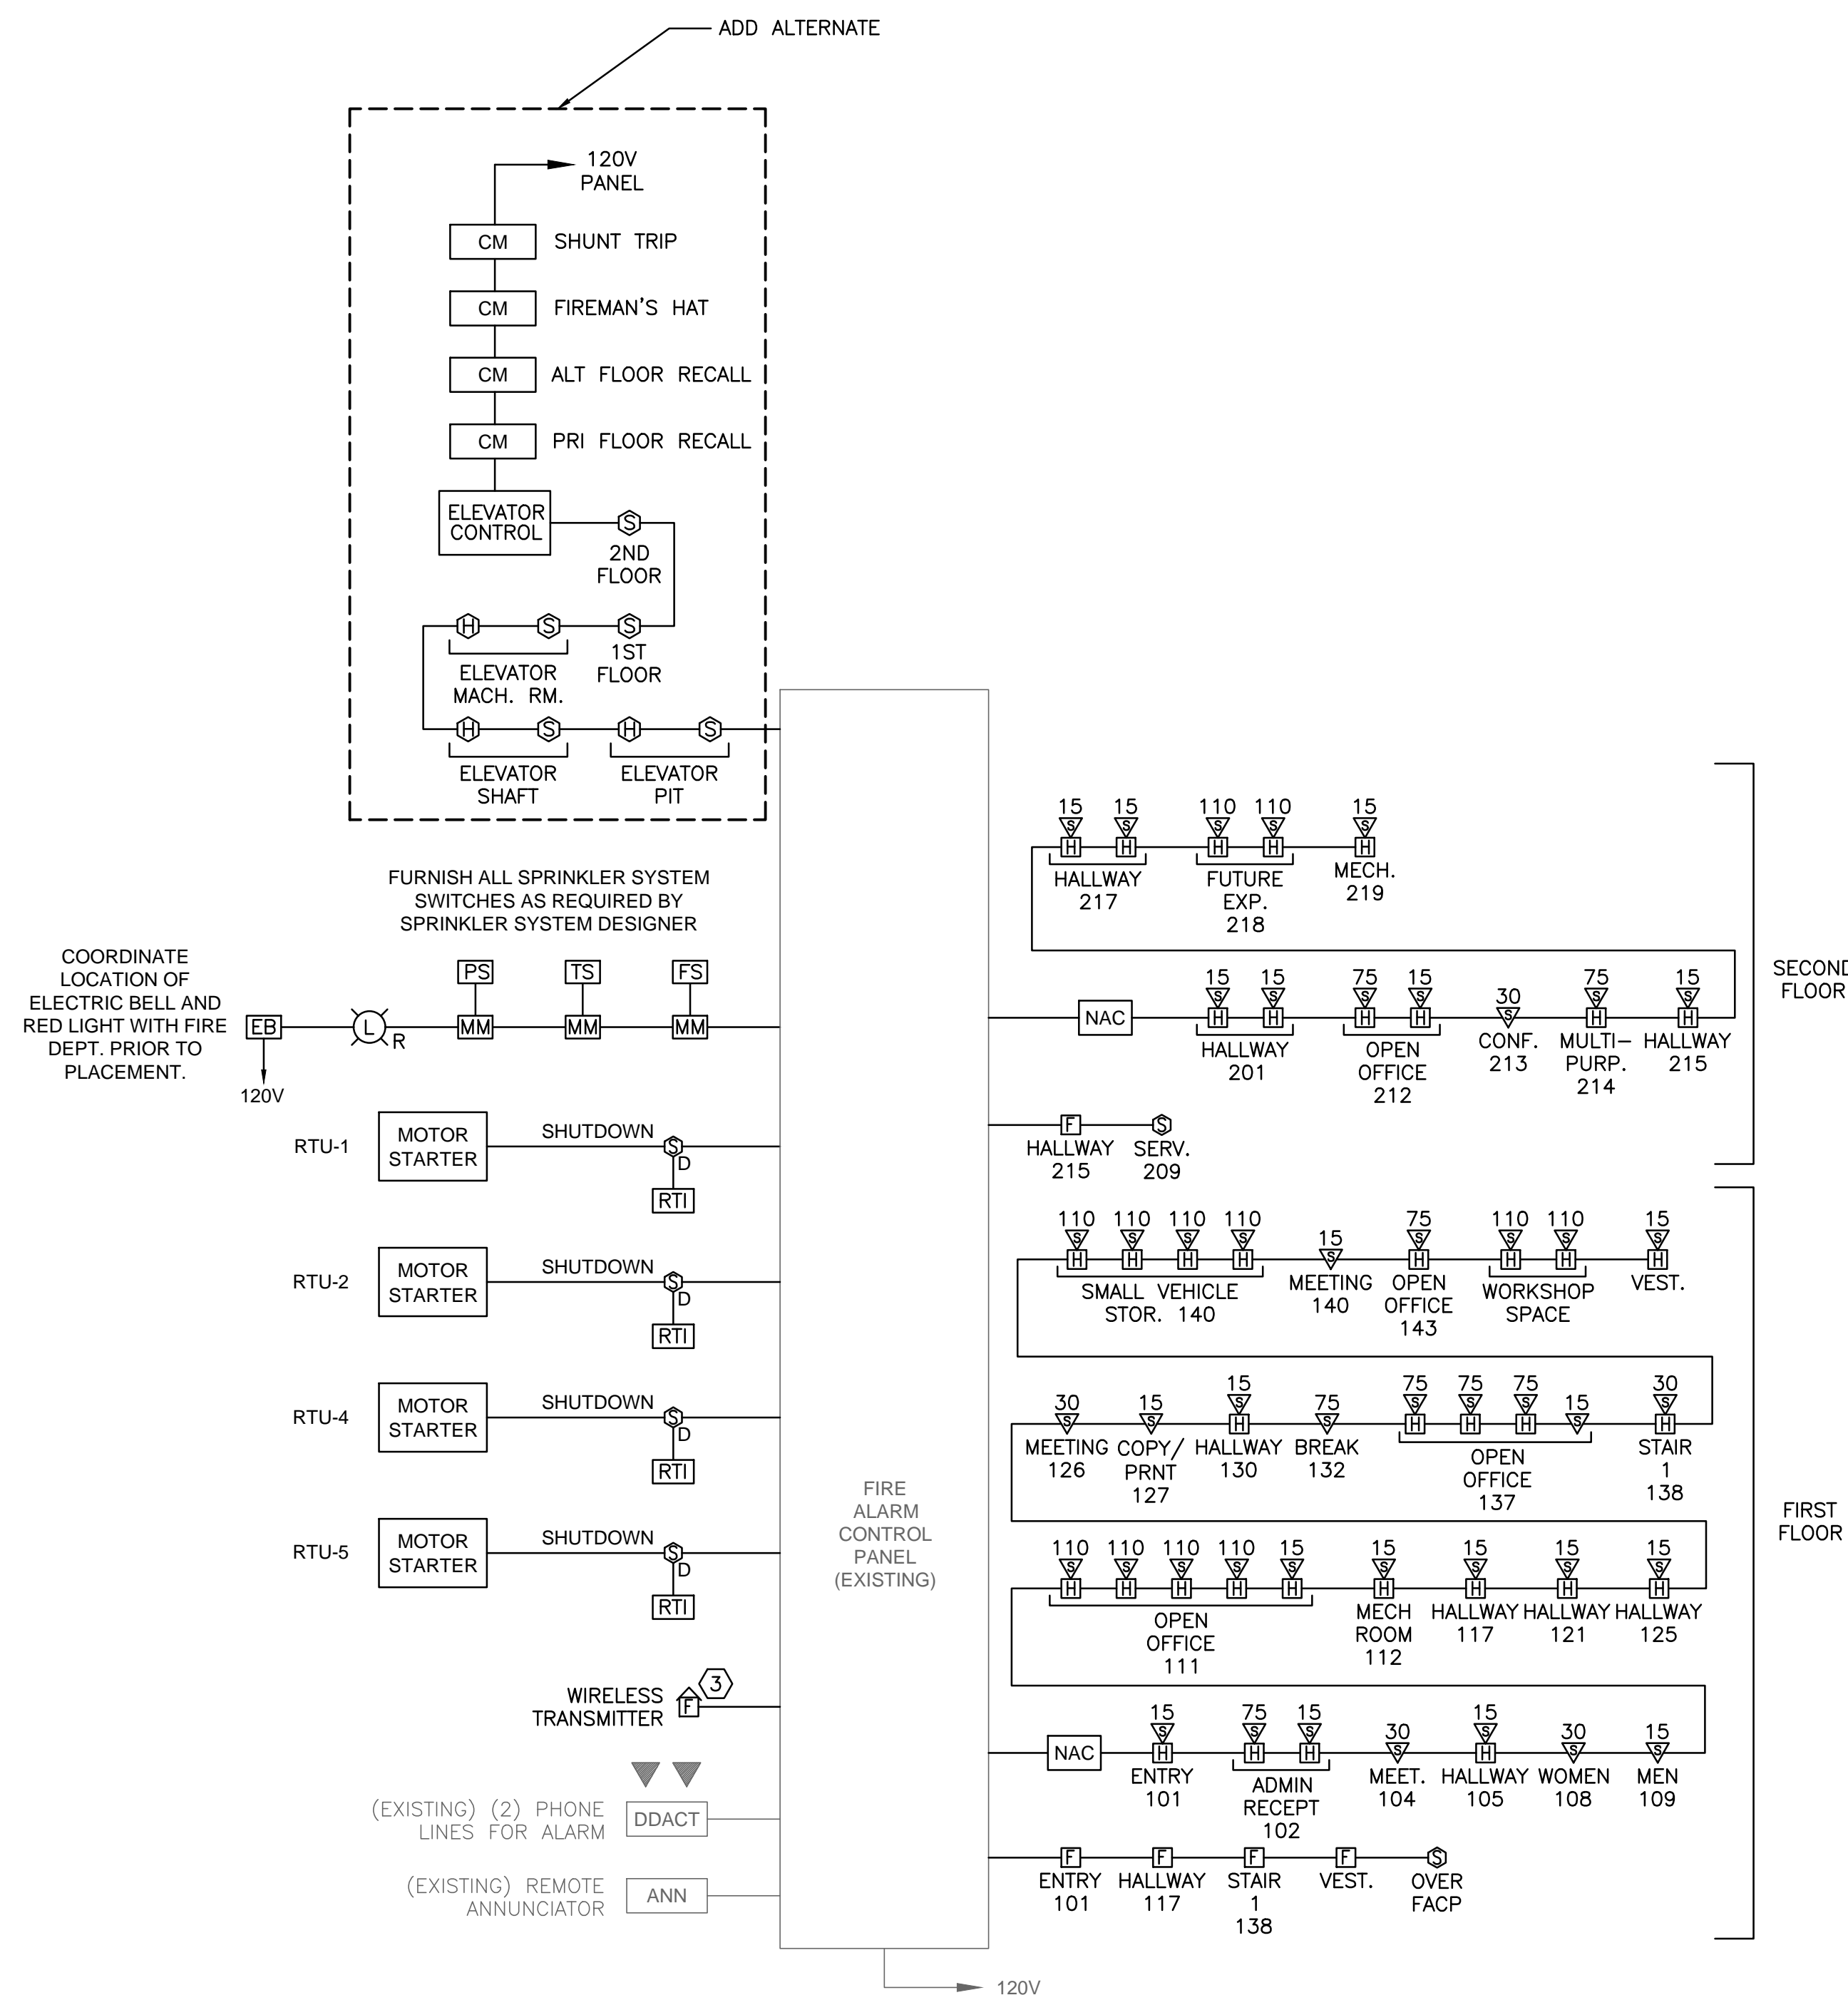

3 FIRE ALARM RISER DIAGRAM

SCALE: NOT TO SCALE

KEY PLAN - SECOND FLOOR

