




Mark	Date	Description
05-28-04		ISSUED FOR BID
05-17-04		OWNER REVIEW

Drawing Status

--

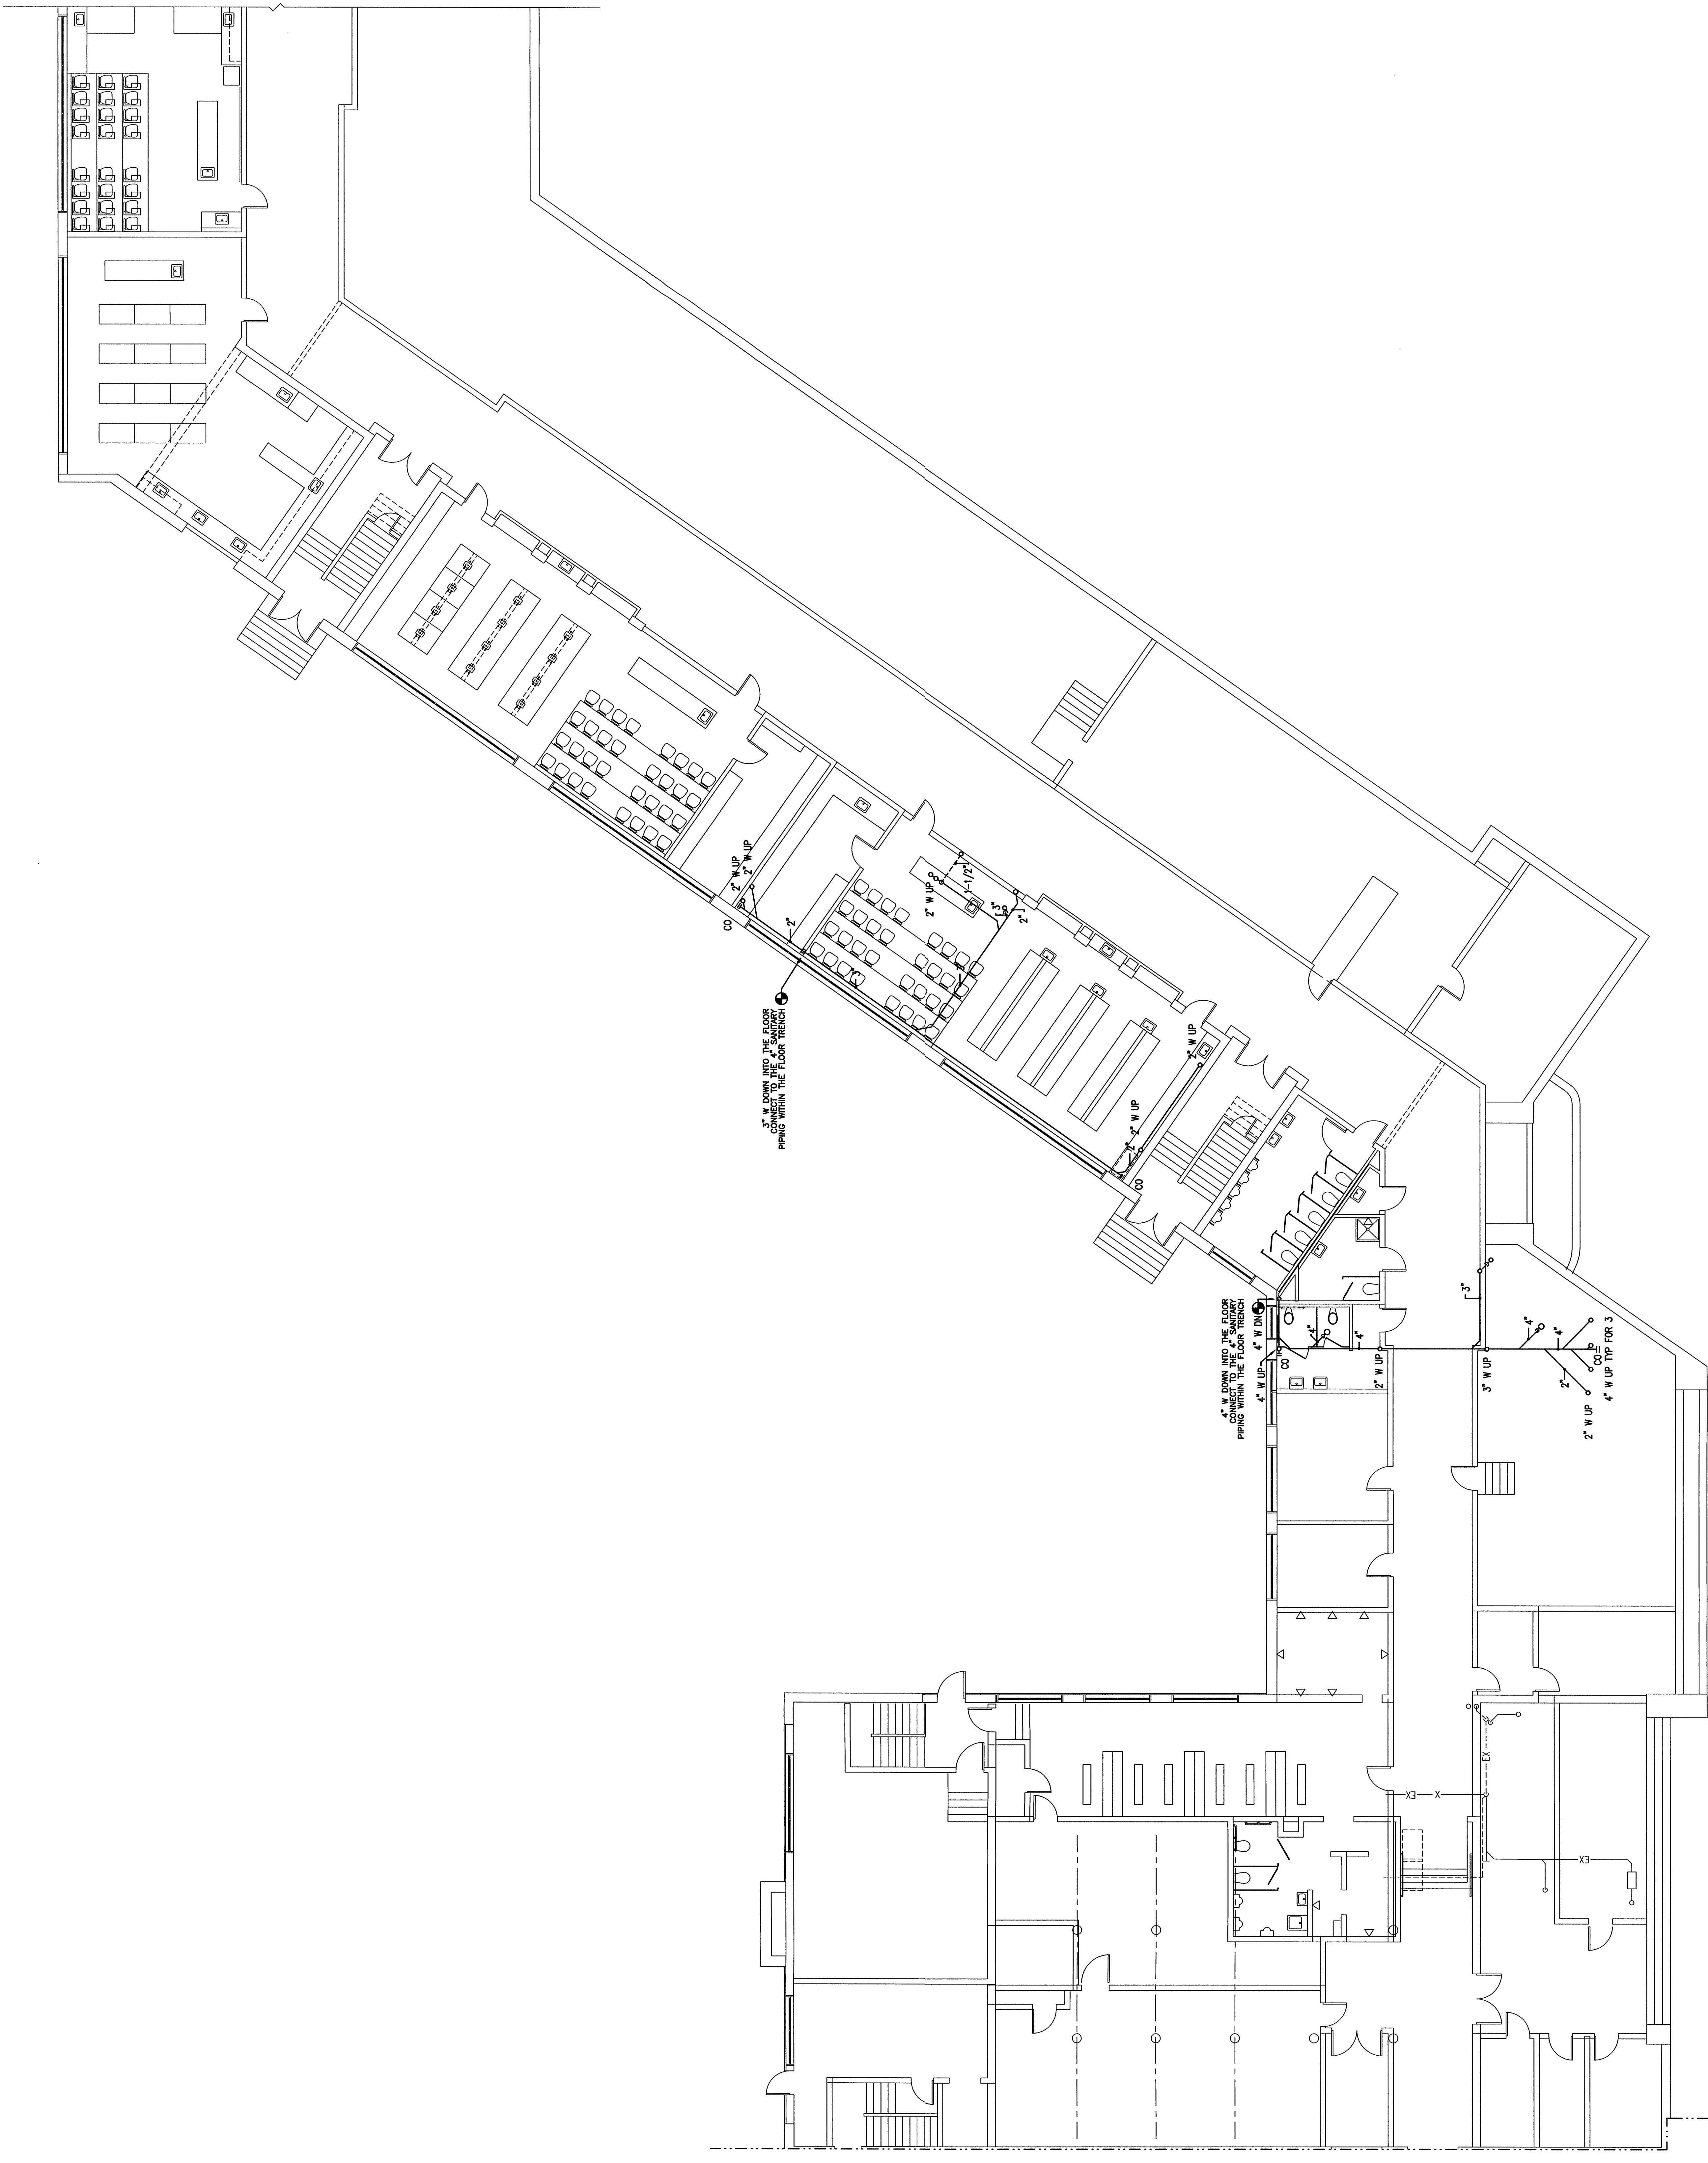

GROUND FLOOR AREA "B" W & V PIPING PLAN
SCALE: 1/8" = 1'-0"
NOTES:
1. FROM RES AS SHOWN AS POSSIBLE COORDINATE WITH STRUCTURAL STEEL.
2. PROVIDE 10 CLEARANCE AT ELBOWS.

AREA "B"
AREA "A"