


Mark	Date	Description
05-24-04		ISSUED FOR BID
05-17-04		OWNER REVIEW
		Issue Date

Drawing Status

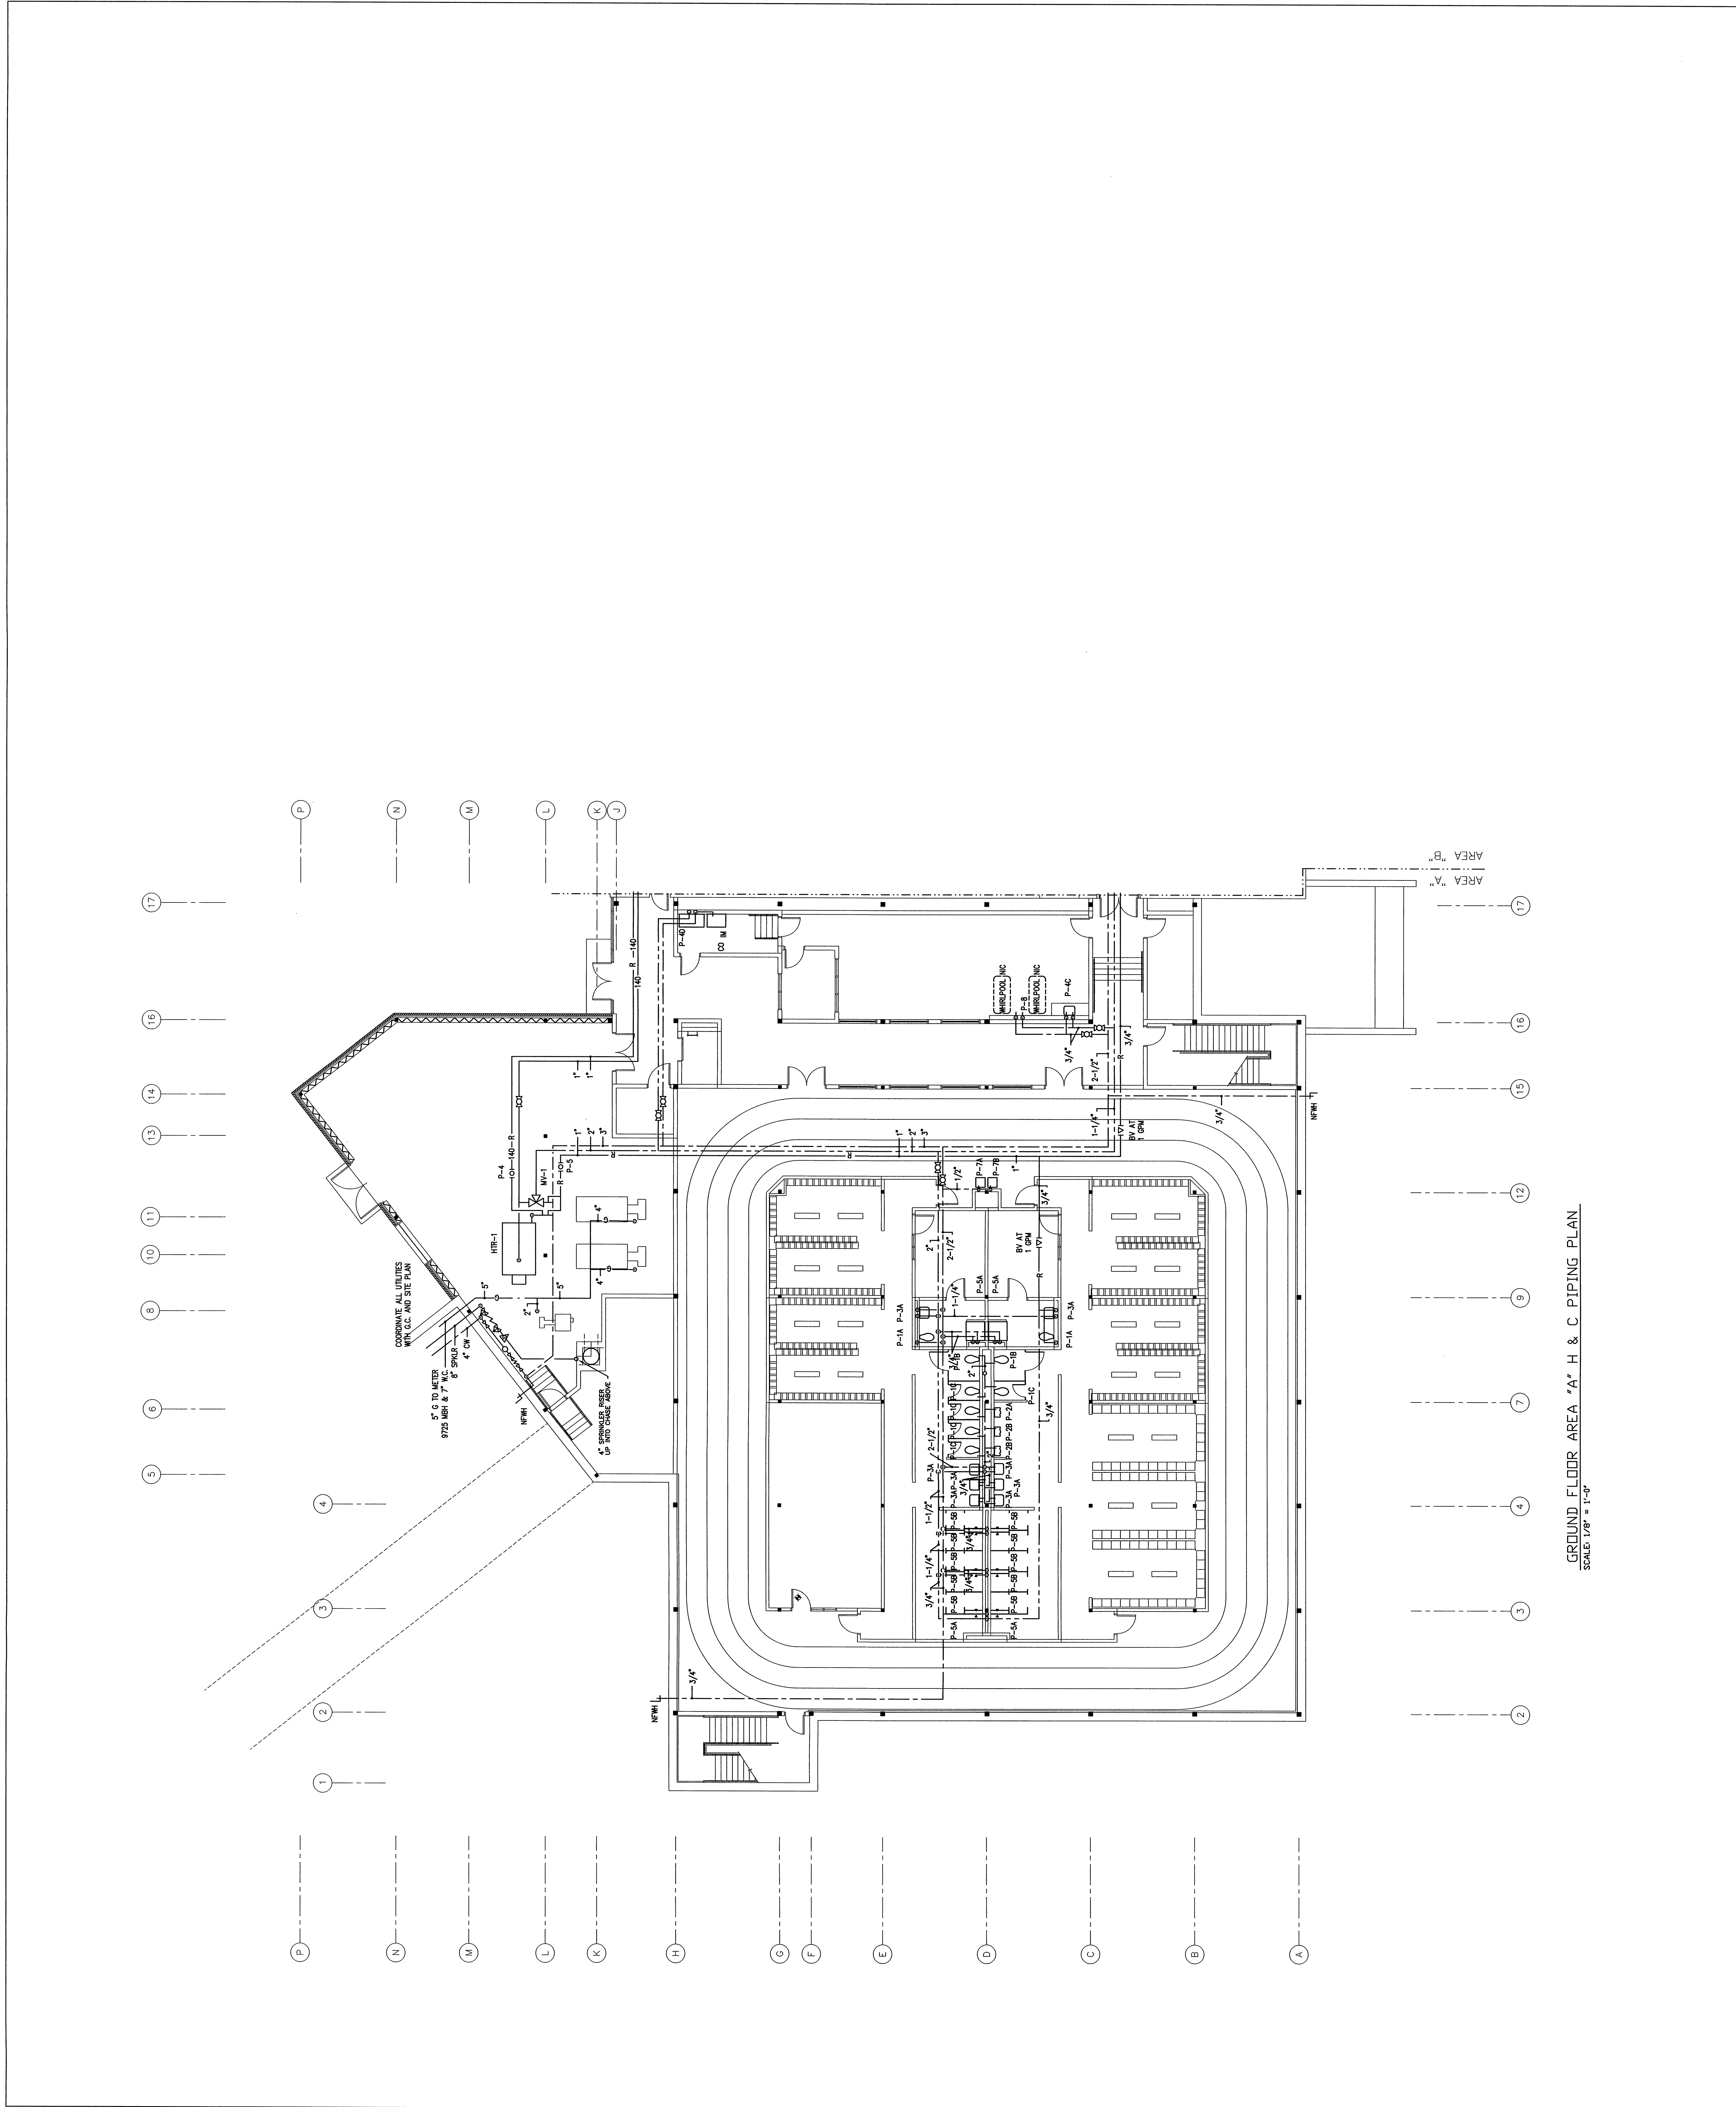

**GROUND FLOOR AREA "A" H & C PIPING PLAN**  
 SCALE: 1/8" = 1'-0"