


Mark	Date	Issue/Description
05-28-24	15% RFD FOR BID	
05-17-24	CONCEPT REVIEW	

Drawing Status	
----------------	--

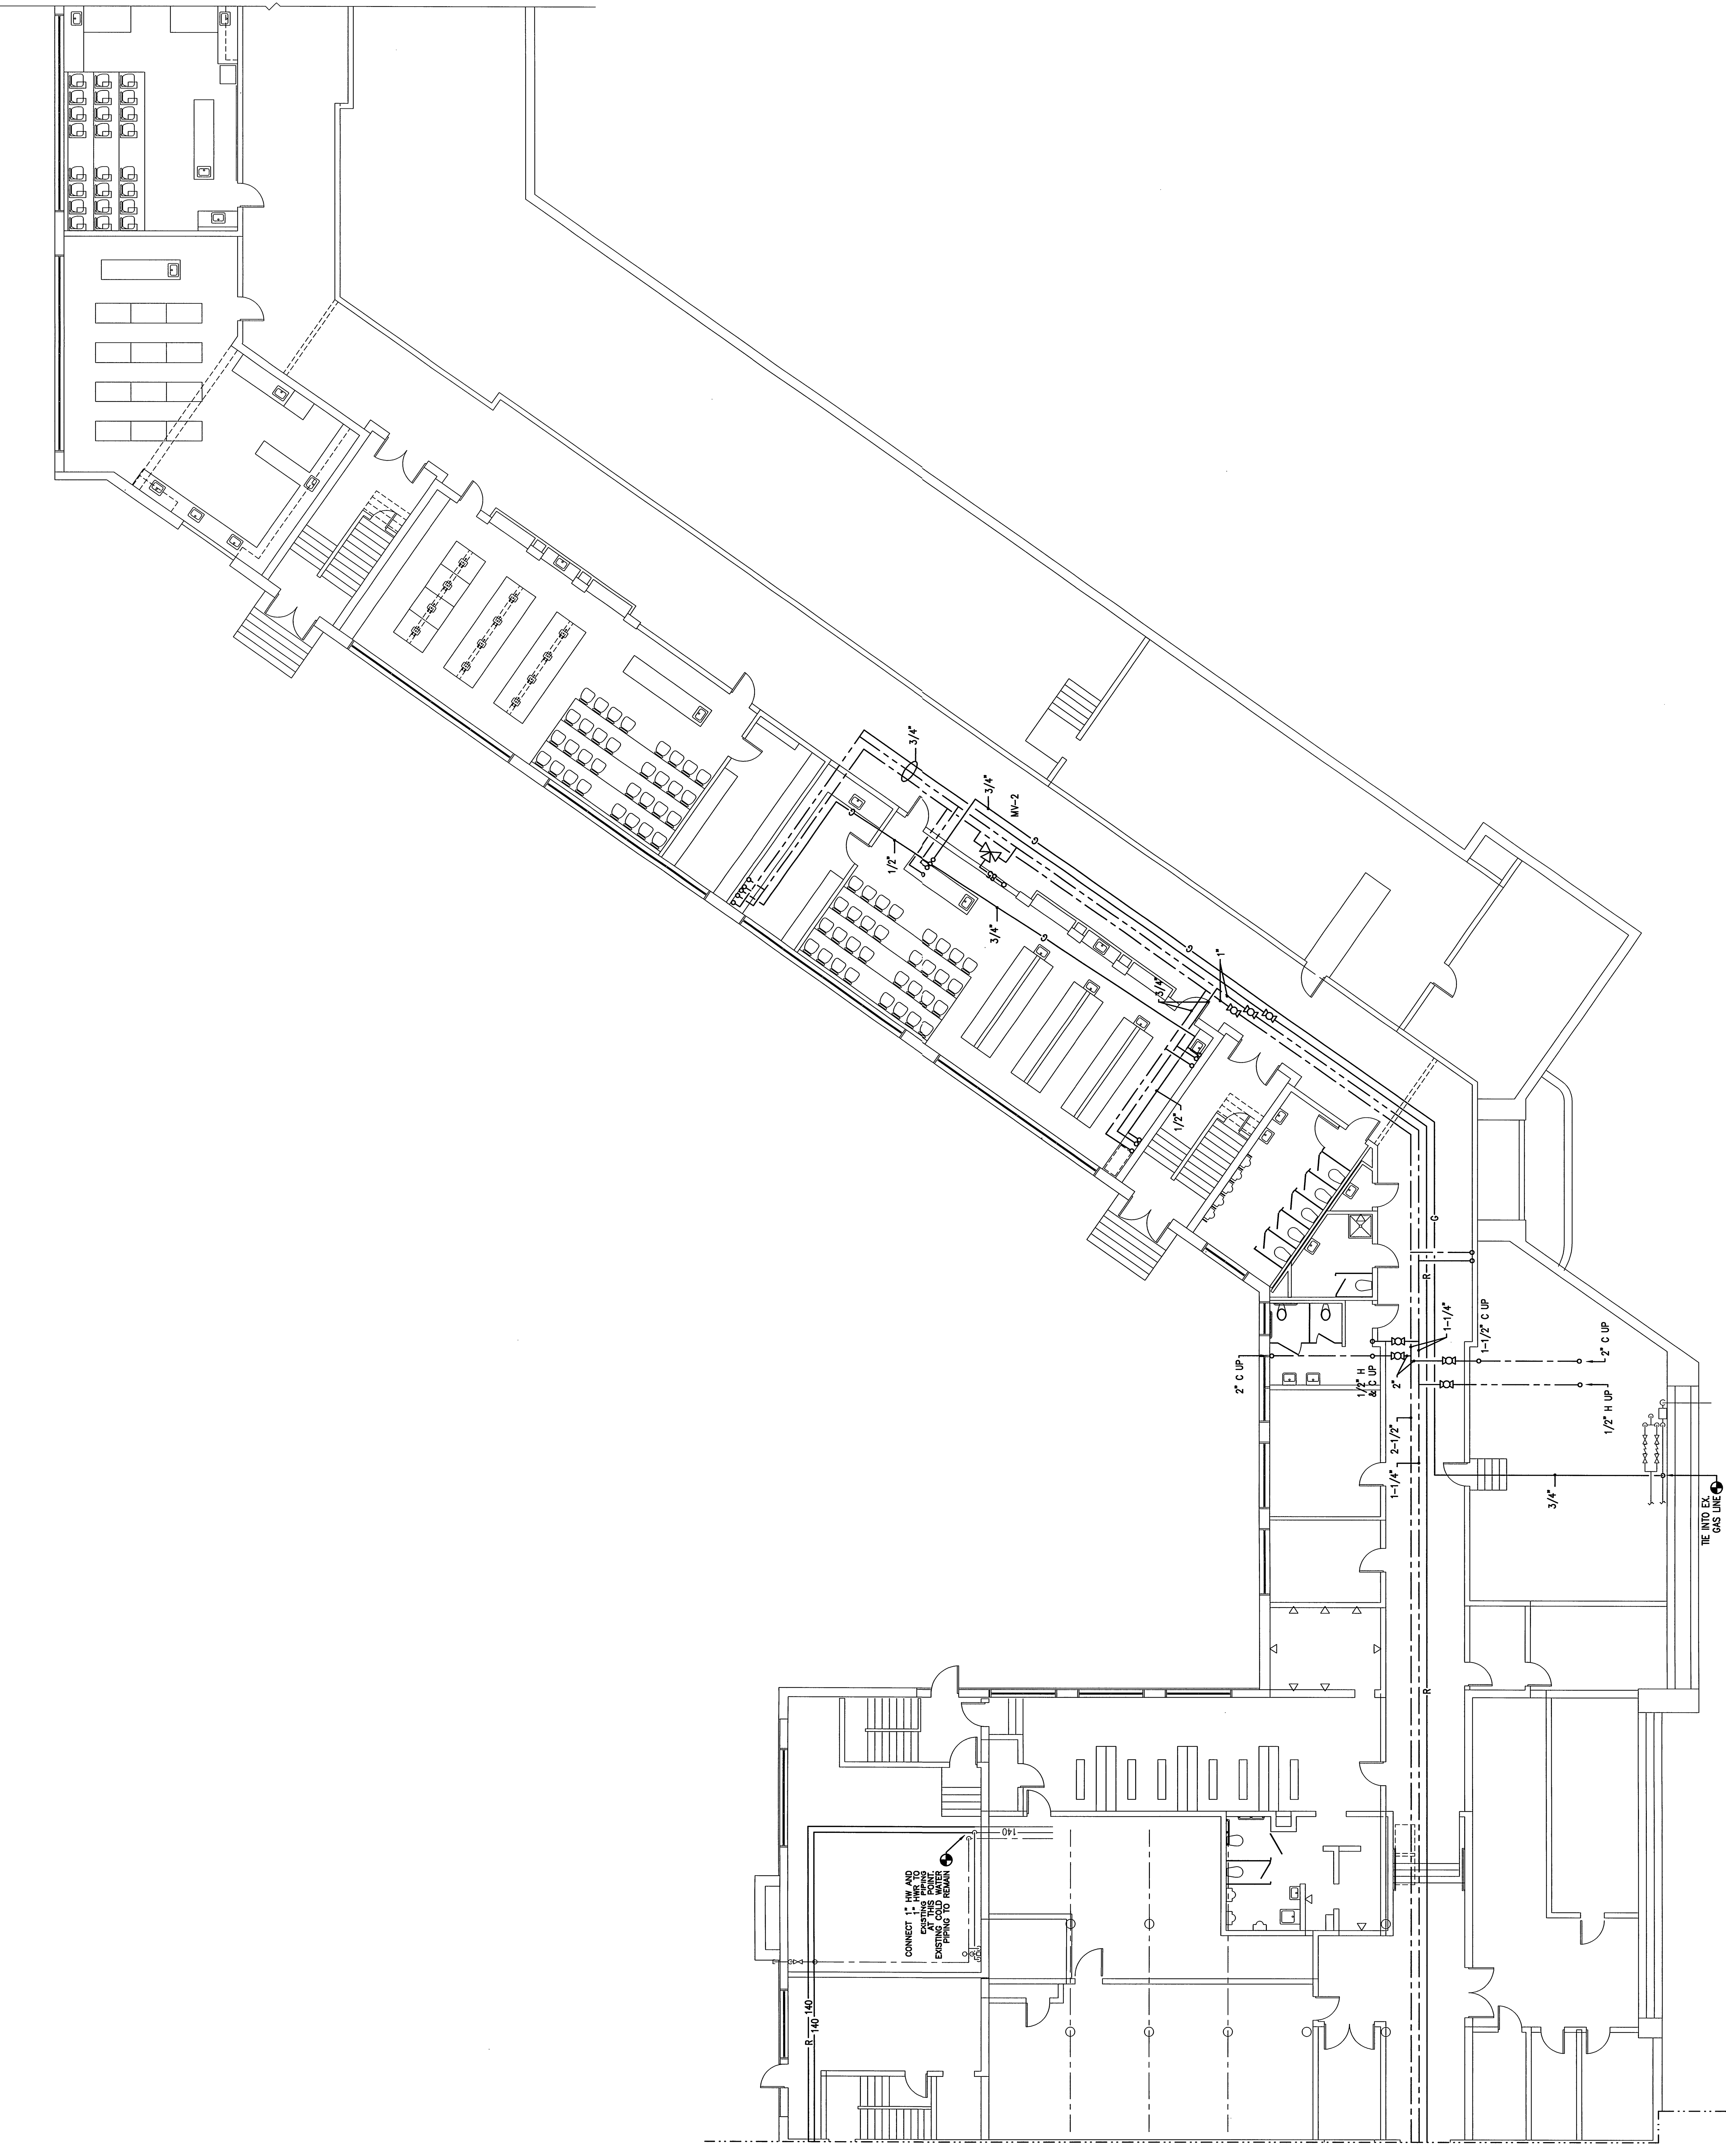

GROUND FLOOR AREA "B" H & C PIPING PLAN
 SCALE: 1/8" = 1'-0"

AREA "A"
 AREA "B"

CONNECT 1" SHAW-WALKER
 VALVE TO EXISTING
 PIPING TO BE
 REMOVED

TE INTO EX
 GAS LINE