

Drawing No. 101

Revisions

COMMUNITY BLDG. PLANS
SCALE 1/4"=1'-0"
Commission No. B4150
Date


SPRINGHILL
PORTLAND, ME.

HOUSING RESOURCES COOP.
ONE CANAL PLAZA
PORTLAND, ME.


ARCHITECTS FOUR
PROFESSIONAL ASSOCIATION
89 MIDDLE STREET
MANCHESTER, N.H.
(603) 627-3844

RECEIVED
JAN 9 1988


TEAM ENGINEERING
255 PINE ST. 4TH FL.
MANCHESTER, N.H. 03101
TEL. 603-627-1100

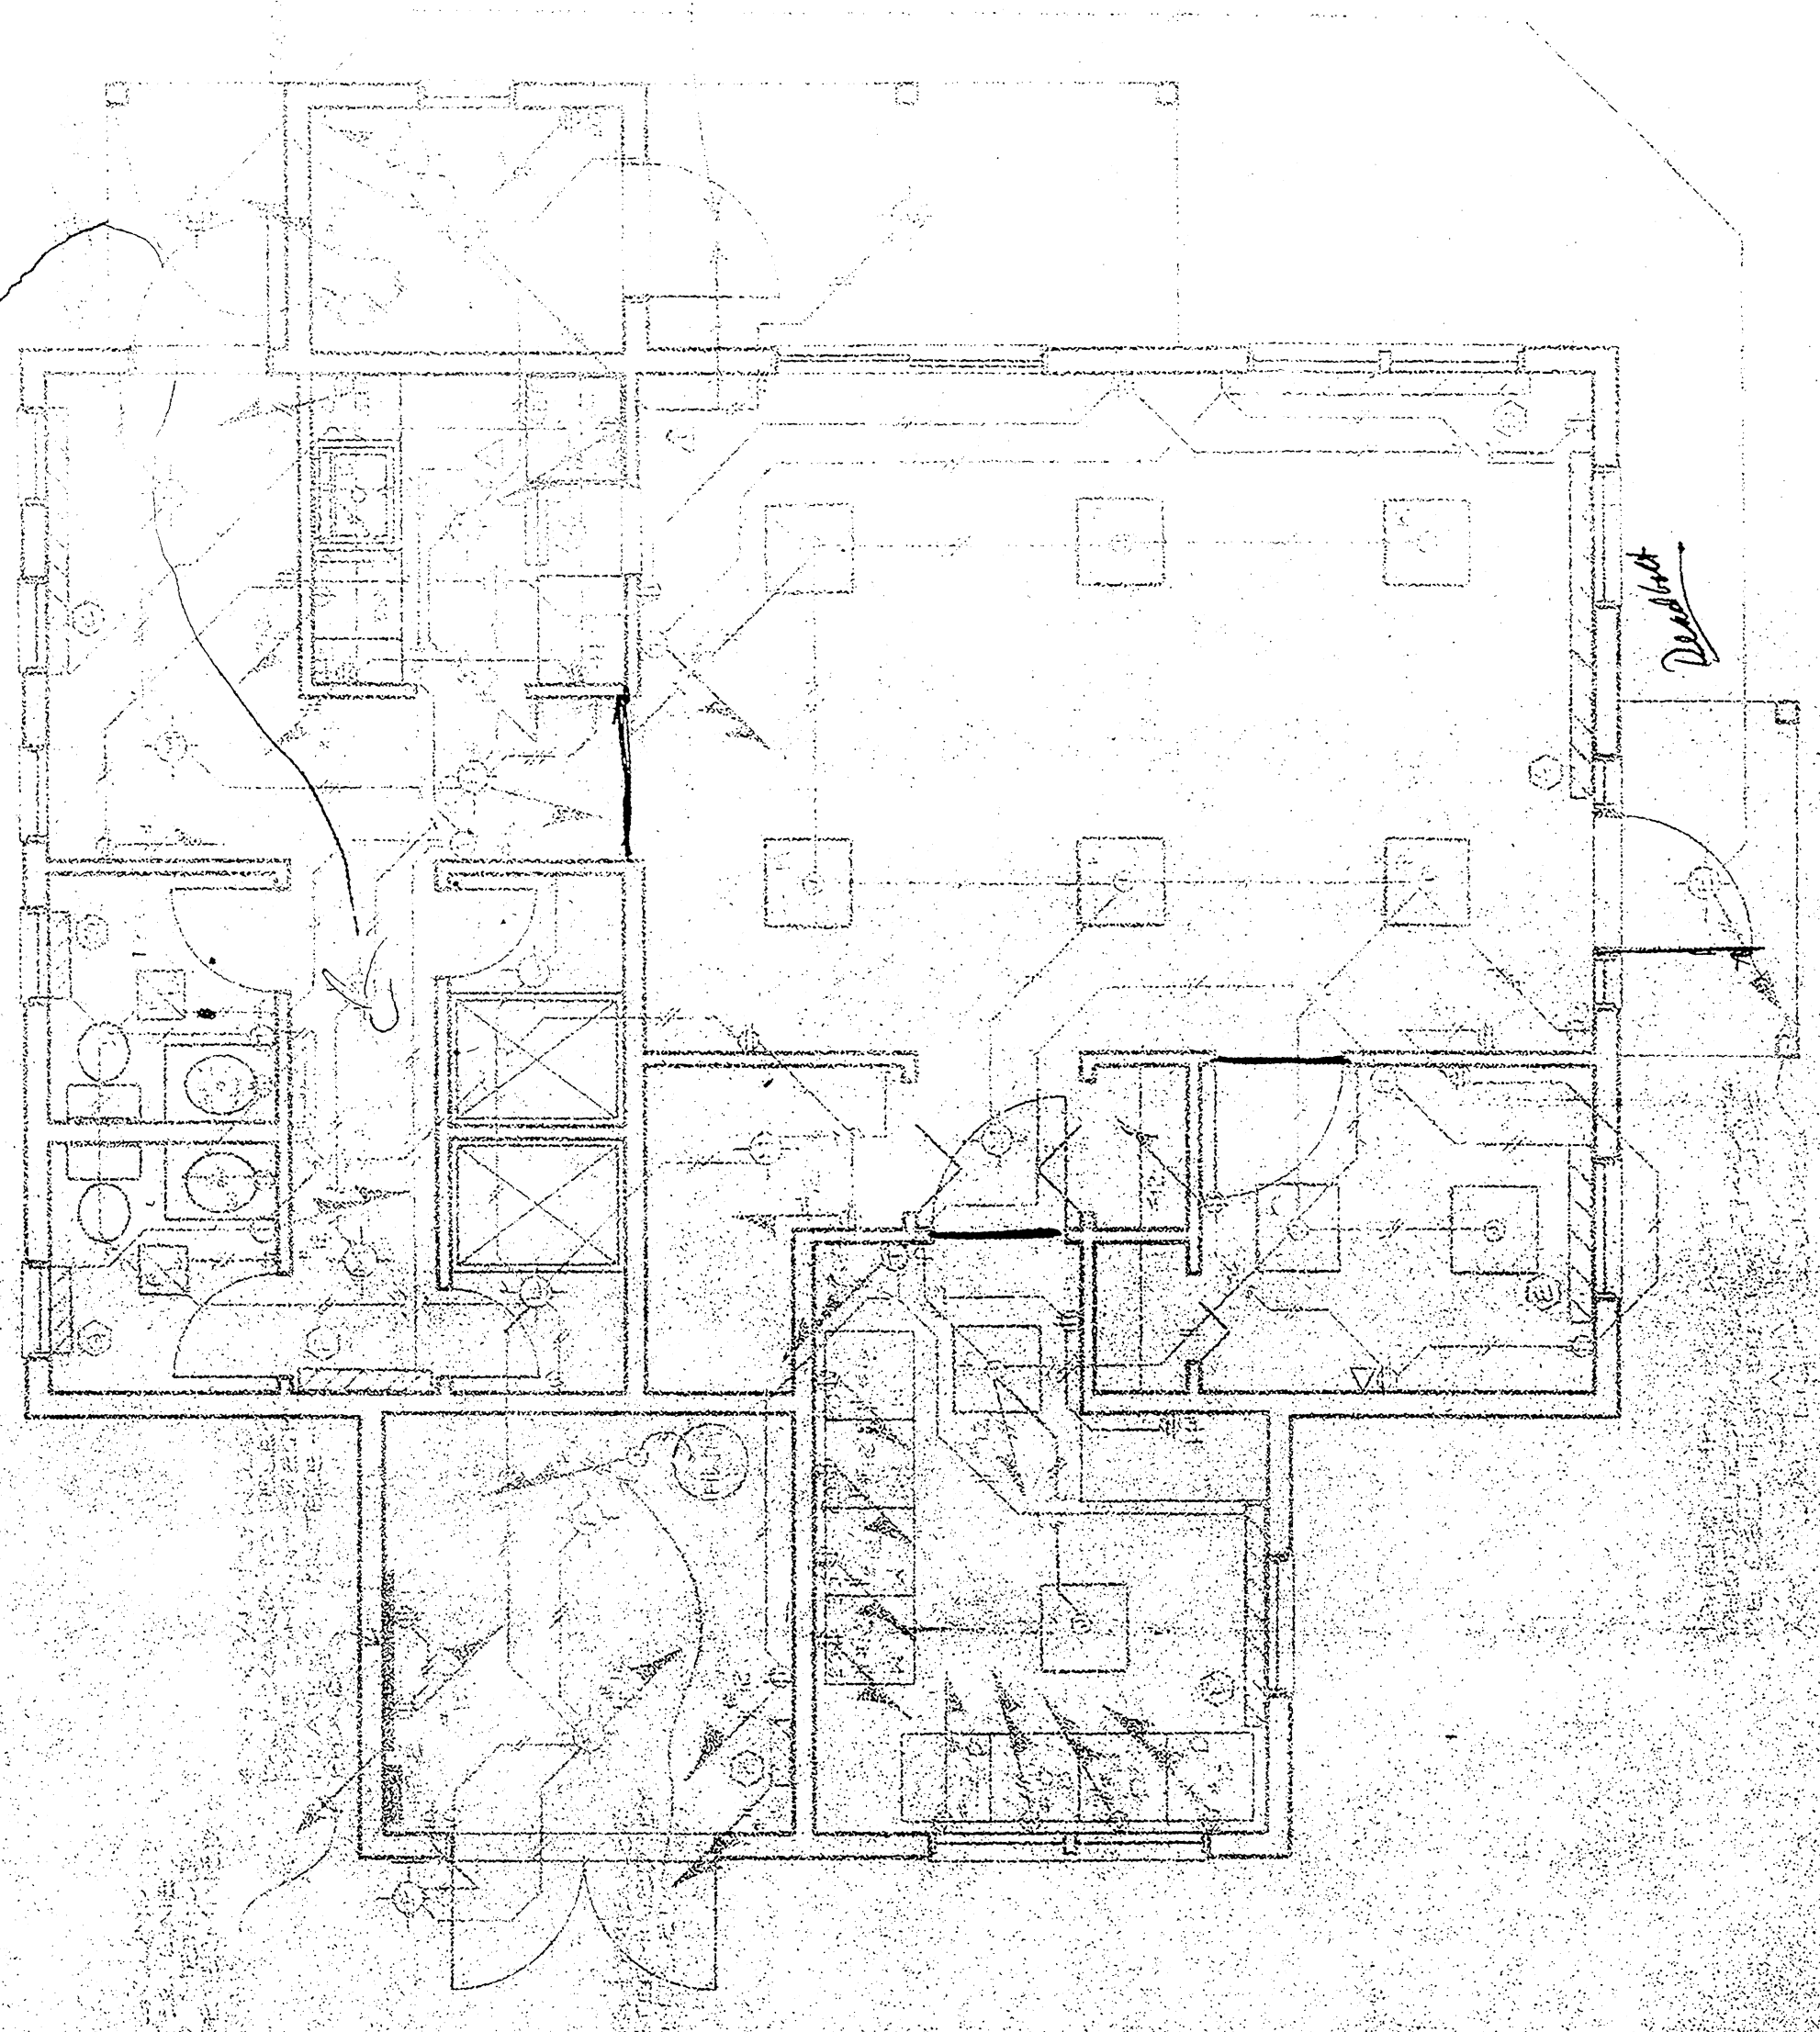

FIRST FLOOR PLAN COMM. BLDG.
SCALE 1/4"=1'-0"

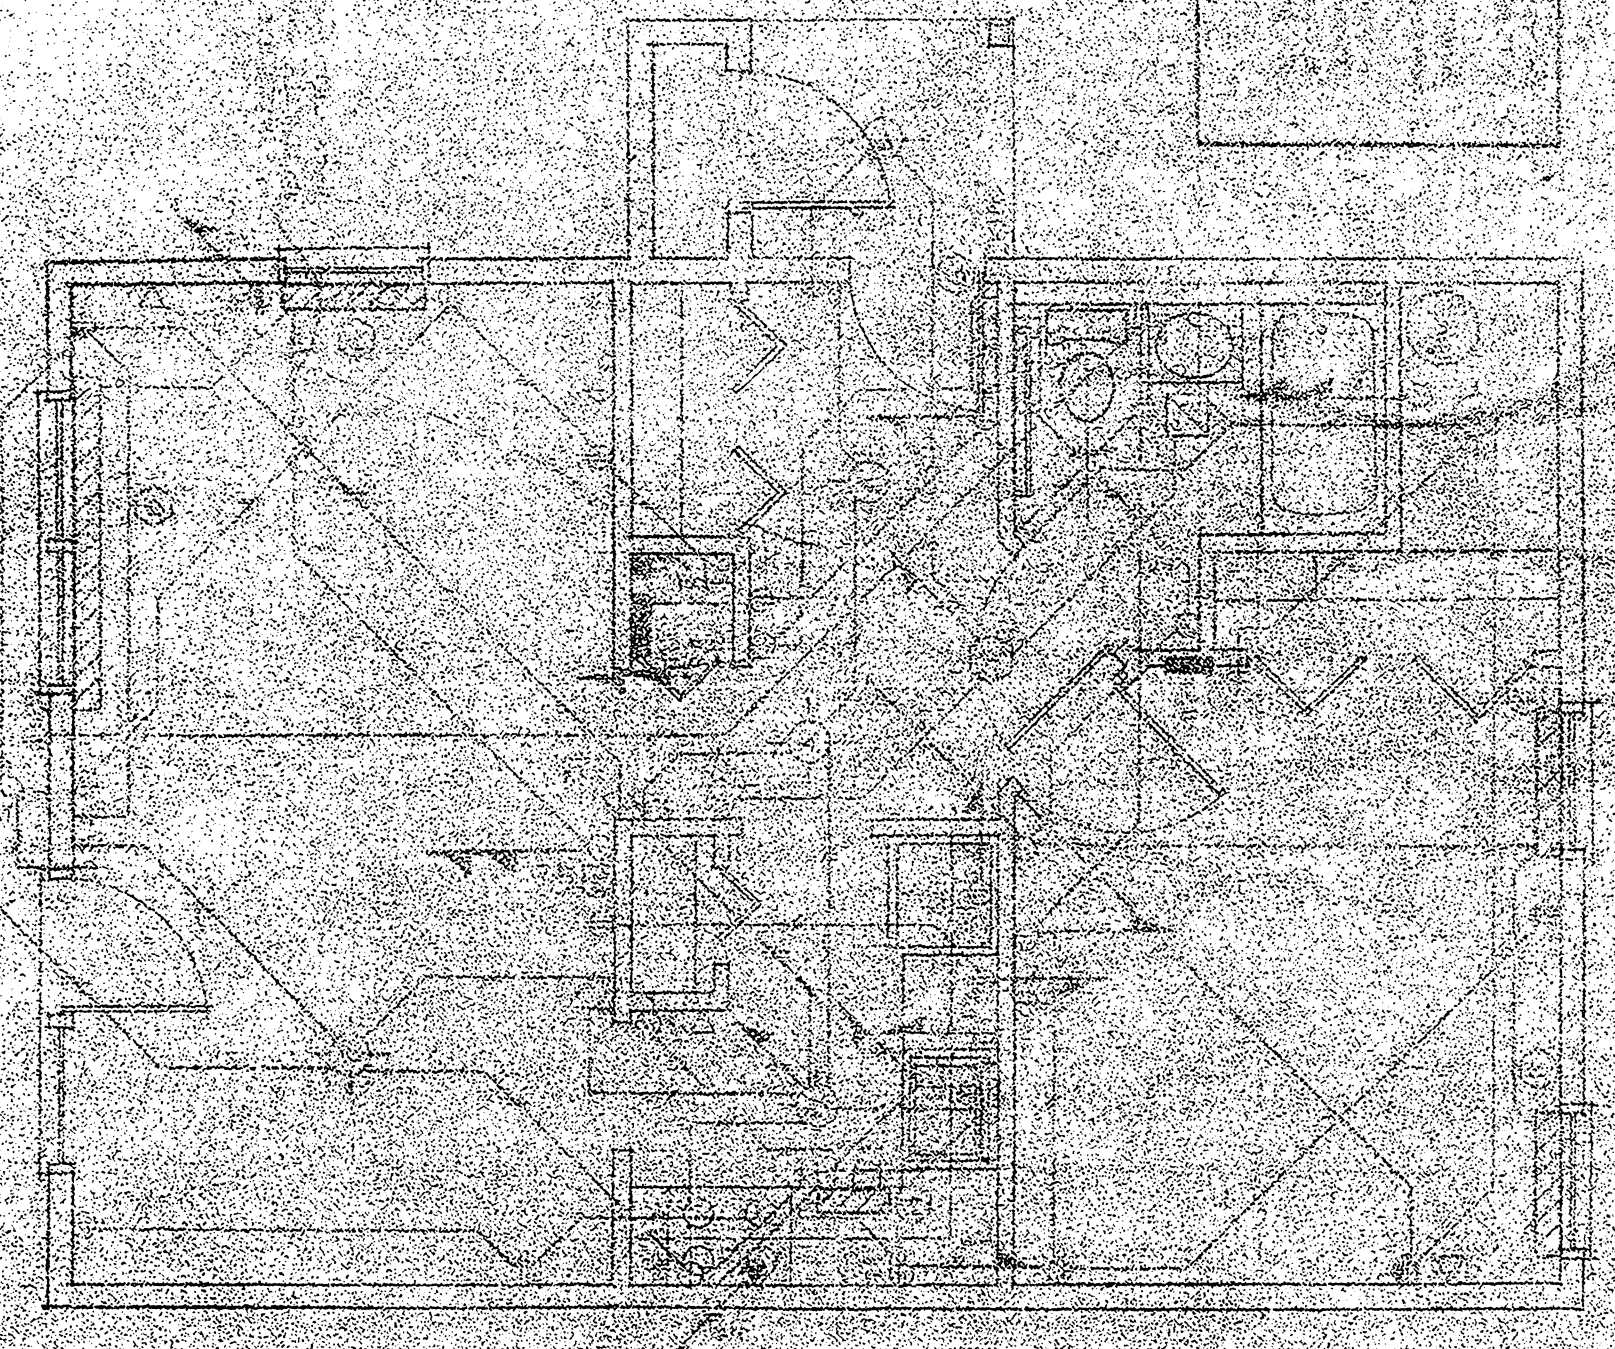

UNIT 101 - ONE EFFICIENCY UNIT
SCALE 1/4"=1'-0"

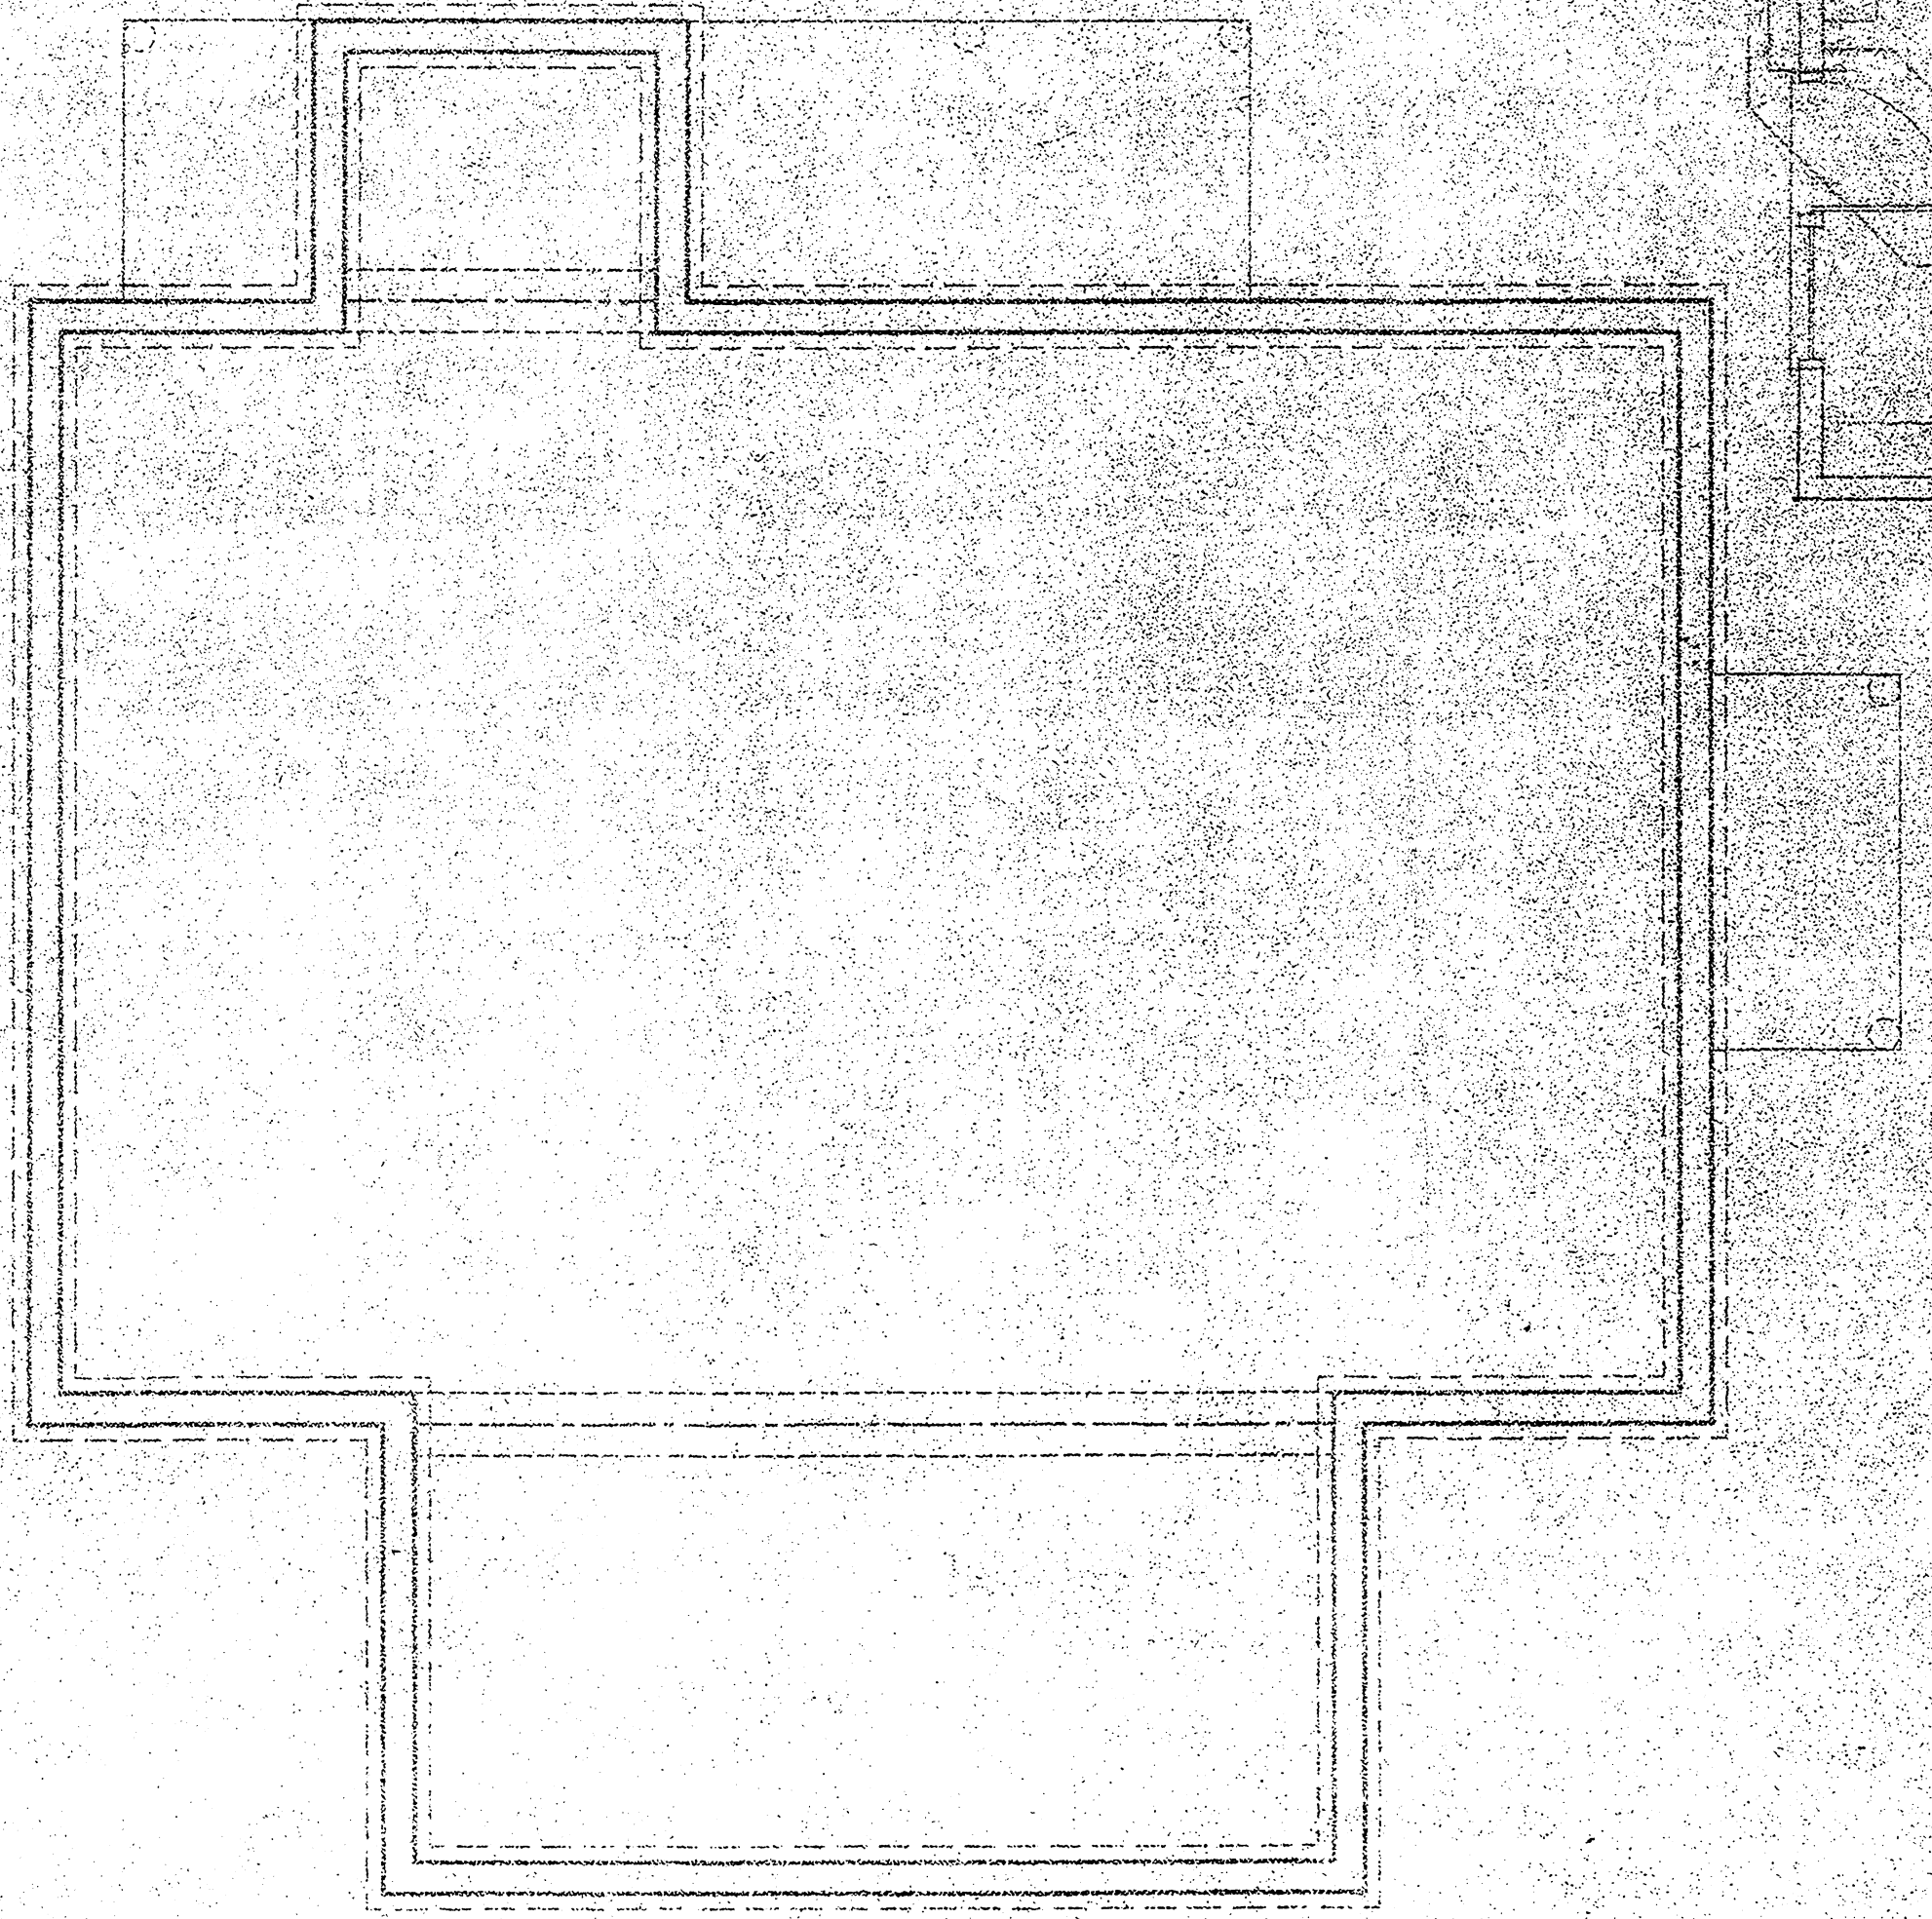

FOUNDATION PLAN COMM. BLDG.
SCALE 1/4"=1'-0"