


**GENERAL CEILING NOTES**

- 1) THIS DRAWING PRIMARILY FOR CEILING SYSTEM AND RELATED FIXTURE LOCATIONS. SEE ELECTRICAL ENGINEER'S DRAWINGS FOR ACTUAL FIXTURE SPECIFICATIONS AND ADDITIONAL INFORMATION.
- 2) ALL CEILING ELEVATIONS INDICATED ARE FROM FINISH FLOOR FOR THAT PARTICULAR ROOM.
- 3) CCTV SYSTEM PROVIDED BY OWNER, INSTALLED BY OTHERS. 4 CC CAMERAS AND 2 TV MONITORS SHALL BE FIELD LOCATED PER OWNER'S INSTRUCTION.
- 4) SEE ELECTRICAL DRAWINGS FOR ALL LIGHTING FIXTURE SPECIFICATIONS.
- 5) CONTRACTOR TO BALANCE HVAC SYSTEM.

**LEGEND**

	2x4 SUSPENDED CEILING GRID SYSTEM		SURFACE MOUNTED FLUORESCENT LIGHT FIXTURE FOR COOLER/FREEZER		RECESSED INTERIOR DOWN LIGHT FIXTURE W/ LENS		SUPPLY DIFFUSER		FIRE ALARM
	2x2 SUSPENDED CEILING GRID SYSTEM		2x2 RECESSED FLUORESCENT FIXTURE		PENDANT LIGHT W/ PLASTIC LENSES		RETURN DIFFUSER		EXIT SIGN
	GYPSUM WALLBOARD CEILING		2x4 RECESSED FLUORESCENT FIXTURE		SURFACE MOUNTED EXTERIOR EMERGENCY REMOTE HEAD		EXHAUST FAN (SEE MECH. DINGS)		EMERGENCY LIGHTING FIXTURE
	CEILING MATERIAL		SURFACE MOUNTED EXTERIOR LIGHT FIXTURE		WALL MOUNTED EXTERIOR EMERGENCY REMOTE HEAD		5 1/4"x48" LINEAR SUPPLY DIFFUSER		SPEAKER
	CEILING FINISH		RECESSED EXTERIOR DOWN LIGHT FIXTURE, WATERPROOF		RECESSED EXTERIOR DOWN LIGHT FIXTURE, WATERPROOF		SENSOR FOR RTU		VINYL SOFFIT PANELS
	CEILING HEIGHT		PENDANT LIGHT IN W-IN COOLER						

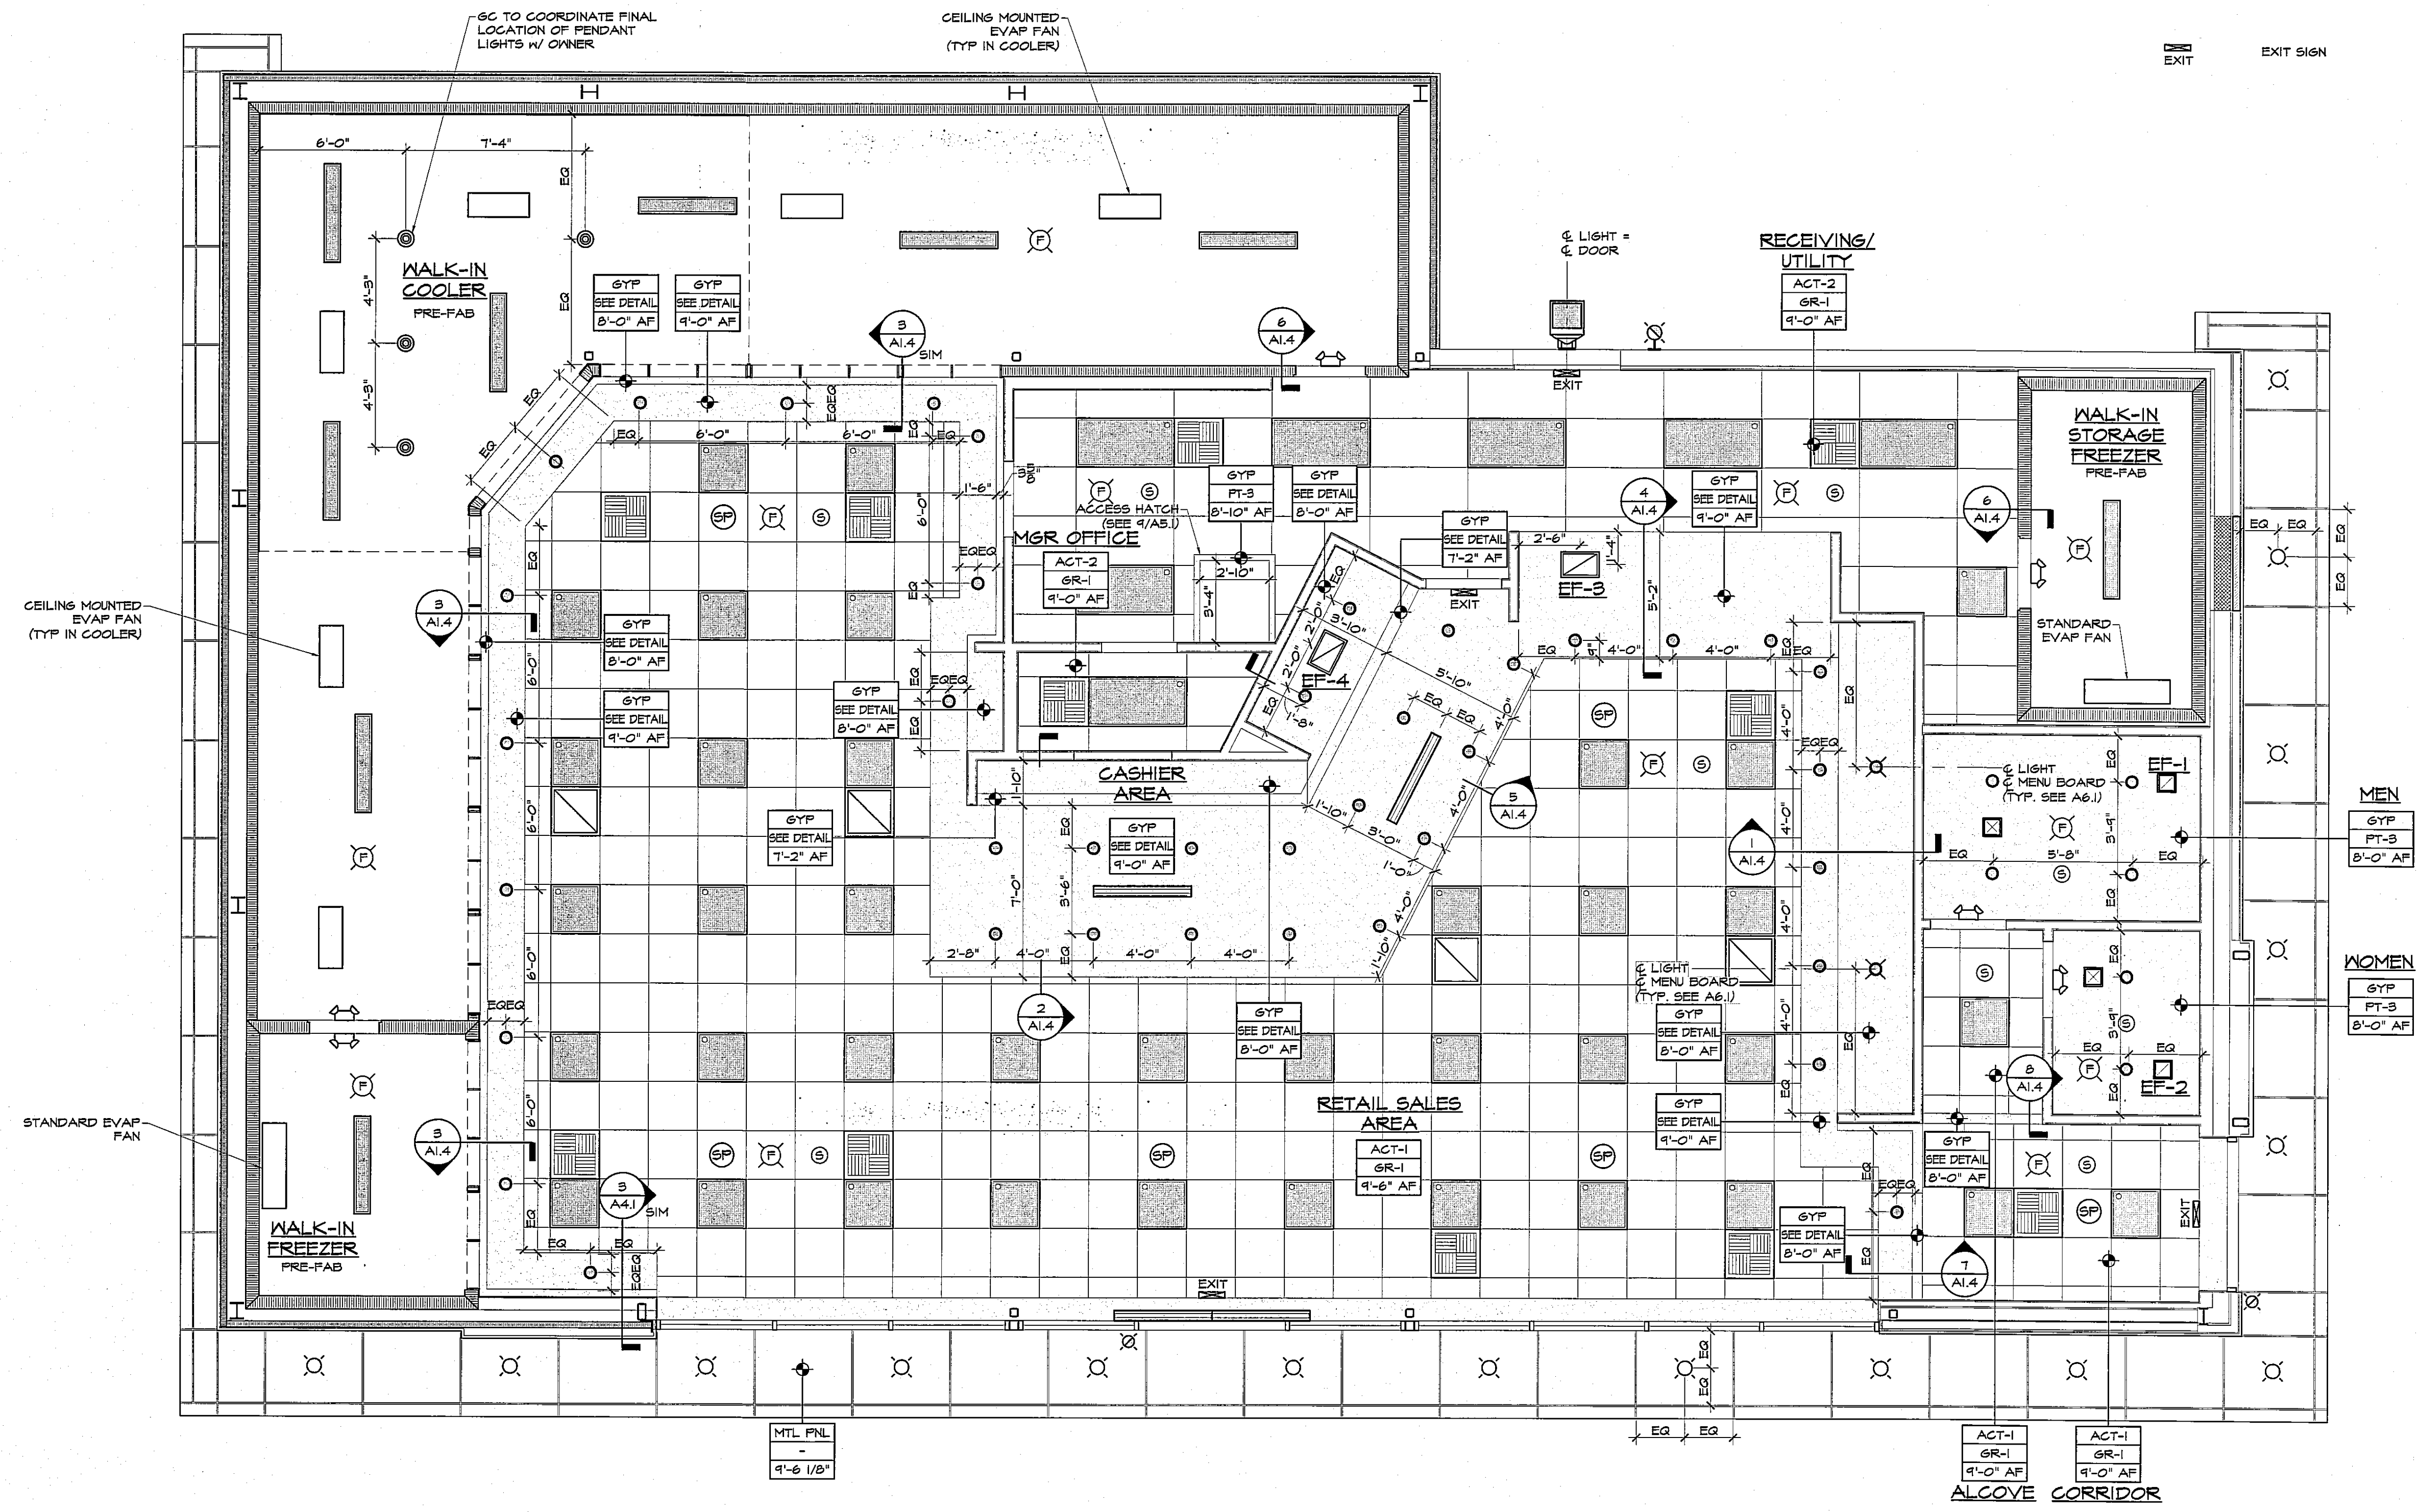

**AHARONIAN & ASSOCIATES INC. ARCHITECTS**


310 George Washington Highway  
 Suite 100  
 Smithfield, Rhode Island  
 02917  
 T 401-232-5010  
 F 401-232-5080  
 WWW.ARCH-ENG.COM

**DISCLAIMER**

OWNERSHIP AND USE OF DOCUMENTS, DRAWINGS AND SPECIFICATIONS ARE INSTRUMENTS OF PROFESSIONAL SERVICE AND SHALL REMAIN THE PROPERTY OF THE ARCHITECT. THESE DOCUMENTS ARE NOT TO BE USED, IN WHOLE OR IN PART, FOR ANY OTHER PROJECTS OR PURPOSES OR BY ANY OTHER PARTIES THAN THOSE PROPERLY AUTHORIZED BY CONTRACT WITHOUT THE EXPRESS WRITTEN AUTHORIZATION OF THE ARCHITECT.

**REVISIONS**

NUMBER	REMARKS	DATE

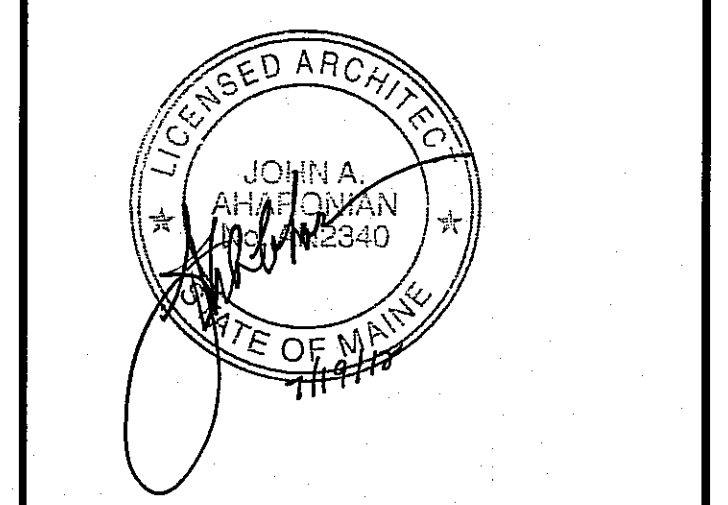

**FOR CONSTRUCTION**

**PROJECT TITLE**

**Cumberland FARMS**  
 100 Crossing Blvd, Framingham, Massachusetts  
 STORE # 5604  
 V1079

**801 WASHINGTON AVE**  
**PORTLAND, ME**  
 Cumberland County

**DRAWING TITLE**

**REFLECTED CEILING PLAN & NOTES**

<b>DATE</b> JULY 19, 2012	<b>PROJ NO</b> 11112
<b>DRAWN BY</b> BB	<b>CHECKED BY</b> AZ
<b>DRAWING NUMBER</b>	

**A1.3**

© AHARONIAN & ASSOCIATES INC 2012

**REFLECTED CEILING PLAN**  
 SCALE: 1/4" = 1'-0"