

AHARONIAN & ASSOCIATES INC. ARCHITECTS


310 George Washington Highway
Suite 100
Smithfield, Rhode Island
0 2 9 1 7
T 401-232-5010
F 401-232-8080
WWW.ARCH-ENG.COM

DISCLAIMER

OWNERSHIP AND USE OF DOCUMENTS, DRAWINGS AND SPECIFICATIONS ARE INSTRUMENTS OF PROFESSIONAL SERVICE AND SHALL REMAIN THE PROPERTY OF THE ARCHITECT. THESE DOCUMENTS ARE NOT TO BE USED, IN WHOLE OR IN PART, FOR ANY OTHER PROJECTS OR PURPOSES OR BY ANY OTHER PARTIES THAN THOSE PROPERLY AUTHORIZED BY CONTRACT WITHOUT THE EXPRESS WRITTEN AUTHORIZATION OF THE ARCHITECT.

REVISIONS

NUMBER	REMARKS	DATE

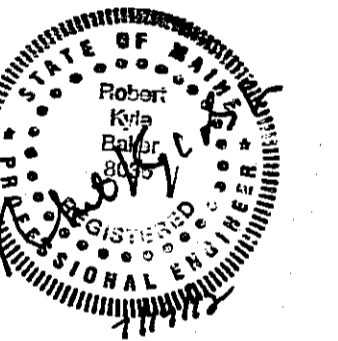

FOR CONSTRUCTION

PROJECT TITLE

Cumberland FARMS
100 Crossing Blvd, Framingham, Massachusetts
STORE # 5604
V1079

801 WASHINGTON AVE
PORTLAND, ME
Cumberland County

DRAWING TITLE

MECHANICAL PLAN


DATE JULY 19, 2012	PROJ NO 11112
DRAWN BY JL	CHECKED BY AZ

DRAWING NUMBER

M1.1

LEGEND

	SUPPLY DIFFUSER		FLEXIBLE DUCTWORK
	SUPPLY RETURN		BRANCH TAKEOFF
	SENSOR FOR RTU		VOLUME DAMPER
	THERMOSTAT		
	INDICATES RESISTER/GRILLE/DIFFUSER TYPE		
	INDICATES CFM AIRFLOW		

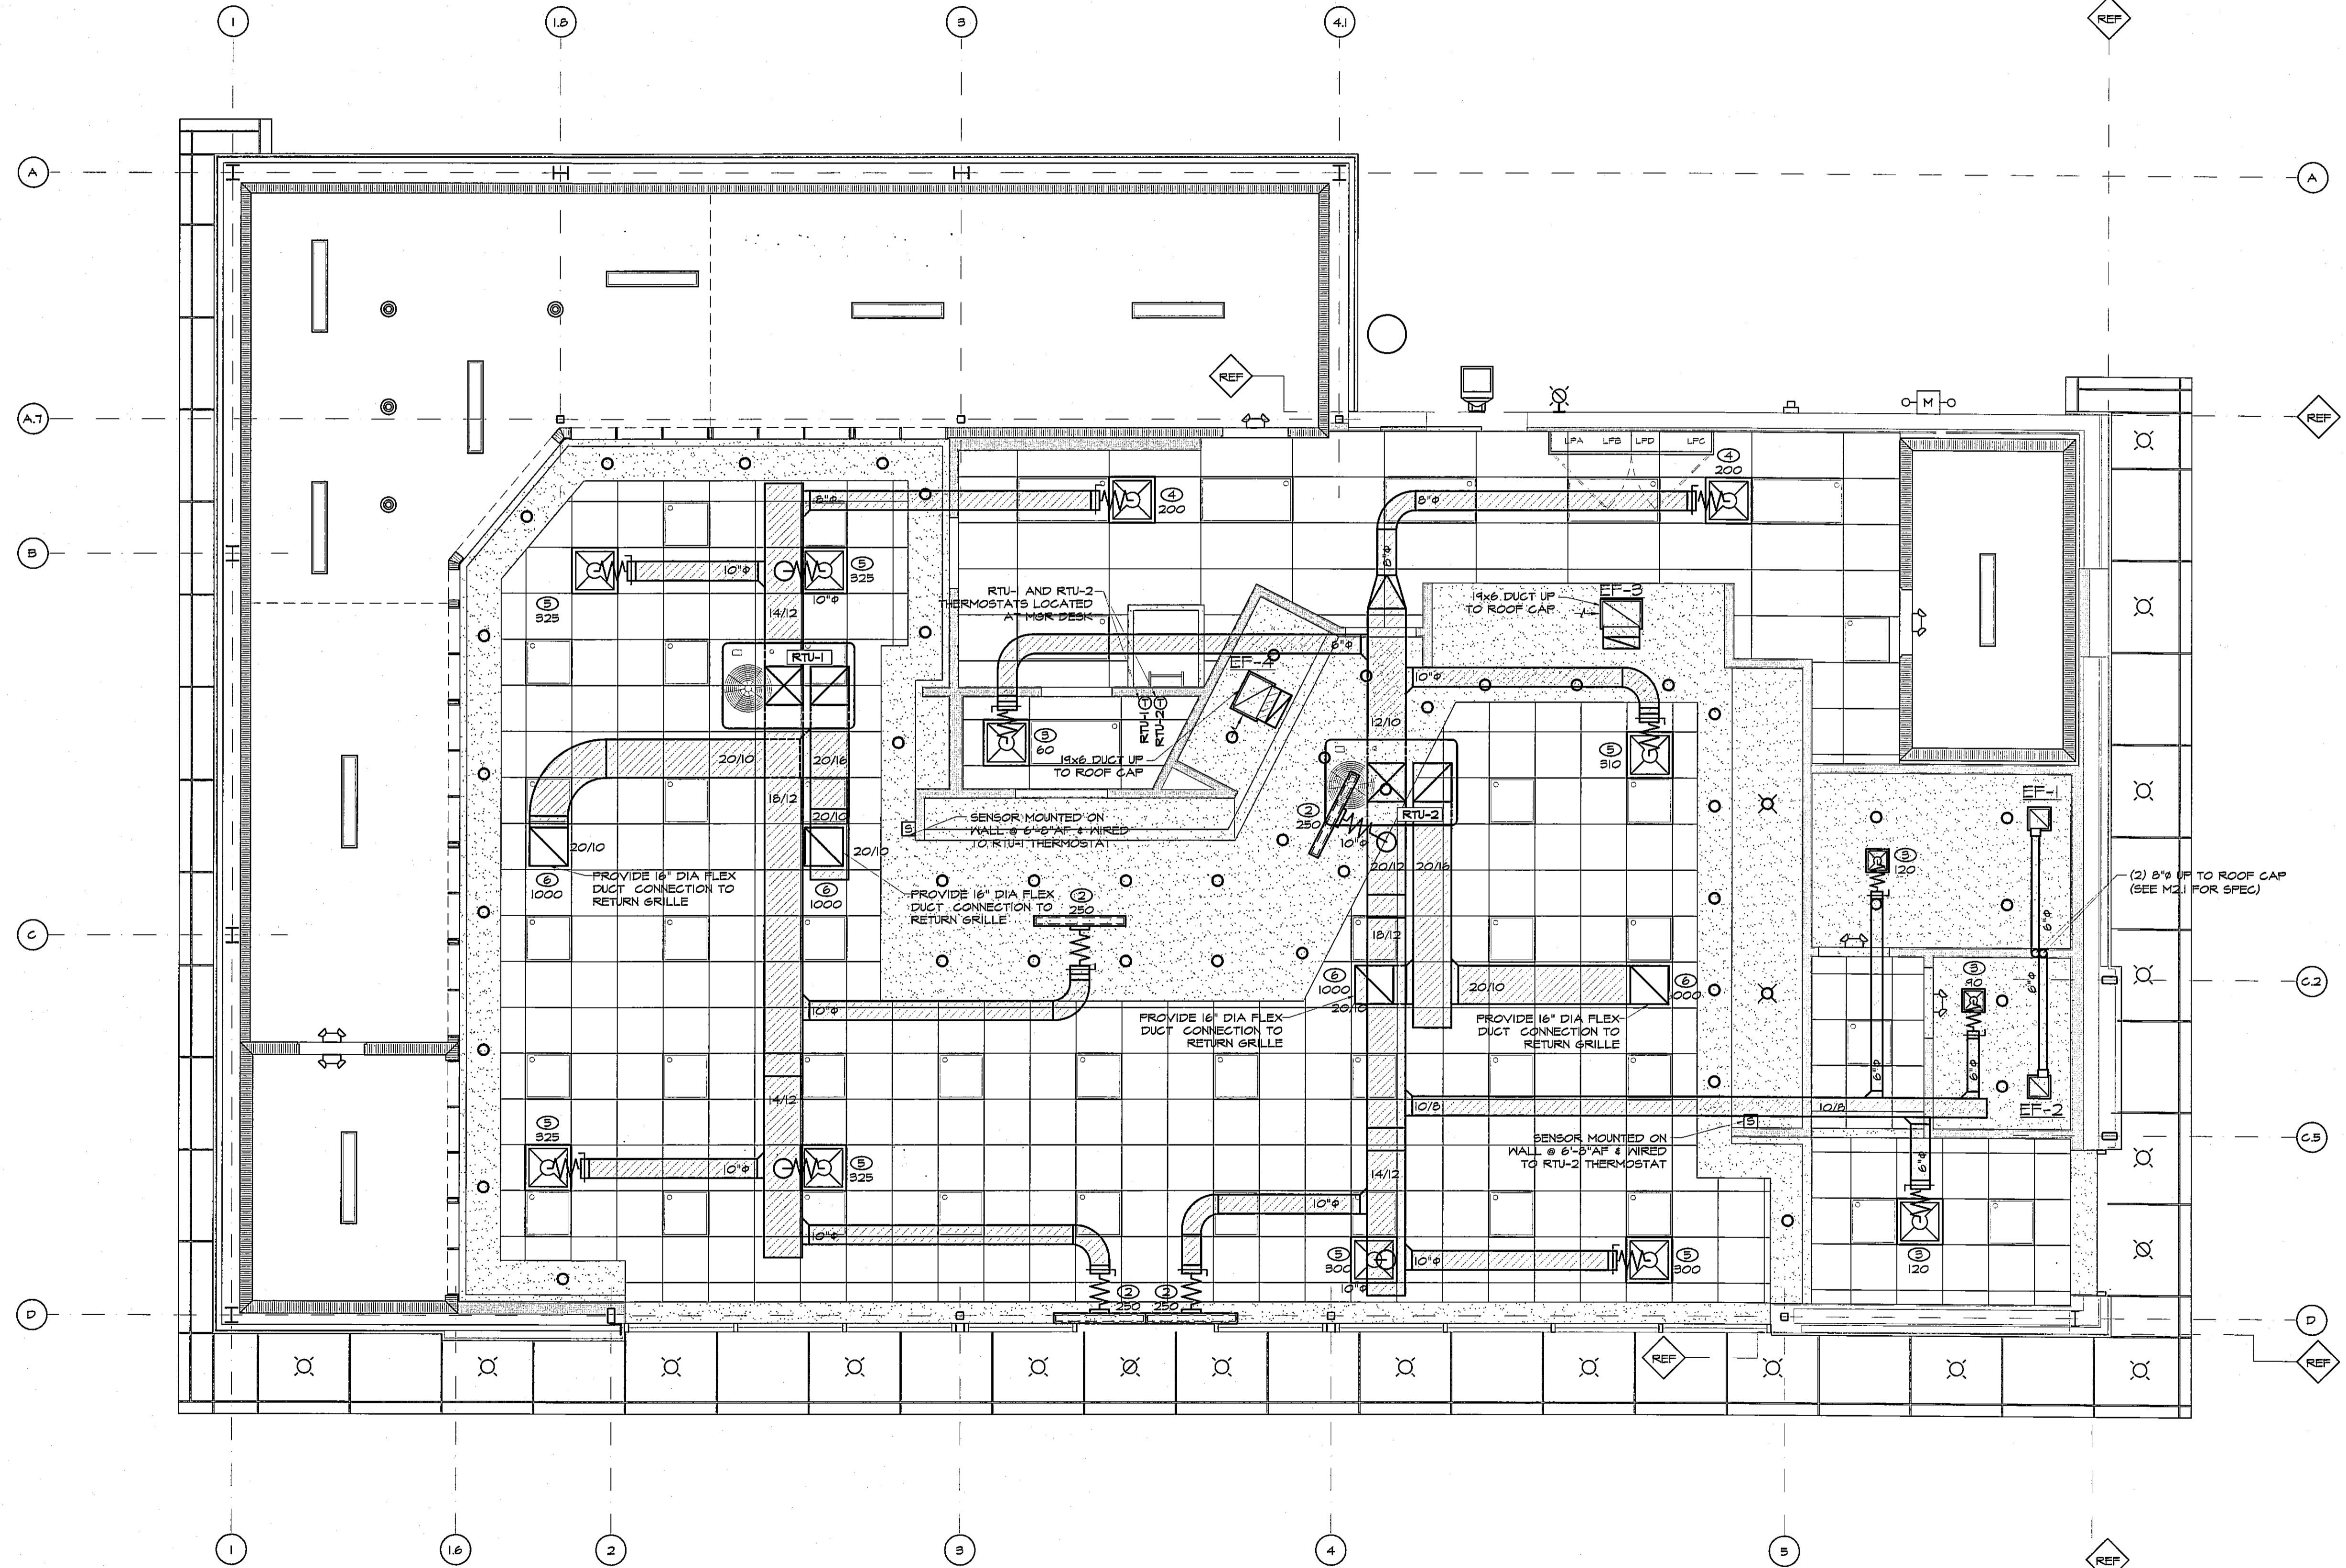

MECHANICAL PLAN
SCALE: 1/4" = 1'-0"



© AHARONIAN & ASSOCIATES INC 2012