

Civil Engineer
Ransom Consulting, Inc.
400 Commercial Street, Suite 404
Portland, Maine 04101
207-772-2891




SITE PLAN

No.	Revision/Issue	Date
C	PERMITTING	5-30-18
C	PROGRESS PRINT	5-29-18
B	PROGRESS PRINT	5-24-18
A	PROGRESS PRINT	5-14-18

Design by:	Checked by:
JIM	SJB
Drawn by:	Approved by:
JIM	SJB

Project: 141.06157
Sheet No:

C1

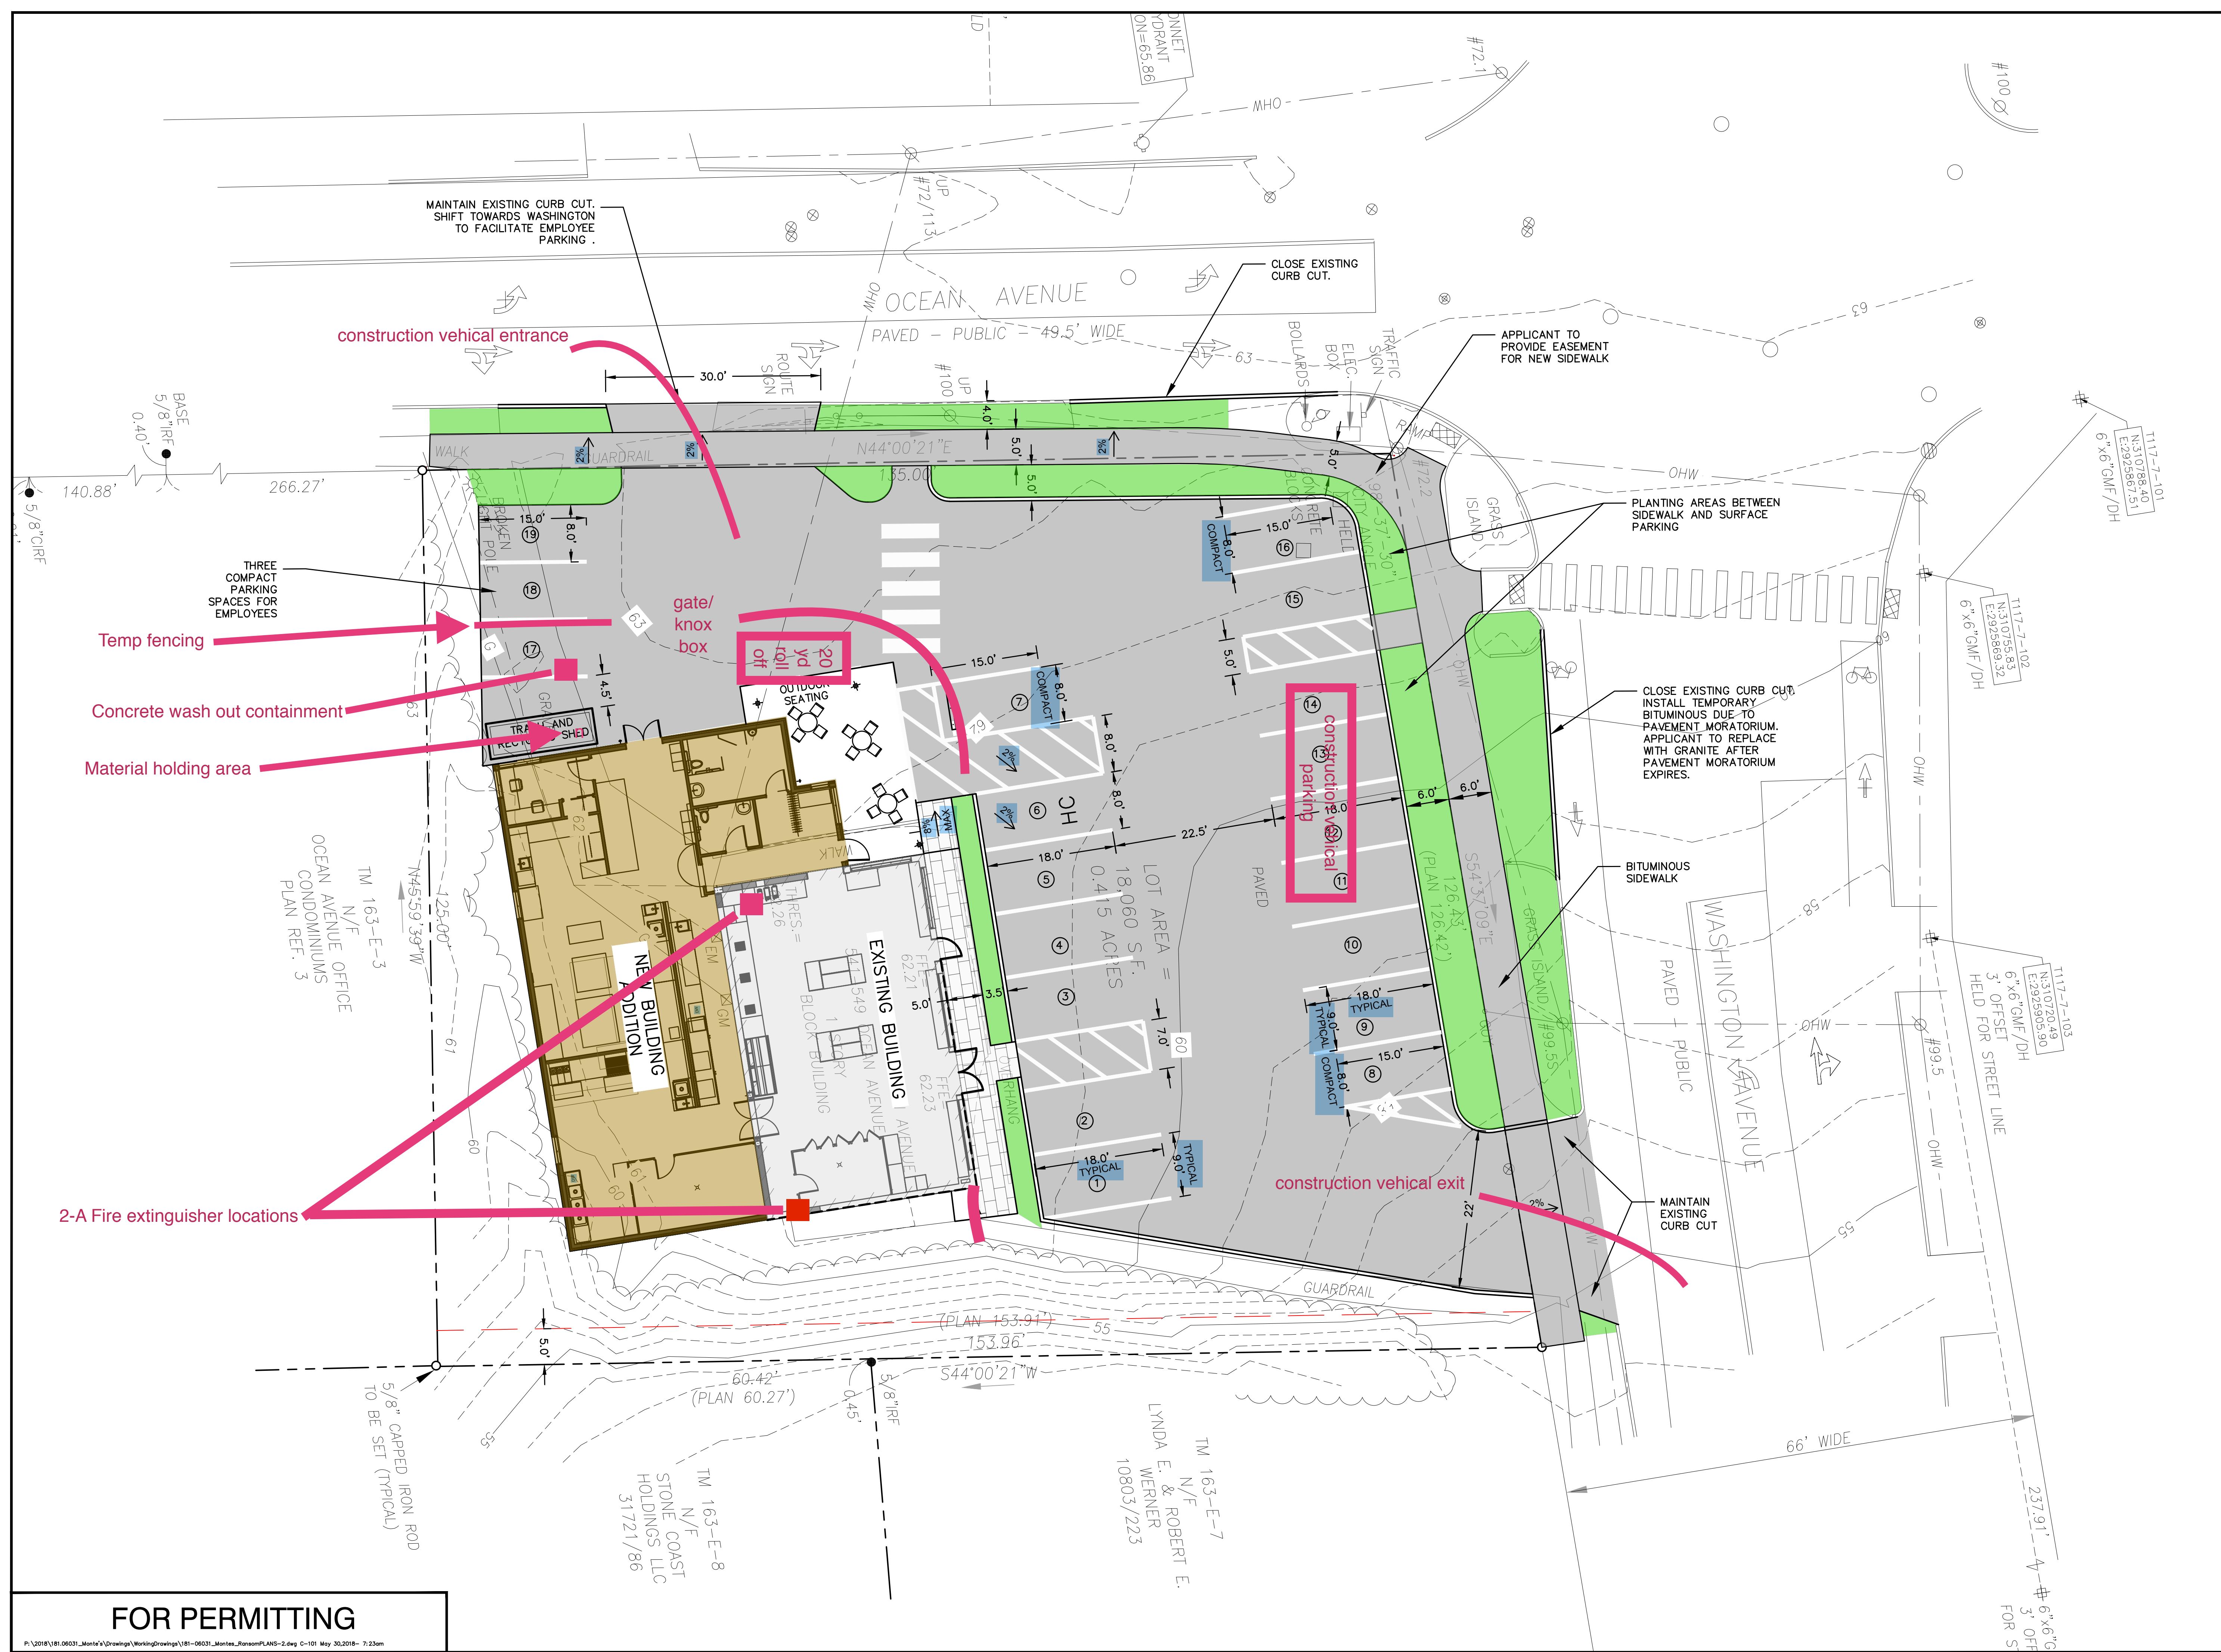

FOR PERMITTING

P:\2018\181.06157_Monte's\Drawings\Working\Drawings\181-06157_Monte's_Ransom\PLANS-2.dwg C-101 May 30,2018 7:23am