


PROJECT NAME
NEW 2-BEDROOM UNIT
28 MORSE STREET
 PORTLAND MAINE


FOUNDATION PLAN
 FLOOR PLANS
 FRAMING PLANS

DATE: 27 APRIL 2015
 SCALE: 1/4" = 1'-0"
 DRAWN BY: M.F.H.
 JOB NO.: 130435


A.1
 COPYRIGHT REPRODUCTION OR REVISE OF THIS DOCUMENT WITHOUT WRITTEN PERMISSION FROM GRANT HAYS ASSOCIATES IS PROHIBITED.

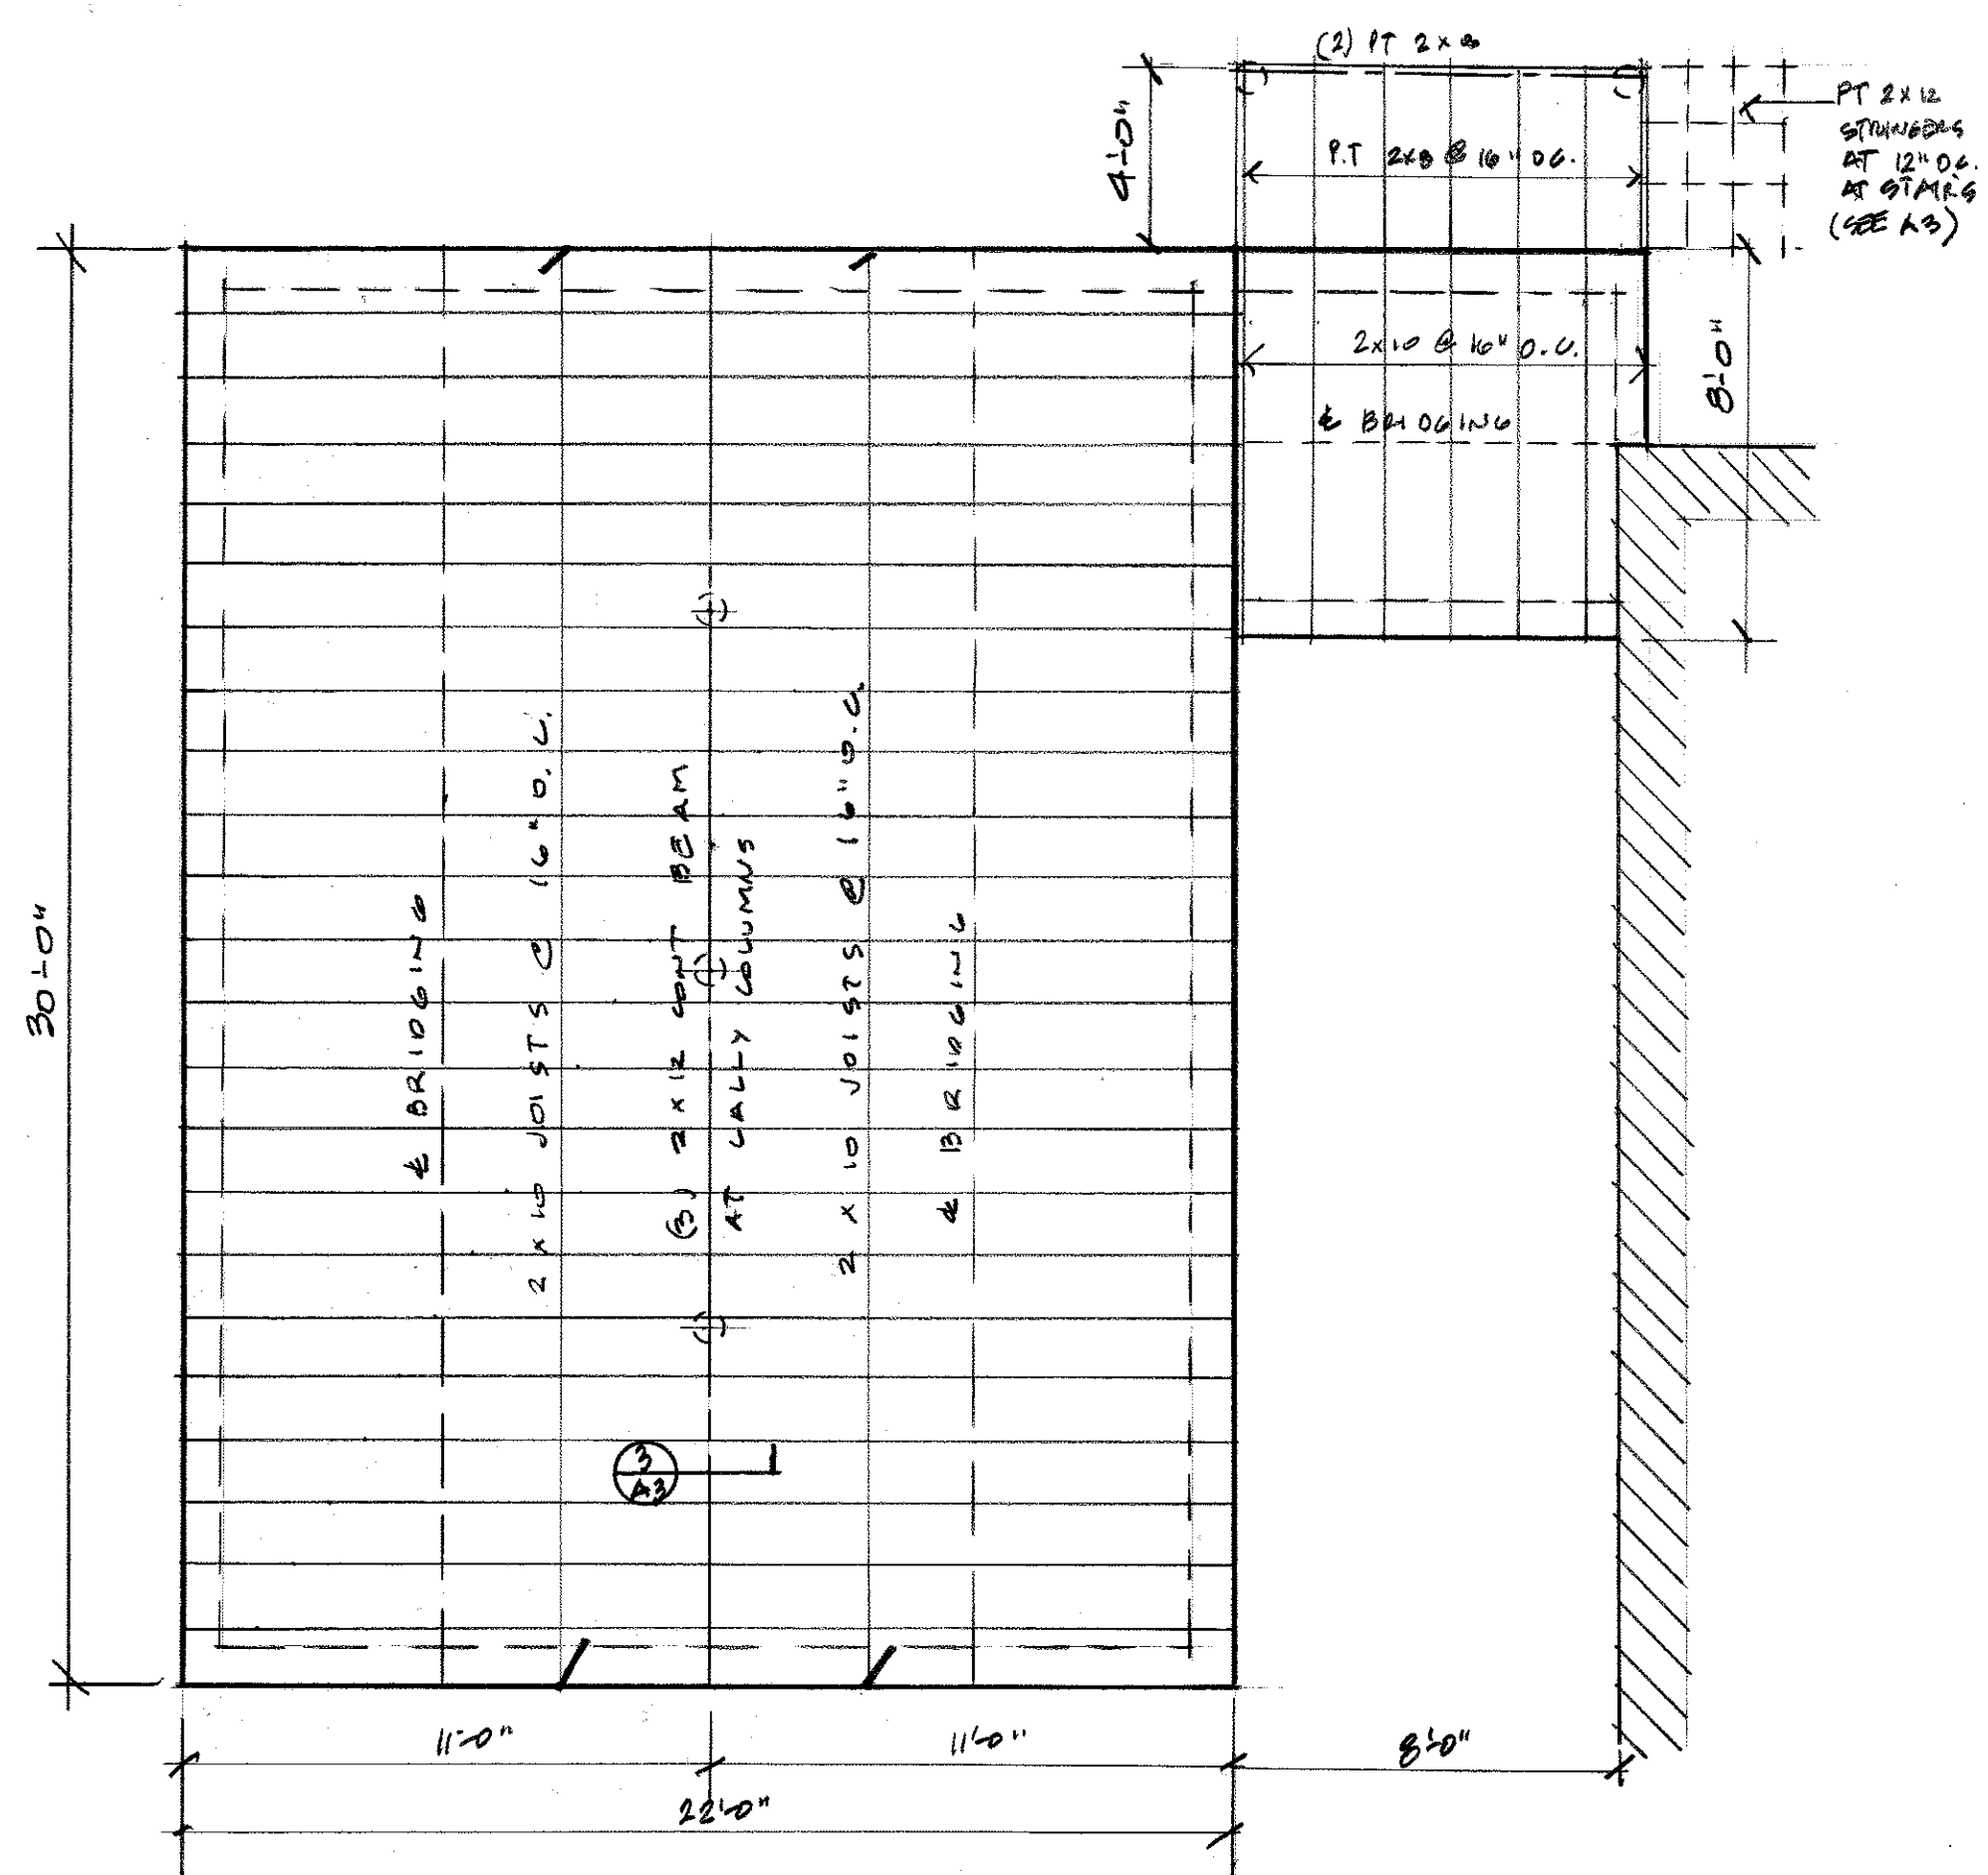


FIRST FLOOR FRAMING PLAN
 1/4" = 1'-0"

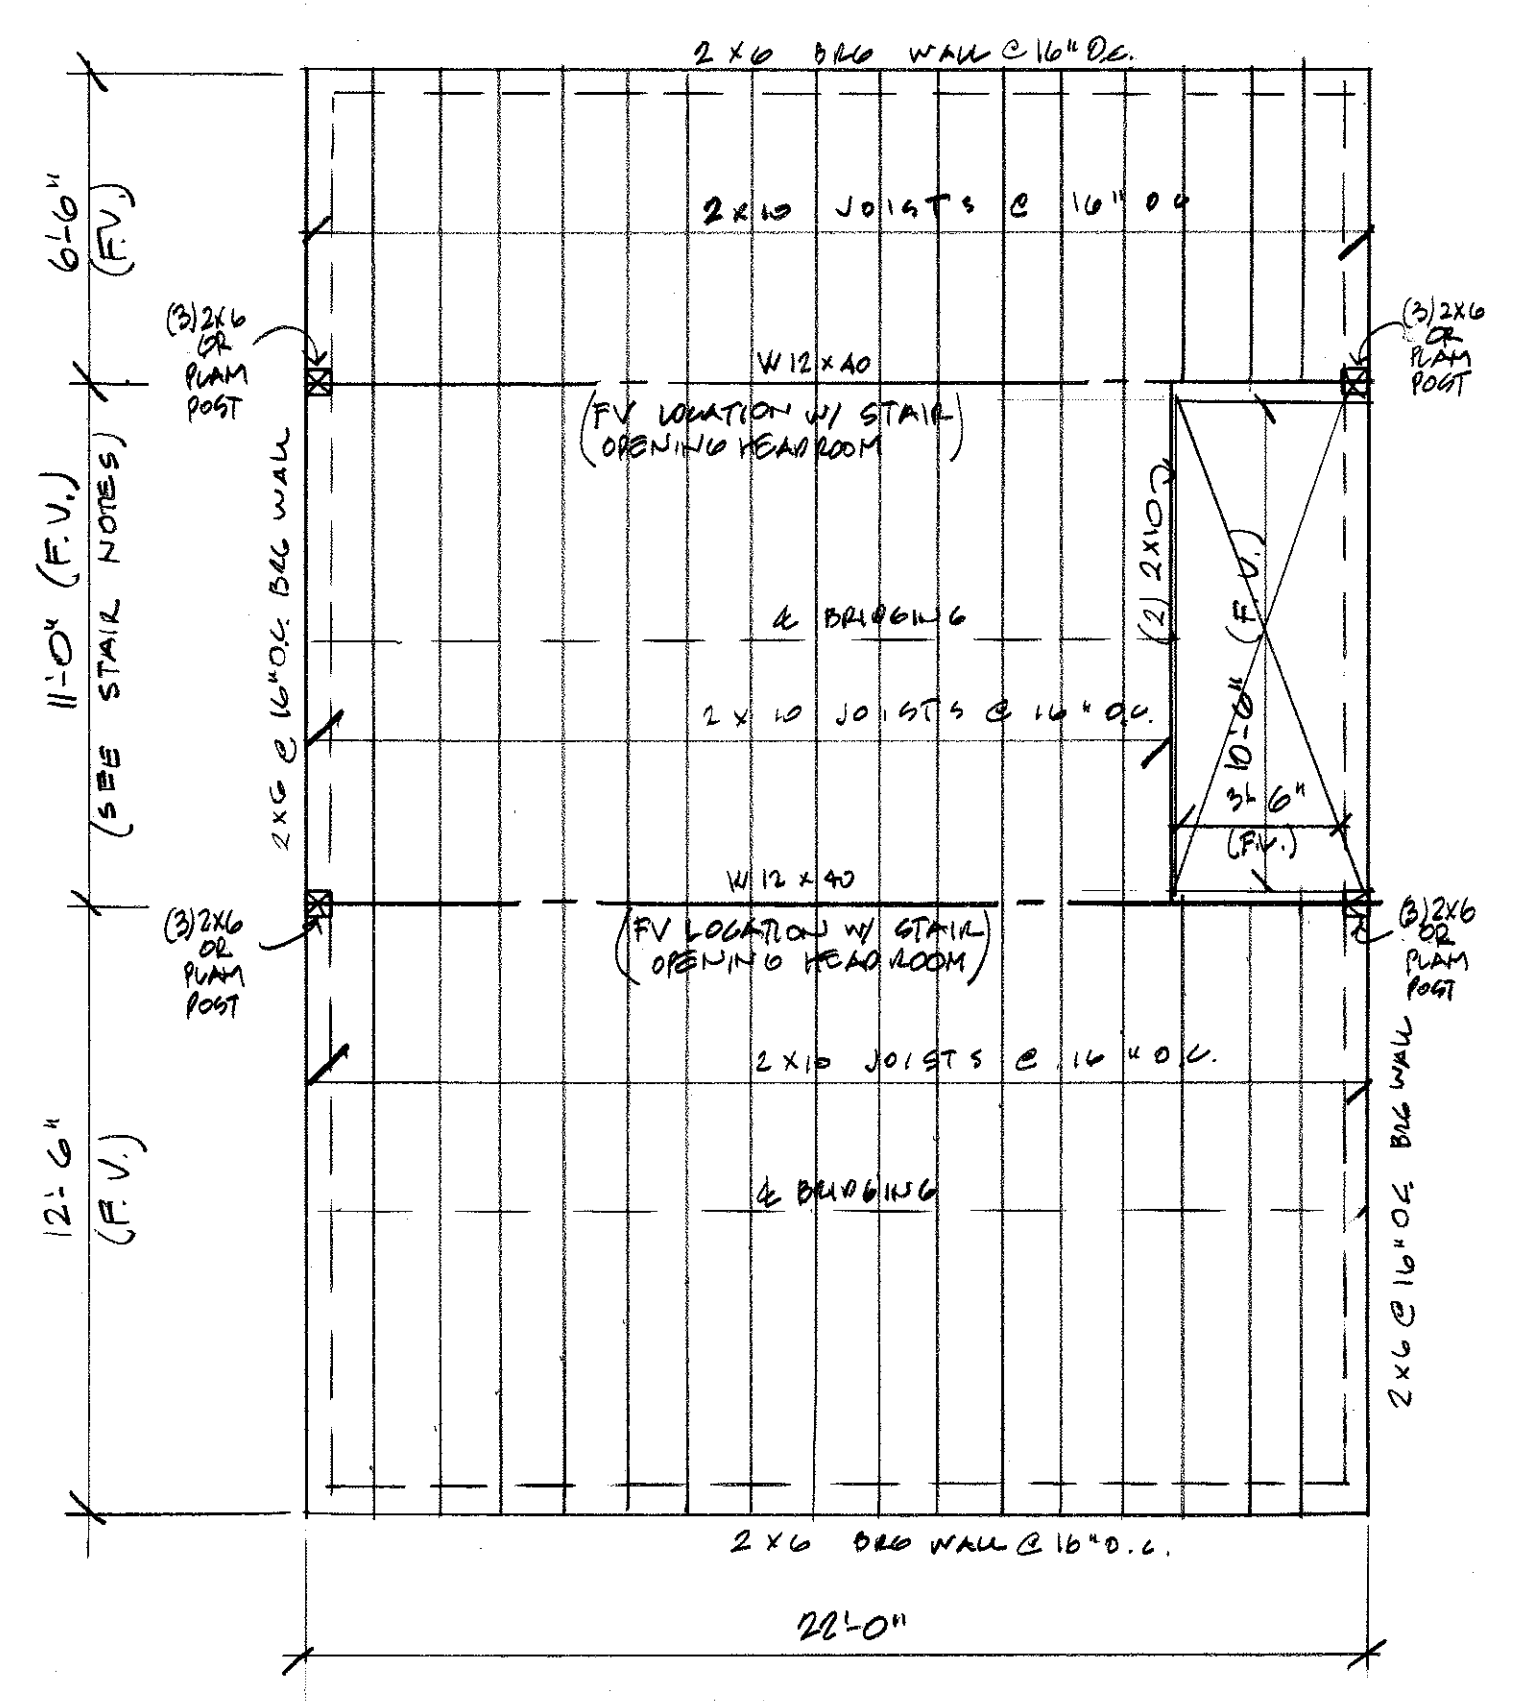

SECOND FLOOR FRAMING PLAN
 1/4" = 1'-0"

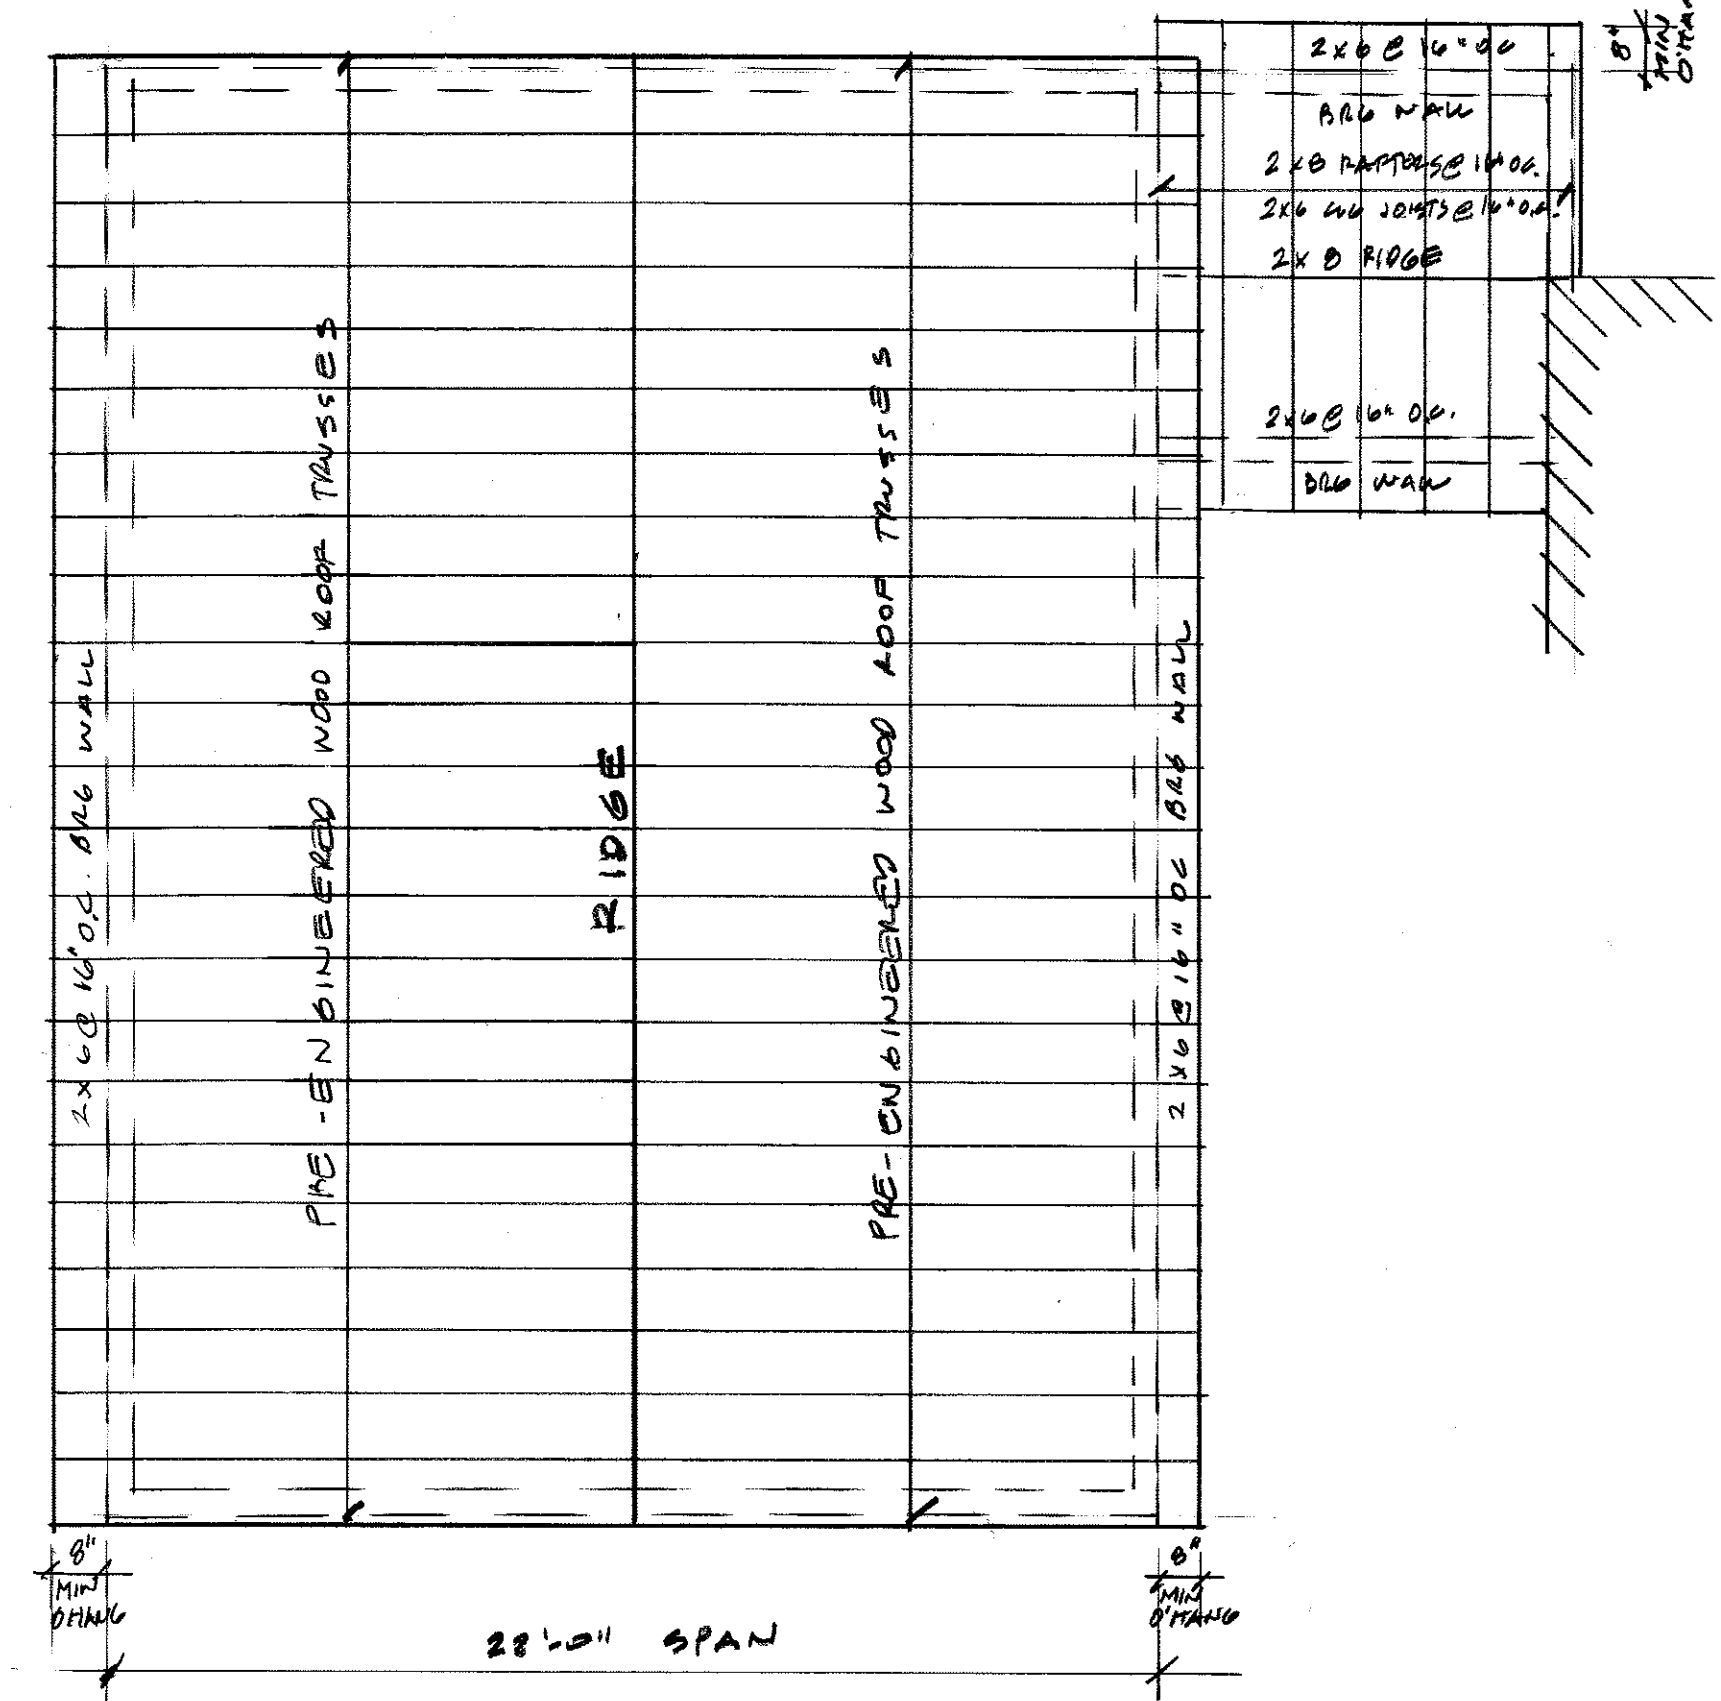


ROOF FRAMING PLAN
 1/4" = 1'-0"

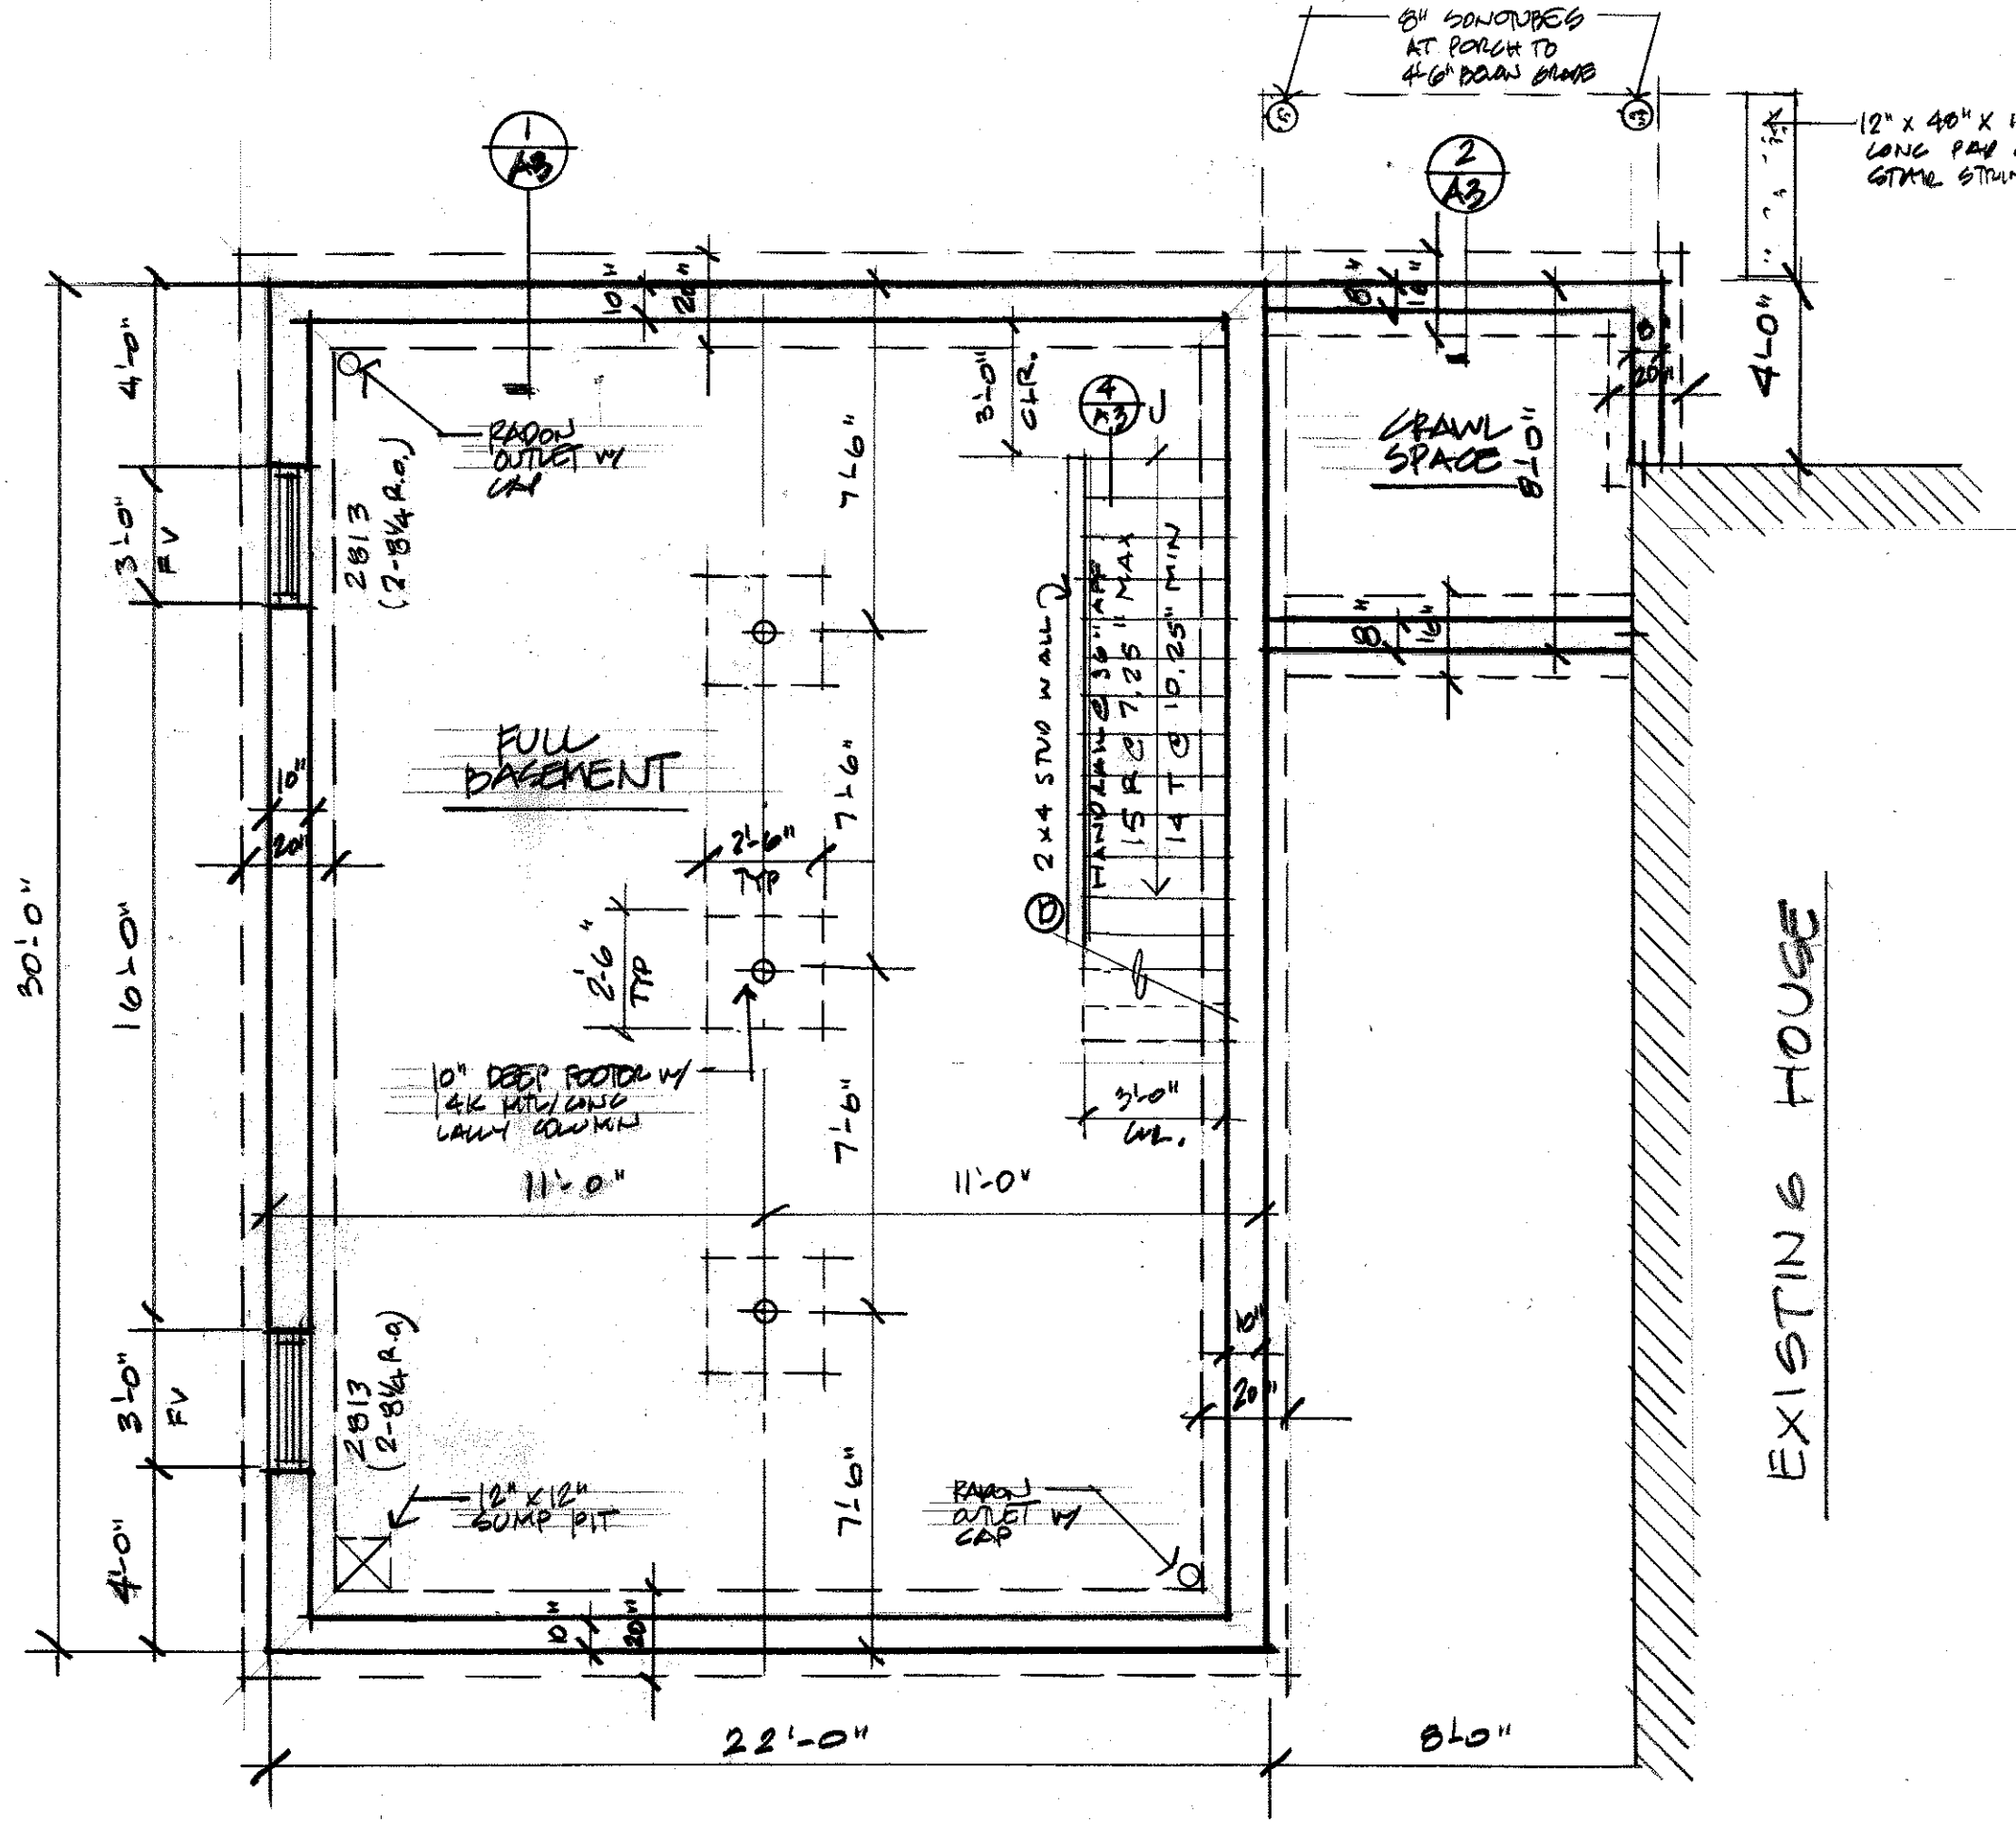


FOUNDATION PLAN
 1/4" = 1'-0"

⊙ = CARBON MONOXIDE/SMOKE DETECTOR COMBINATION UNIT - INTERCONNECTED (SOUND BASE/EXIT LIGHT)

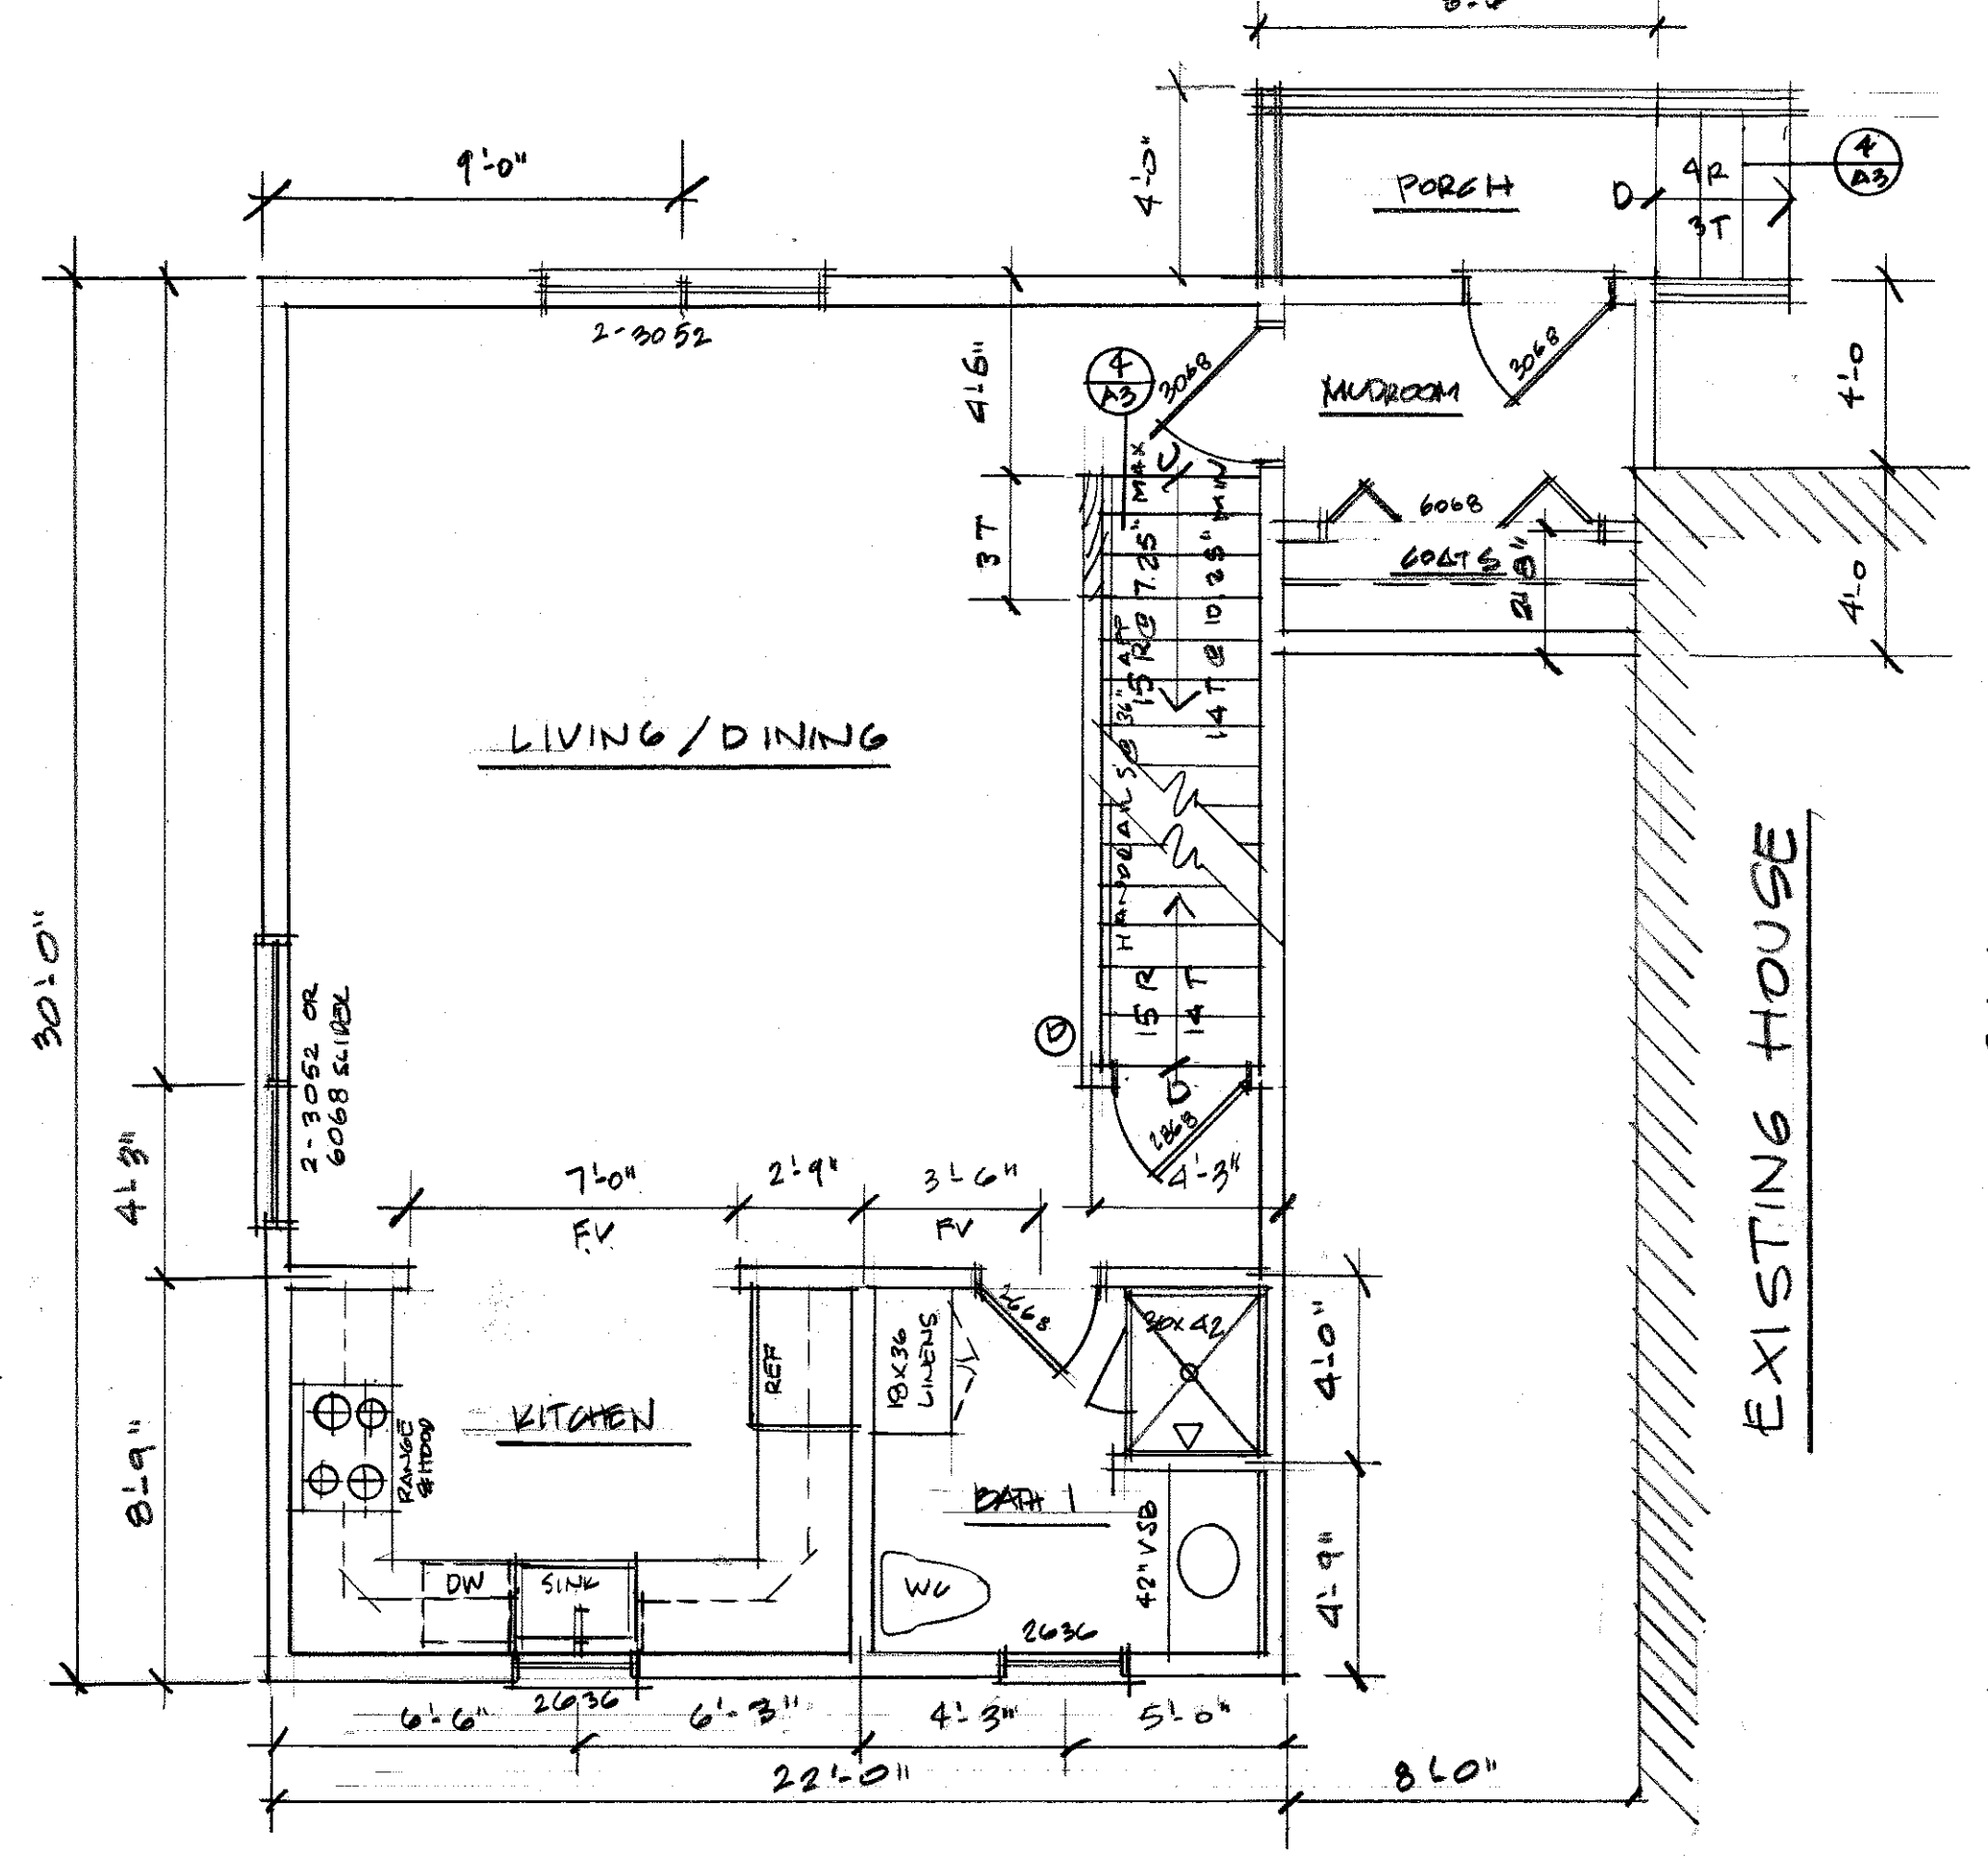

FIRST FLOOR PLAN
 1/4" = 1'-0"

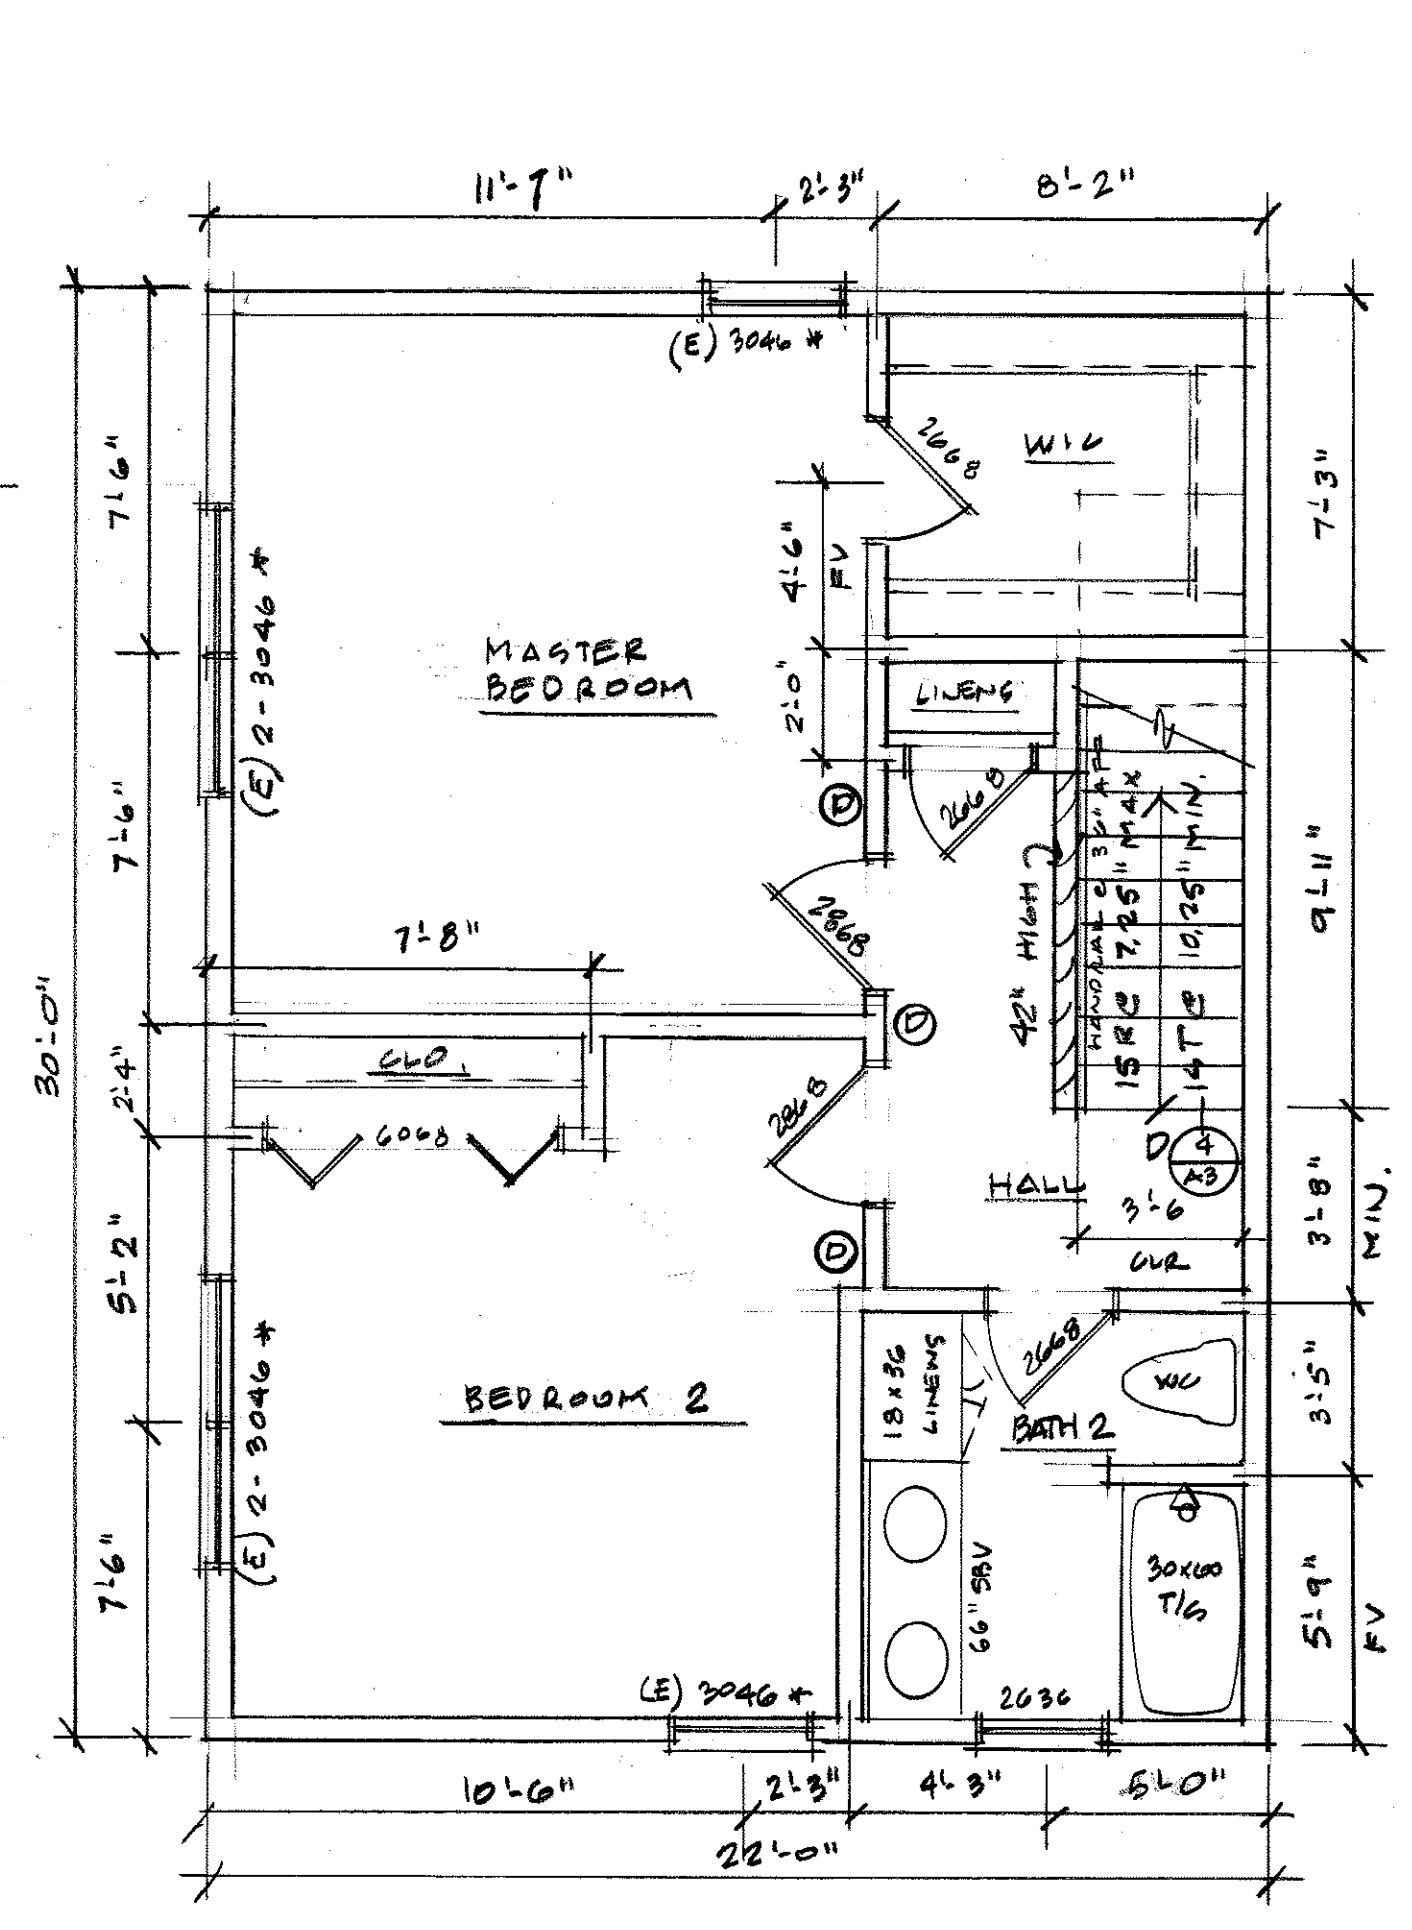

SECOND FLOOR PLAN
 1/4" = 1'-0"
 * BRASS ON WINDOW (E)