
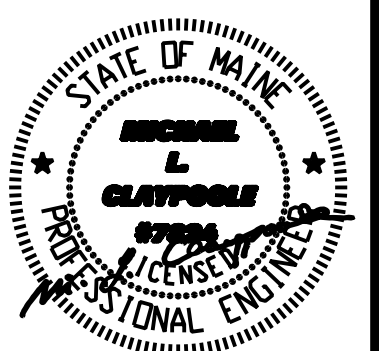


GENERAL NOTES:

REVISIONS:

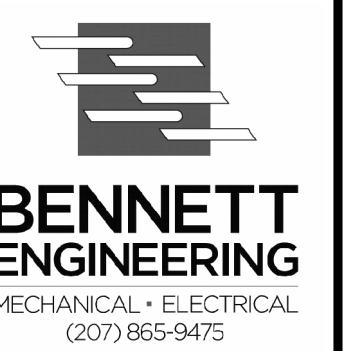

5 Fundy Road Phone: 207-781-3344
 Falmouth, Maine 04105 Fax: 207-699-5564
 Online @ foresidearchitects.com

Project Status:
 Bid Set

Project Number:
 SR0712

Project Title:
Seaside Rehab & Healthcare Center
 850 Baxter Blvd
 Portland, ME



Drawing Name:
 SITE ELECTRICAL PLAN

Scale:
 1"=20'-0"

Date:
 10/29/12

SHEET

E-1

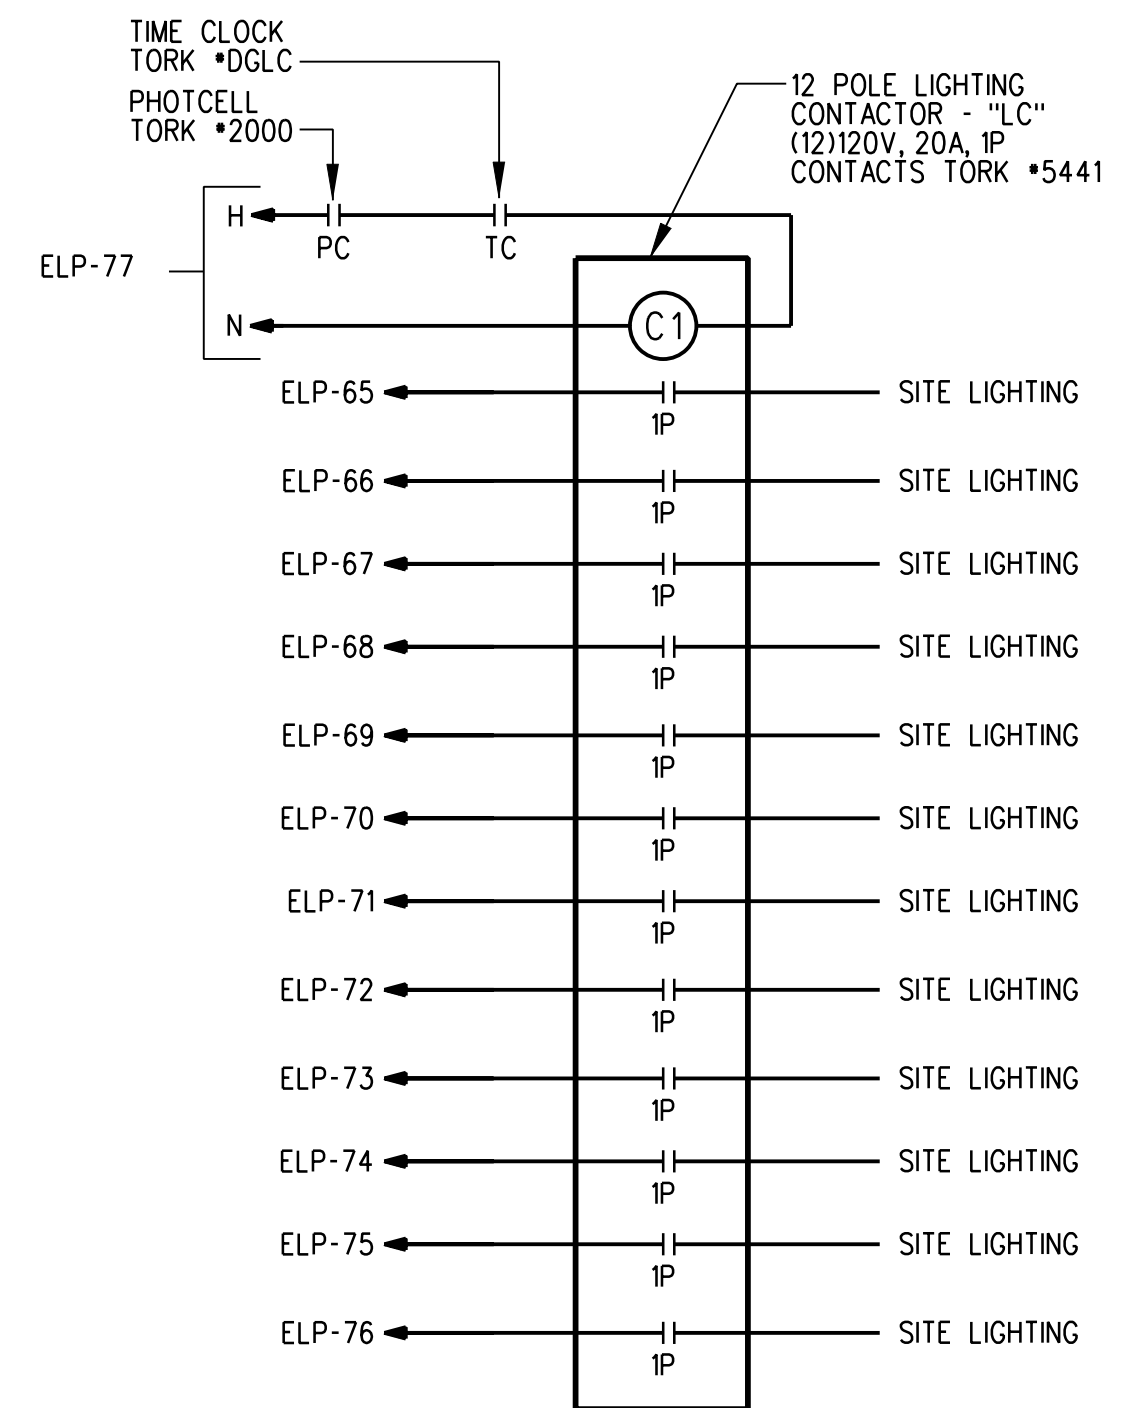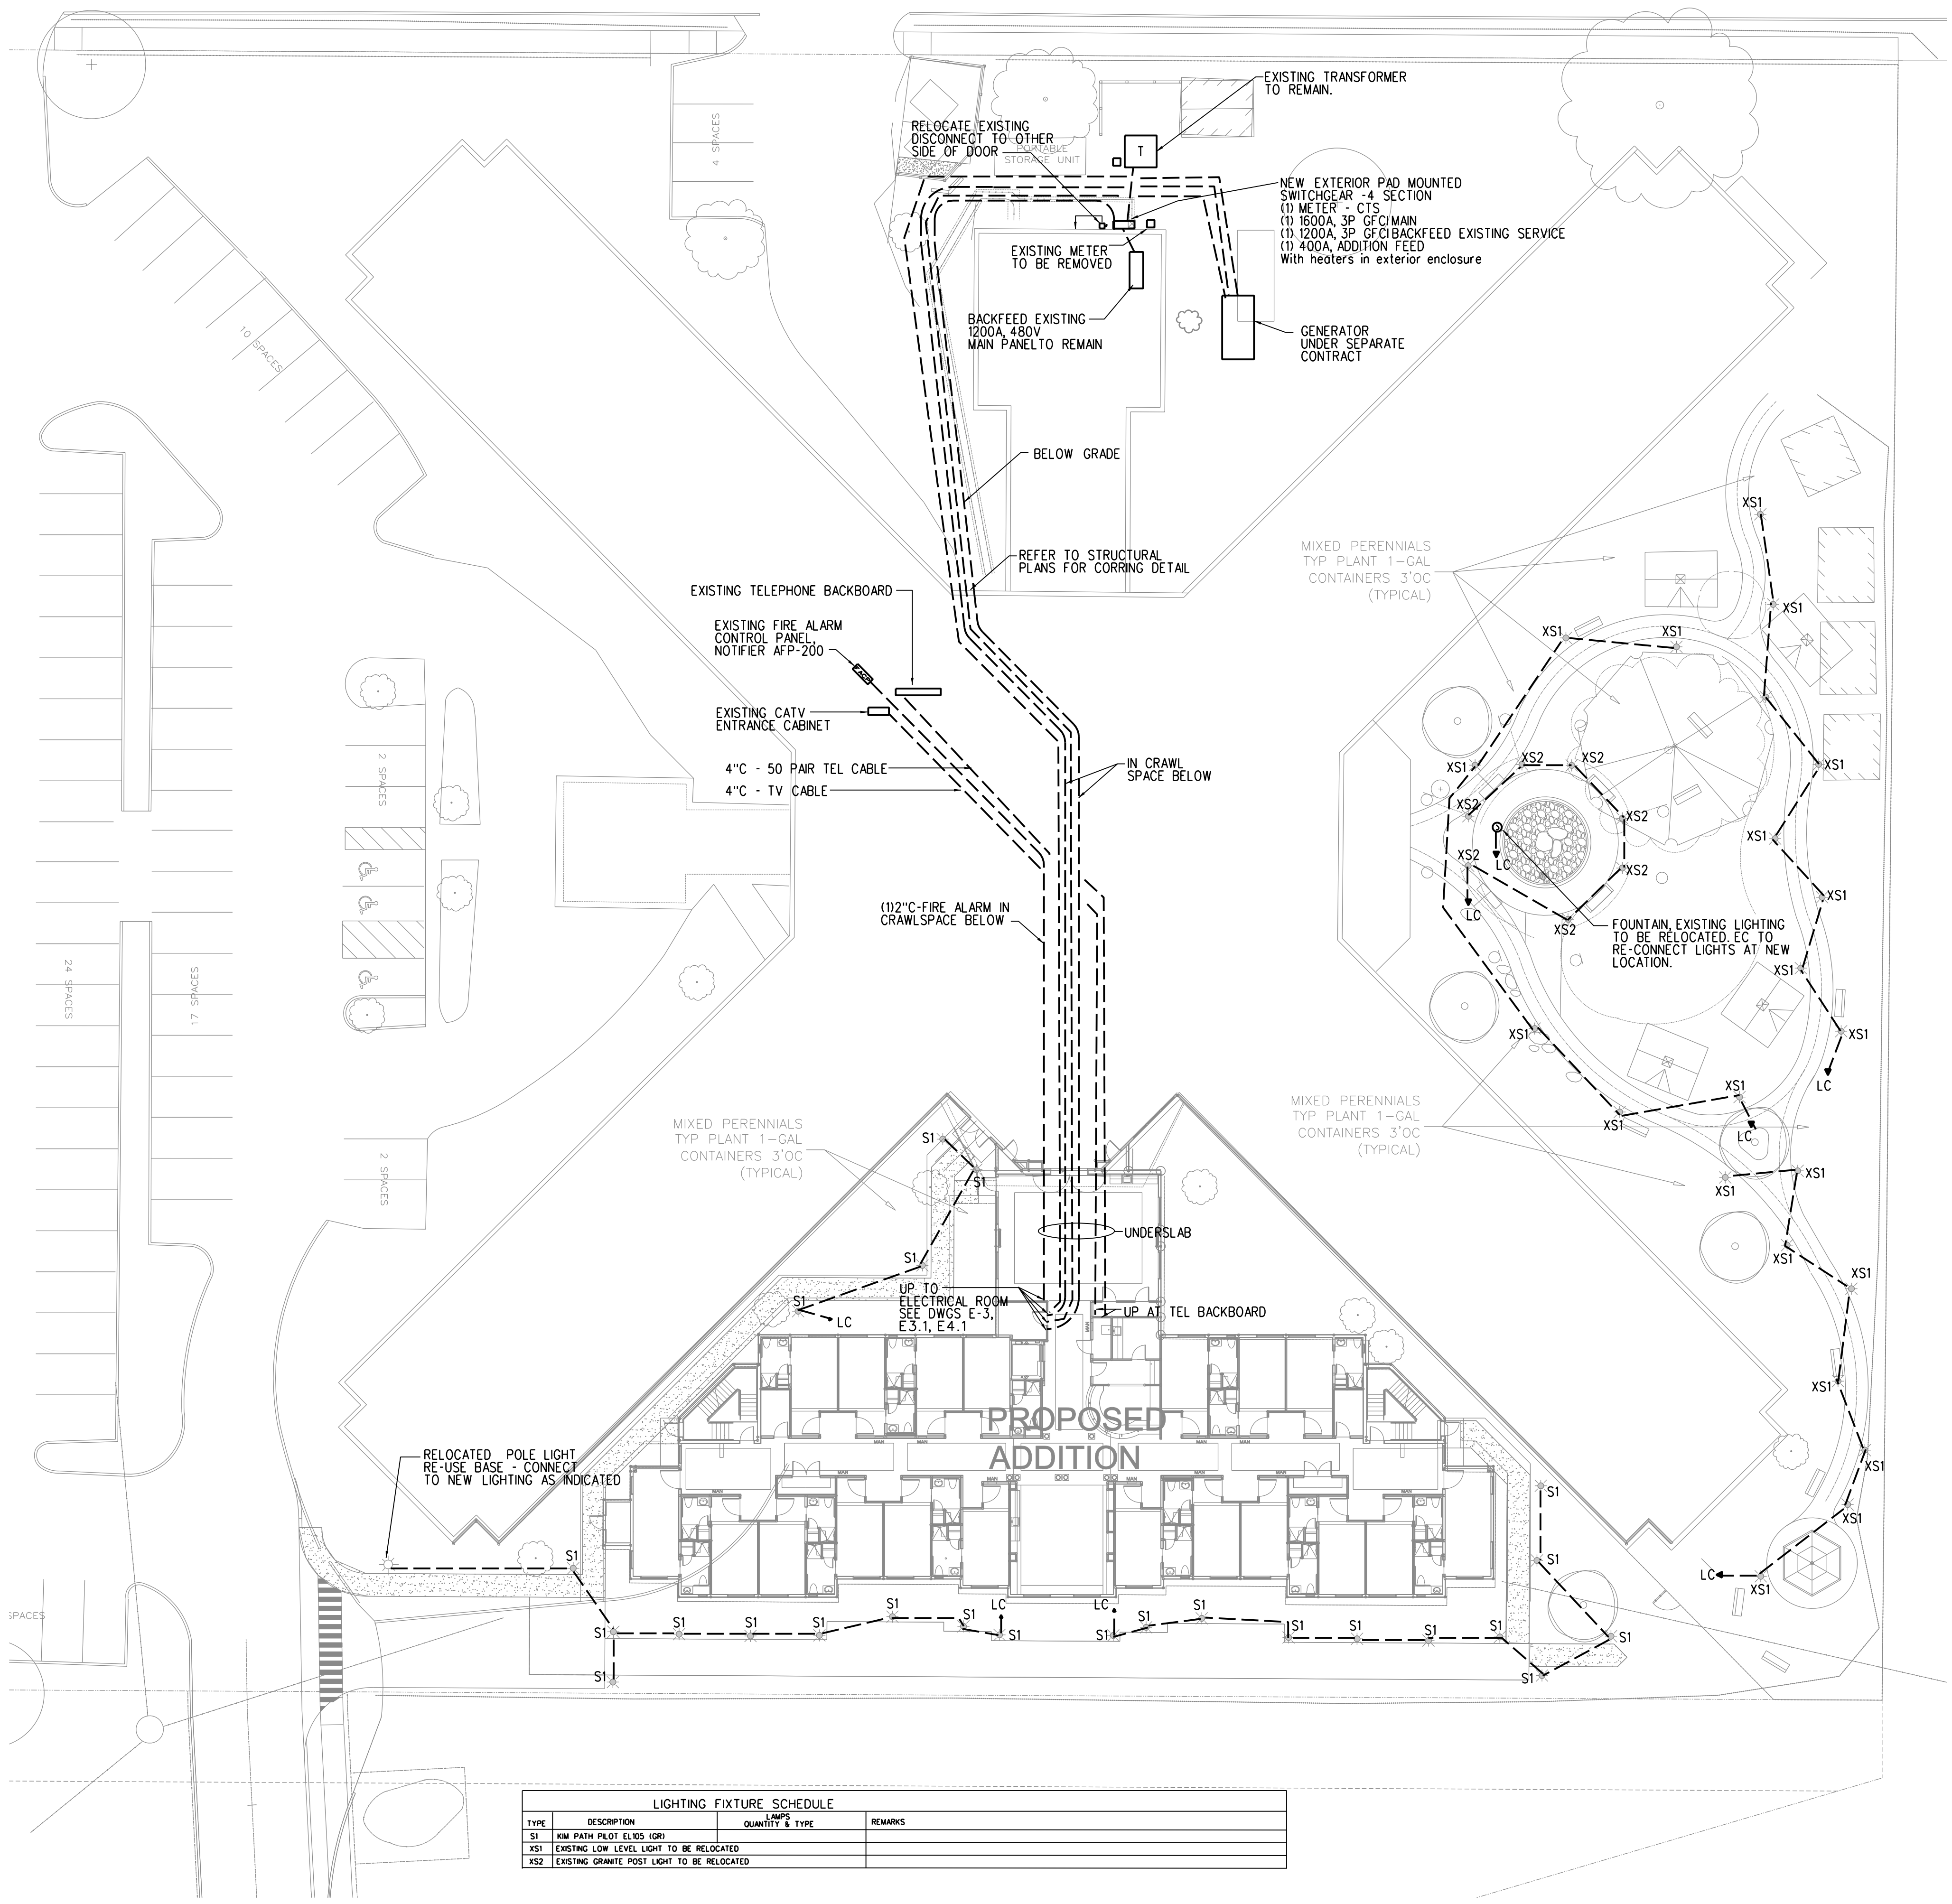

LIGHTING CONTACTOR "LC" DETAIL (EXTERIOR LIGHTING)
 SCALE: NONE

TYPE	DESCRIPTION	QUANTITY & TYPE	REMARKS
S1	MIN PATH PILOT ELVOS (GR)		
XS1	EXISTING LOW LEVEL LIGHT TO BE RELOCATED		
XS2	EXISTING GRANITE POST LIGHT TO BE RELOCATED		