


GENERAL NOTES:

REVISIONS:

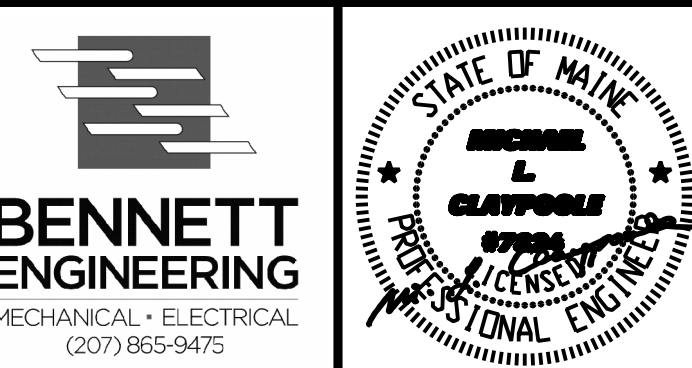

5 Fundy Road Phone: 207-781-3344
 Falmouth, Maine 04105 Fax: 207-699-5564
 Online @ foresidearchitects.com

Project Status:
 Bid Set

Project Number:
 SR0712

Project Title:
 Seaside Rehab & Healthcare Center
 850 Baxter Blvd
 Portland, ME

Drawing Name:
 SECOND FLOOR FLOOR LIGHTING PLAN

Scale:
 1/8"=1'-0"

Date:
 10/29/12

SHEET
E-2.1



ELECTRICAL NOTES

1 REFER TO TYPICAL UNIT PLAN.

NOTE

1. FOR ANY FIXTURE ON A MOTION SENSOR AND AN EMERGENCY CIRCUIT, PROVIDE BODINE GTD-20 RELAY TO "FORCE" FIXTURES ON DURING GENERATOR OPERATION. CONNECT AHEAD OF ANY SWITCHING.

ALL EXIT LIGHTS TO BE WIRED TO PANEL ELP