
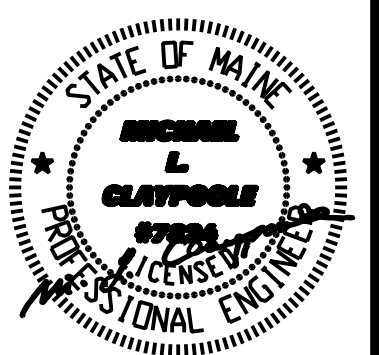


GENERAL NOTES:

REVISIONS:

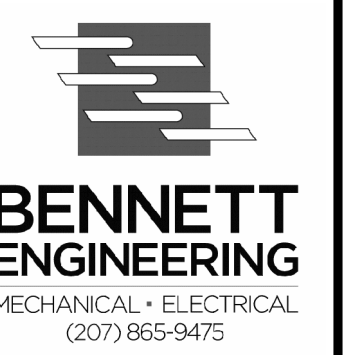

5 Fundy Road Phone: 207-781-3344
 Falmouth, Maine 04105 Fax: 207-699-5564
 Online @ foresidearchitects.com

Project Status:
 Bid Set

Project Number:
 SR0712


Project Title:
 Seaside Rehab & Healthcare Center
 850 Baxter Blvd
 Portland, ME

Drawing Name:
 ROOF POWER PLAN

Scale:
 1/8"=1'-0"

Date:
 10/29/12

SHEET
E-3.2

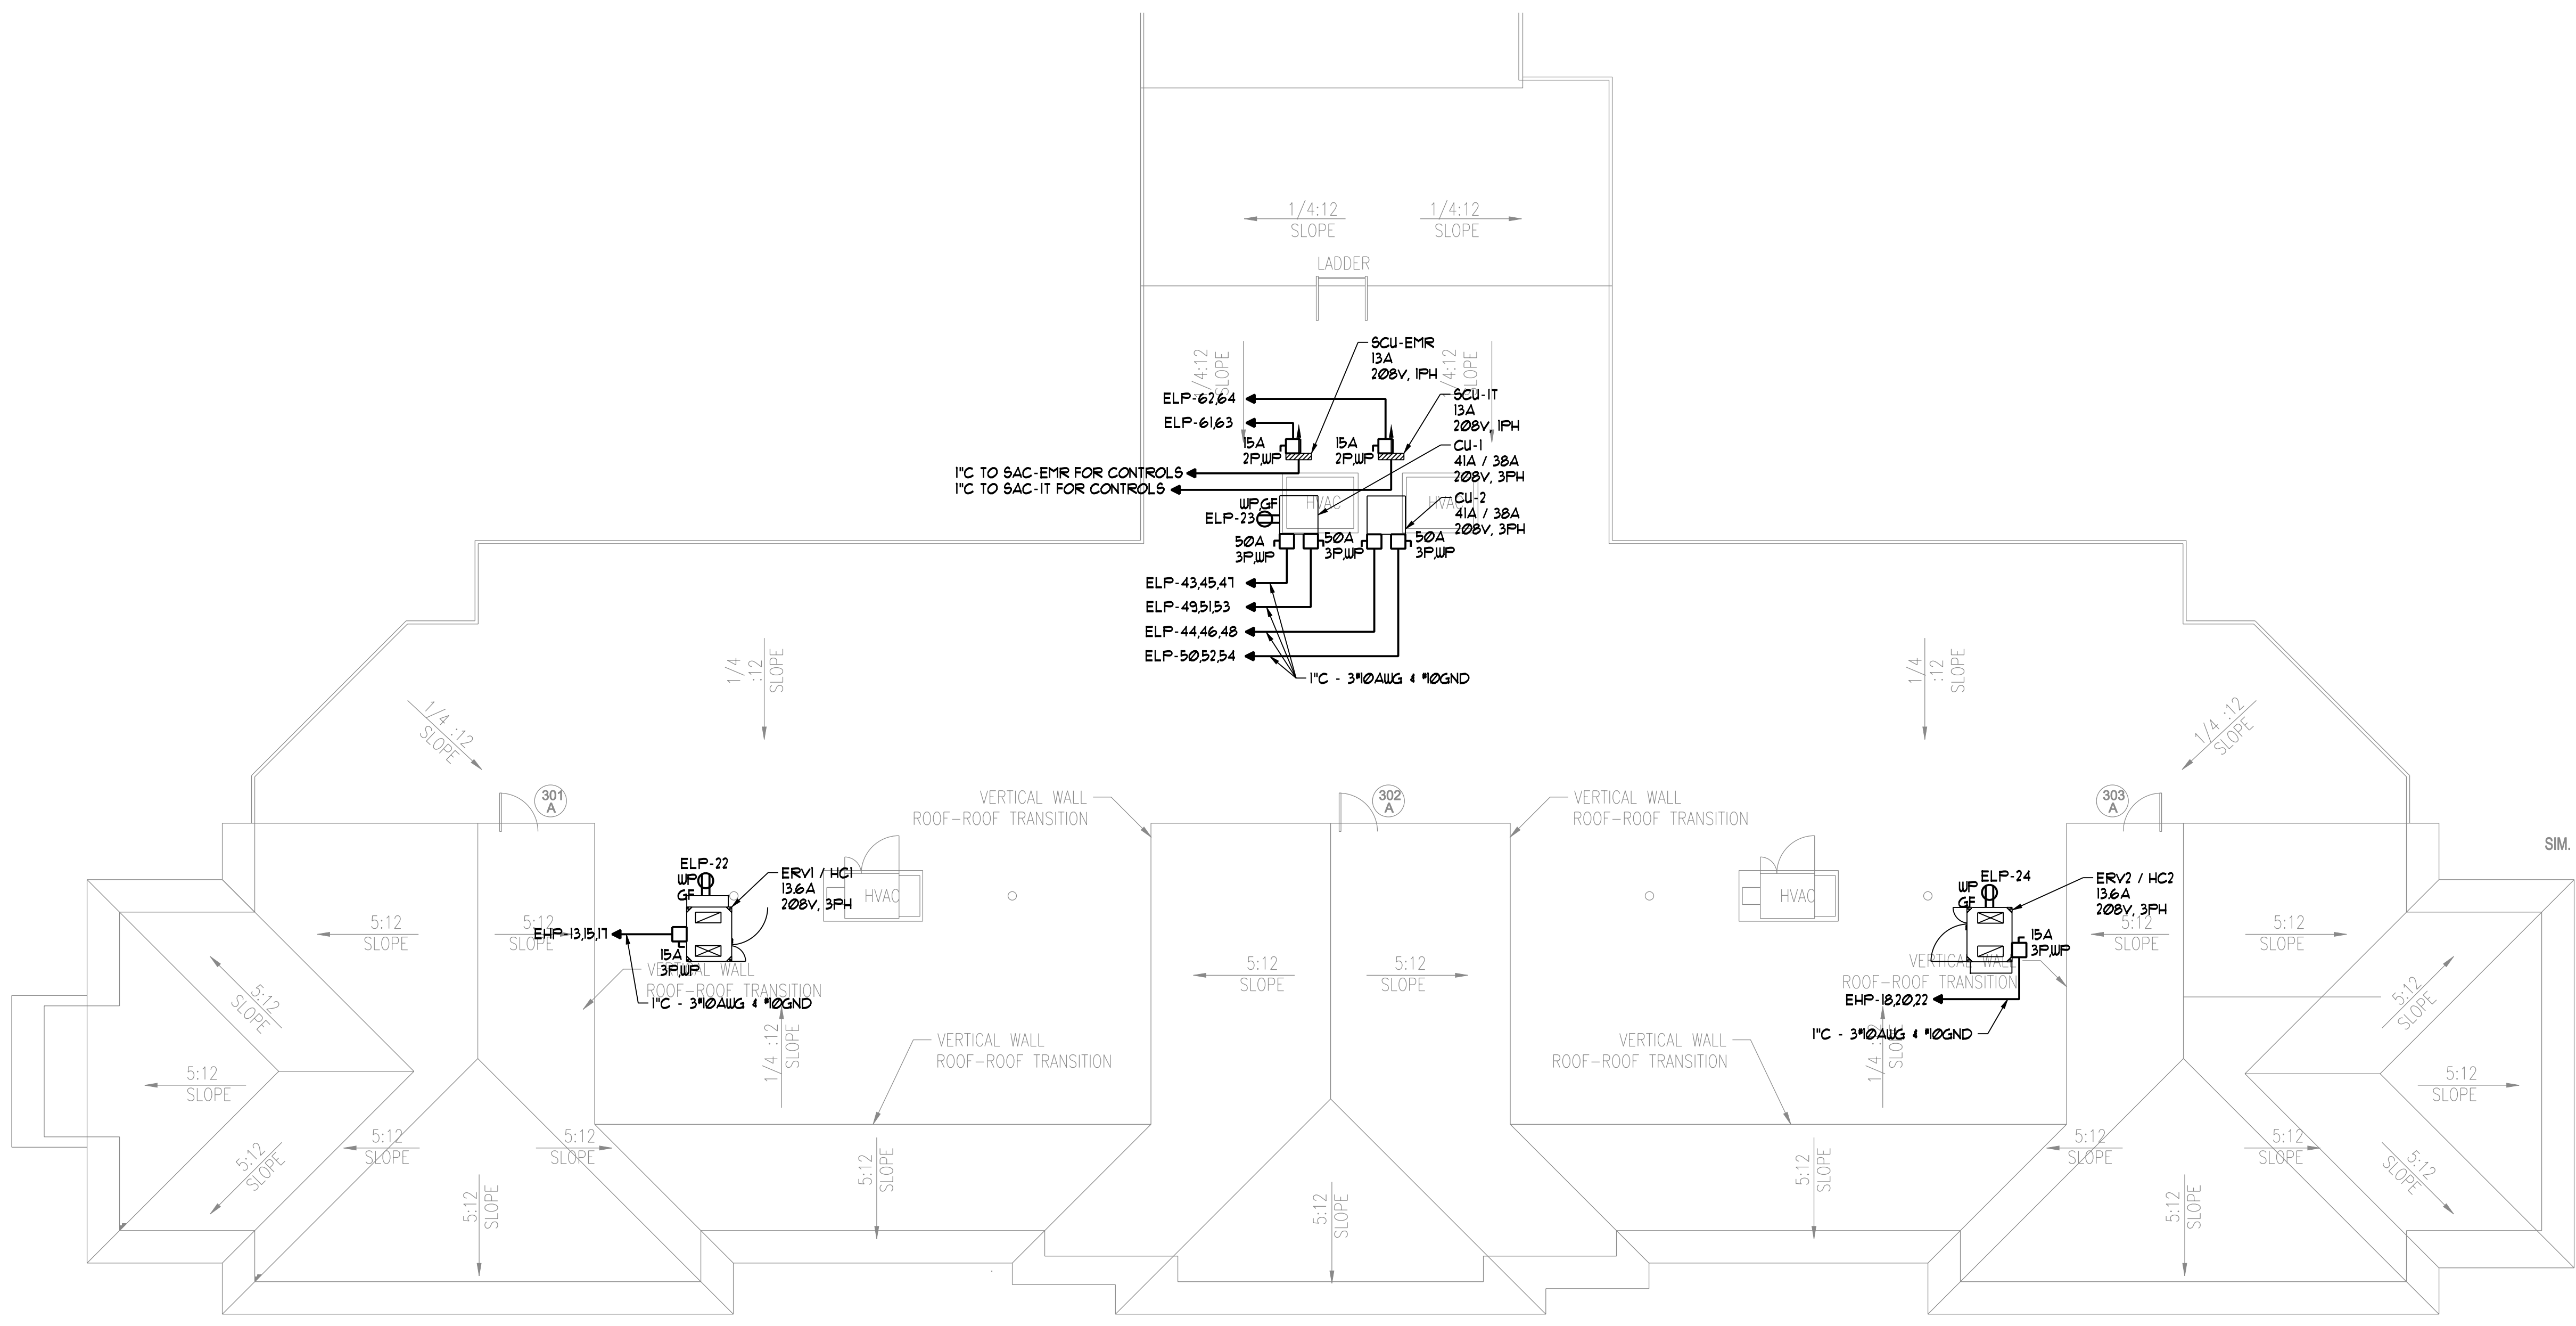

SIM.