



GENERAL NOTES:


REVISIONS:

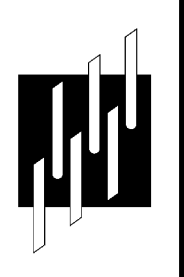

**BENNETT
ENGINEERING**
MECHANICAL • ELECTRICAL
(207) 855-9475

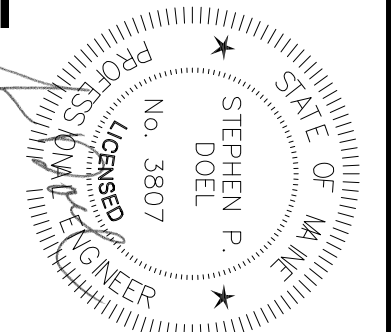

STATE OF MAINE
 STEPHEN P. DOHERTY
 No. 3807
 LICENSED PROFESSIONAL ENGINEER

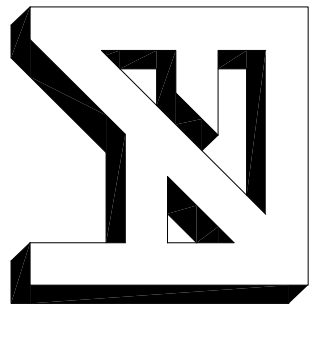

**FORESIDE
ARCHITECTS**
LLC

5 Fundy Road
 Falmouth, Maine 04105
 Phone: 207-781-3344
 Fax: 207-699-5564
 Online @ foresidearchitects.com


Project Title:
Seaside Rehab & Healthcare Center
 850 Baxter Blvd
 Portland, ME

Drawing Name:
Plumbing Existing Building Floor Plan

Scale:
 3/32"=1'-0"

Date:
 10/29/12

SHEET
P1.3

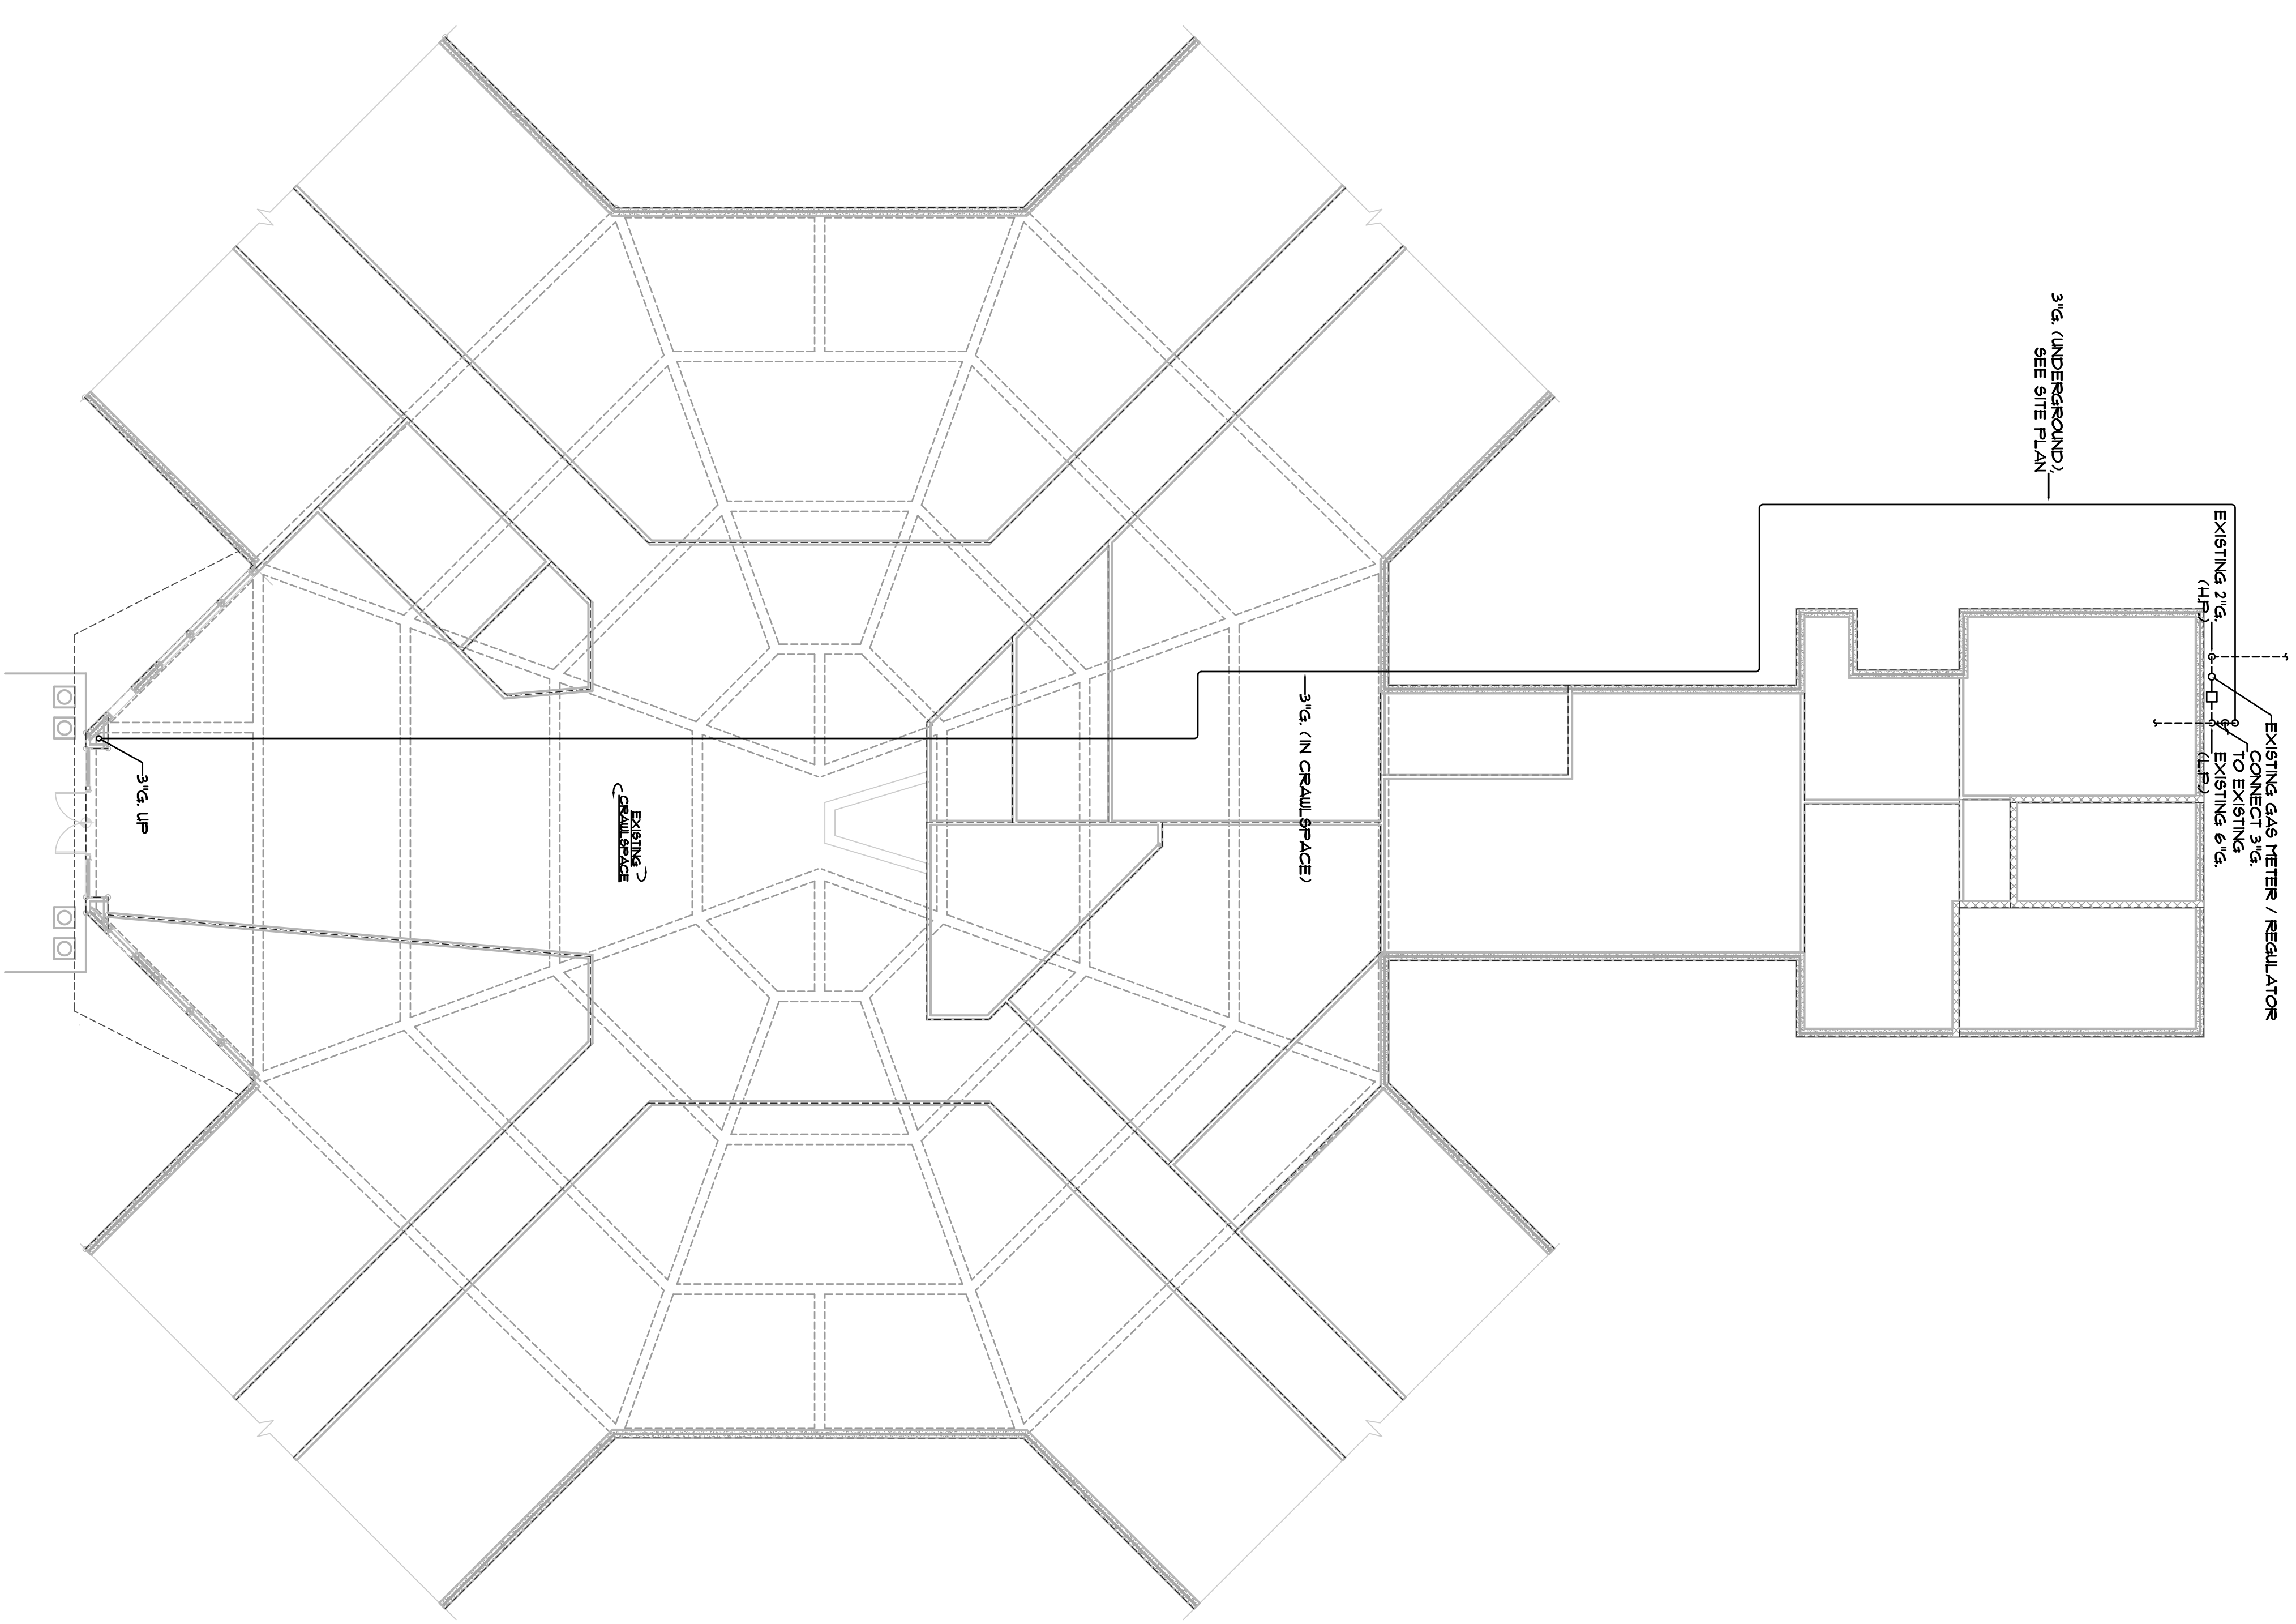

3/4" (UNDERGROUND)
 SEE SITE PLAN

EXISTING GAS METER / REGULATOR
 CONNECT TO EXISTING
 EXISTING 6" G.
 (H.P.)

3/4" (IN CRAWL SPACE)

EXISTING
 GAS METER

3/4" I.P.