


GENERAL NOTES:

REVISIONS:

1. Construction Set January 2, 2013.
1. Waterline Revisions April 11, 2013.

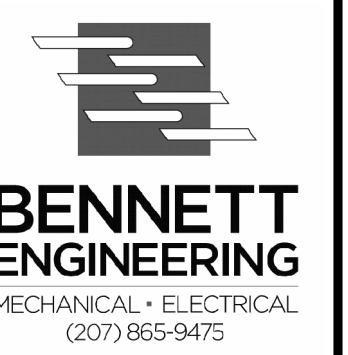

5 Fundy Road Phone: 207-781-3344
 Falmouth, Maine 04105 Fax: 207-699-5564
 Online @ foresidearchitects.com

Project Status:
 Bid Set

Project Number:
 SR0712

Project Title:
 Seaside Rehab & Healthcare Center
 850 Baxter Blvd
 Portland, ME

Drawing Name:
 FIRE ALARM PERMIT SUBMISSION


Scale:
 1/8"=1'-0"

Date:
 04/17/13

SHEET

FA-6

LEGEND	
MOUNTING HEIGHT	
48 INCHES	PS PULL STATION
	S SMOKE DETECTOR
	CO CARBON MONOXIDE DETECTOR
	H HEAT DETECTOR RATE OF RISE
	RT REMOTE TEST/INDICATOR
	DS ^S DUCT SMOKE DETECTOR W/ FSP-851R HEAD
80 INCHES	VO VISUAL ONLY
80 INCHES	AV AUDIO / VISUAL
	FMM MONITOR MODULE
	FRM RELAY MODULE
	STS SPRINKLER TAMPER
	SFS SPRINKLER FLOW
	DH MAGNETIC DOOR HOLD

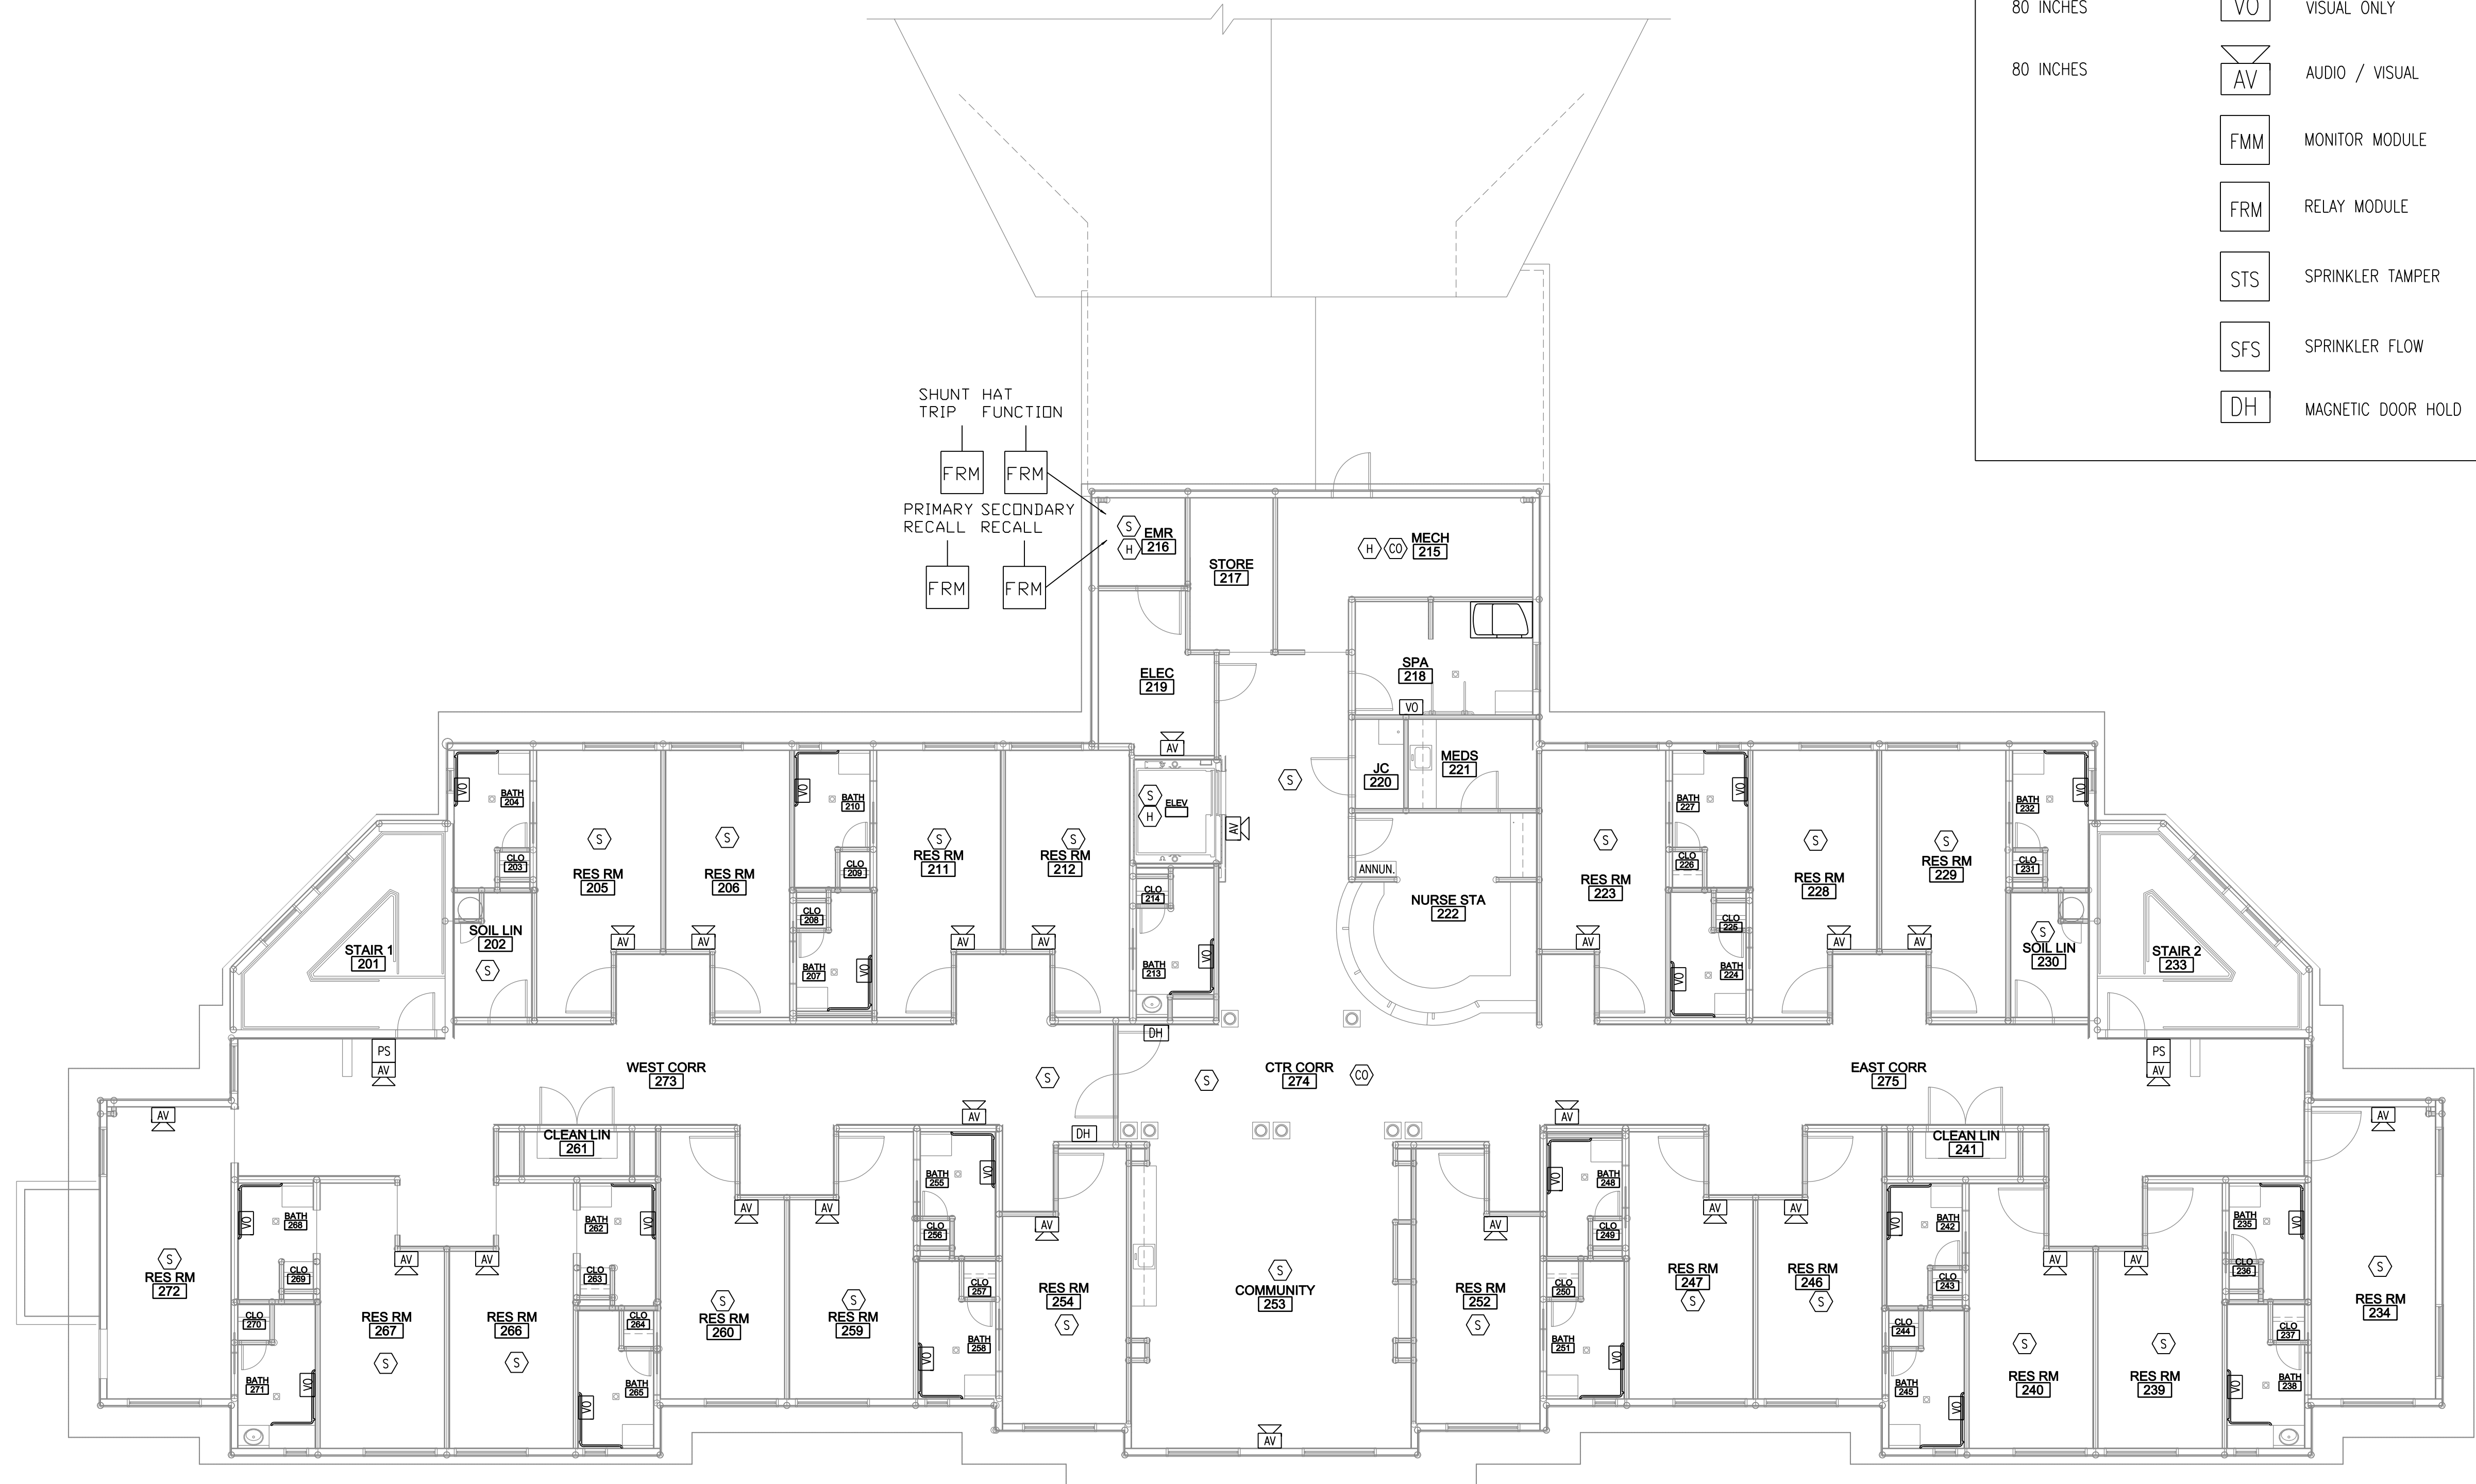

2ND FLOOR FIRE ALARM PLAN
 SCALE: 1/8" = 1'-0"