




LIGHTING SCHEDULE

Symbol	Component Description
	6" diameter ceiling-mounted LED light fixture. HALO H7501CPD010 ML7128
	14" diam. ceiling-mounted SolarTube w/ integral LED lighting (Alt #1)
	2x2 Recessed LED HALO - 22EN A LD2 34 UNV
	4" diameter ceiling-mounted LED light fixture. HALO H457ICAT1E ELG406
	Re-use Existing Ceiling Grid Mount Fluorescent Light Fixture
	Ceiling Mounted 1' x 4' fluorescent light fixture
	Ceiling-mounted video projector & platform
	Ceiling-mounted recessed architectural cove fixture
	Perimeter direct wall wash, recessed 2 bulb T5 cove fixture
	Wall Mounted, continuous up/ down T5 lighting fixture, number denotes length
	Wall Mounted, 4' corridor light, mount horizontal above door
	Under cabinet LED strip lighting
	Emergency light. E-Denotes Existing, R-Relocate, N-New (Mach Exist)
	LED Exit Sign. E-Denotes Existing, R-Relocate, N-New (Mach Exist)
	Smoke Detector wired to alarm system
	Heat Detector wired to Alarm System
	Audio Speaker- 4 total

NOTES:

1. CM to use this drawing to coordinatenew lighting layout.
2. For more information on lights, switching and electrical circuits see drawing # A102


10 Proposed Reflected Ceiling Plan

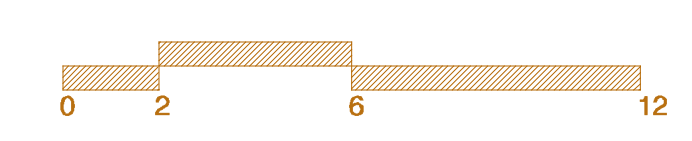

41 edgewood ave
portland, maine 04103
telephone 207 450 0750
e-mail matthewwinch@earthlink.net

PARTITION KEY

- Existing Partitions to Remain
- Proposed Partitions

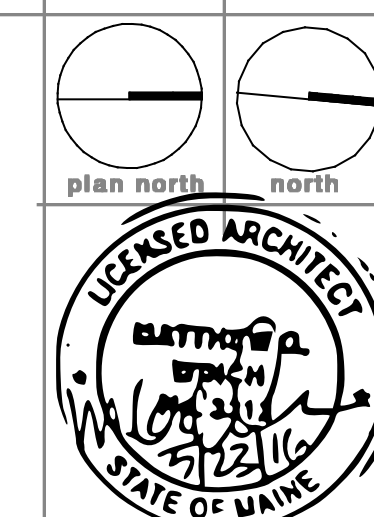

project name

**Spurwink
Office Renovation**

project location

901 Washington Avenue
Portland, Maine 04103

date June 17, 2016
scale 1/4" = 1'-0"
project # 2016-007
drawing title
**Proposed Reflected
Ceiling Plan**
drawing number
A201