


1 FIRST FLOOR RCP

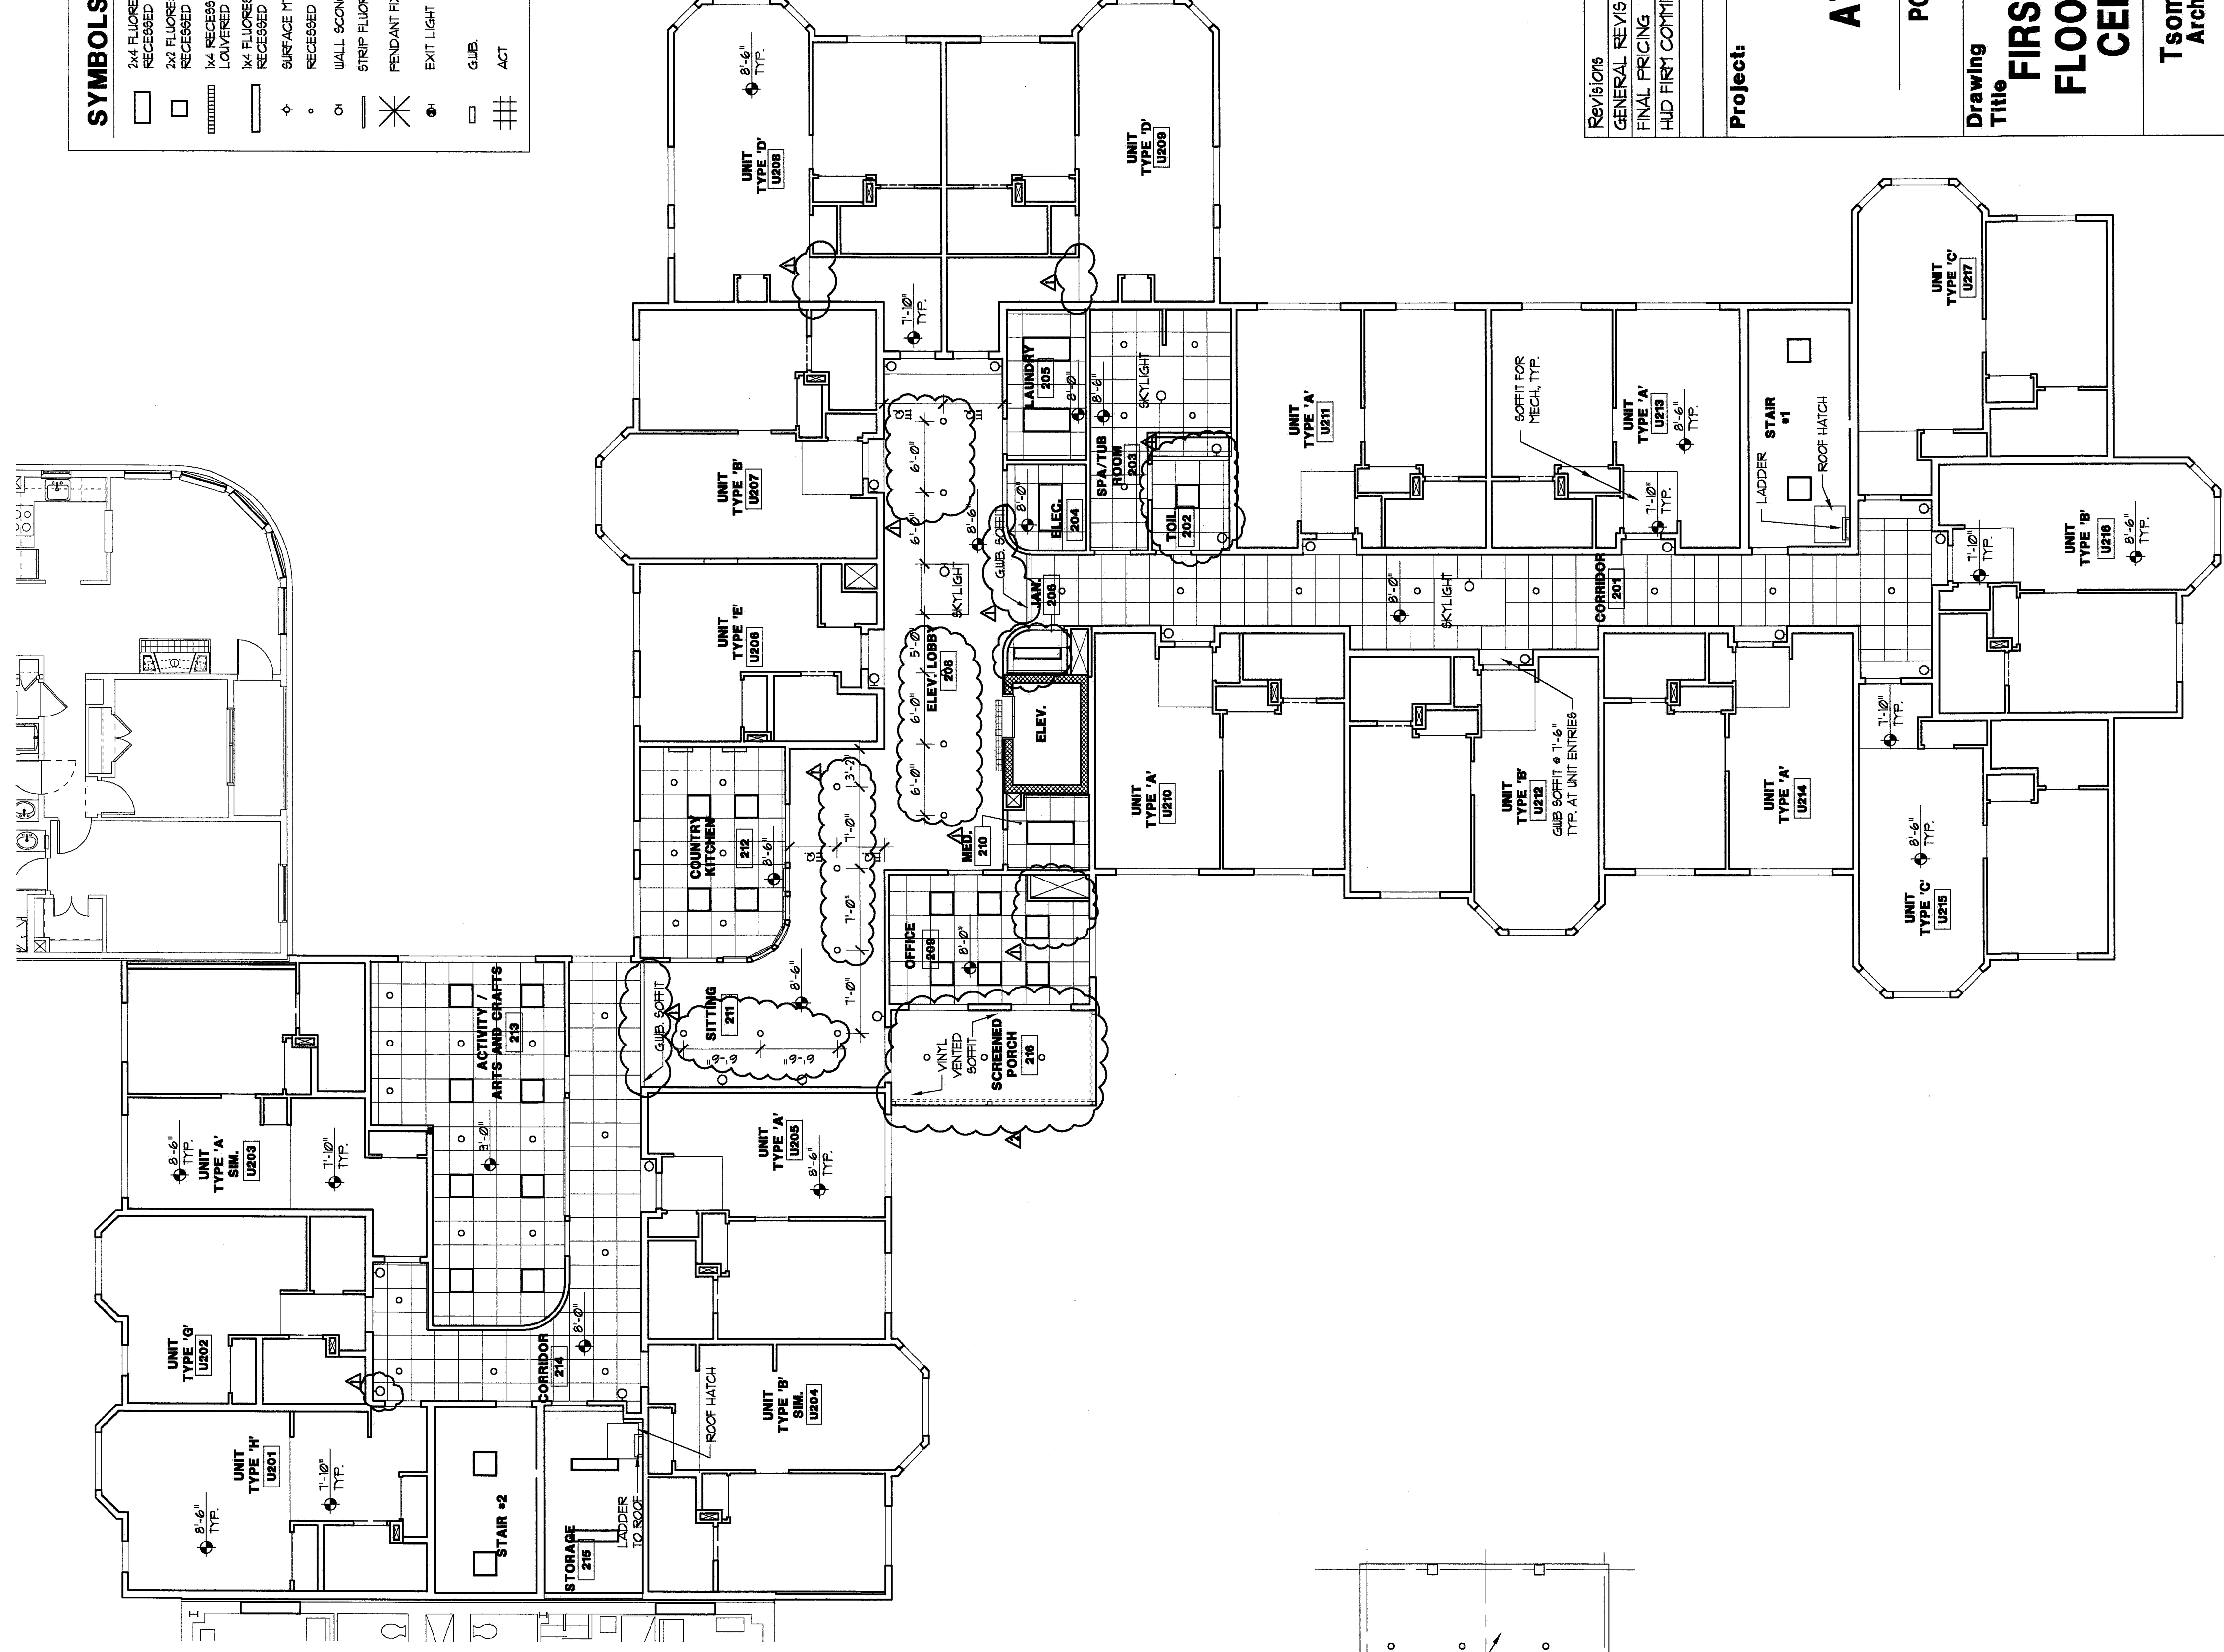

1 SECOND FLOOR RCP

**SYMBOLS**

[Symbol]	1/4" FLUORESCENT FIXTURE
[Symbol]	2x4 FLUORESCENT FIXTURE
[Symbol]	RECESSED OR SURFACE
[Symbol]	RECESSED FLUORESCENT FIXTURE
[Symbol]	LOW VOLTAGE
[Symbol]	LOW VOLTAGE FLUORESCENT FIXTURE
[Symbol]	RECESSED OR SURFACE
[Symbol]	RECESSED CAN
[Symbol]	SURFACE MTD PENDANT FIXTURE
[Symbol]	WALL SCONCE
[Symbol]	STEP FLUORESCENT FIXTURE
[Symbol]	PENDANT FIXTURE
[Symbol]	EXIT LIGHT - WALL MOUNTED
[Symbol]	G.B.S.
[Symbol]	ACT

NO.	DATE
1	03/20/06
2	10/05/06
3	11/22/06

Project: **THE INN AT CEDARS**  
 PORTLAND, MAINE

Drawing Title: **FIRST & SECOND FLOOR REFLECTED CEILING PLANS**

Tsonides Associates  
 Architects and Planners  
 389 Elliot Street  
 Newton Upper Falls, MA 02464  
 (617) 969-4774 Fax: (617) 969-4793  
 e-mail: info@tsonides.com www.tsonides.com

SCALE: 1/8" = 1'-0"

DATE: 08/24/05 BID SET

PROJECT: THE INN AT CEDARS

NO. 331

**A-301**

