



- NOTES:
1. THE ENTRANCE SHALL BE MAINTAINED IN A CONDITION THAT WILL PREVENT TRACKING OR FLOWING OF SEDIMENT ONTO PUBLIC RIGHT-OF-WAYS. THIS MAY REQUIRE TOP DRESSING, REPAIR AND/OR CLEAN OUT OF ANY MEASURES USED TO TRAP SEDIMENT.
 2. WHEN NECESSARY, WHEELS SHALL BE CLEANED PRIOR TO ENTRANCE ONTO PUBLIC RIGHT-OF-WAY.
 3. WHEN WASHING IS REQUIRED, IT SHALL BE DONE ON AN AREA STABILIZED WITH CRUSHED STONE THAT DRAINS ONTO AN APPROVED SEDIMENT TRAP OR SEDIMENT BASIN.


1 CONSTRUCTION ENTRANCE
C3.1 NOT TO SCALE

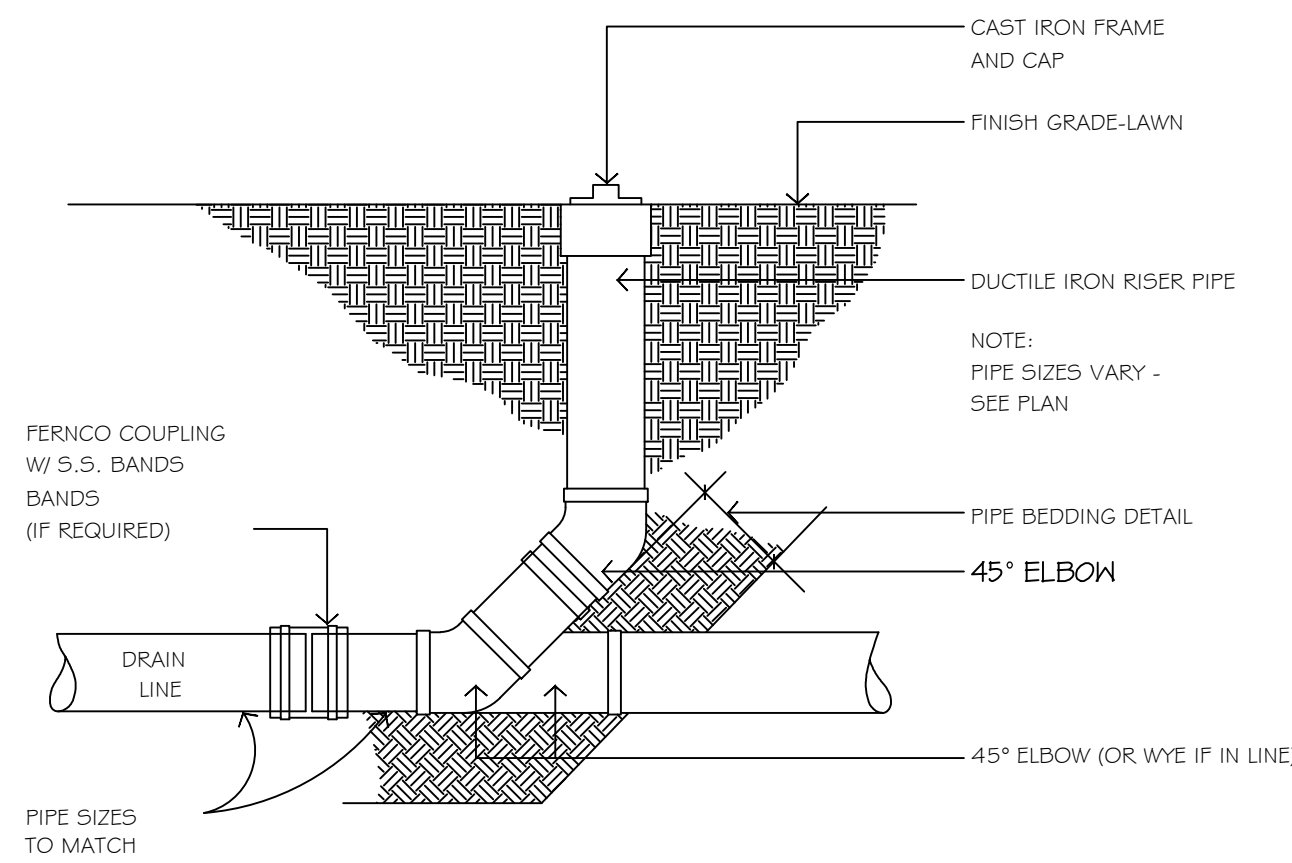


2 PIPE CLEANOUT DETAIL
C3.1 NOT TO SCALE

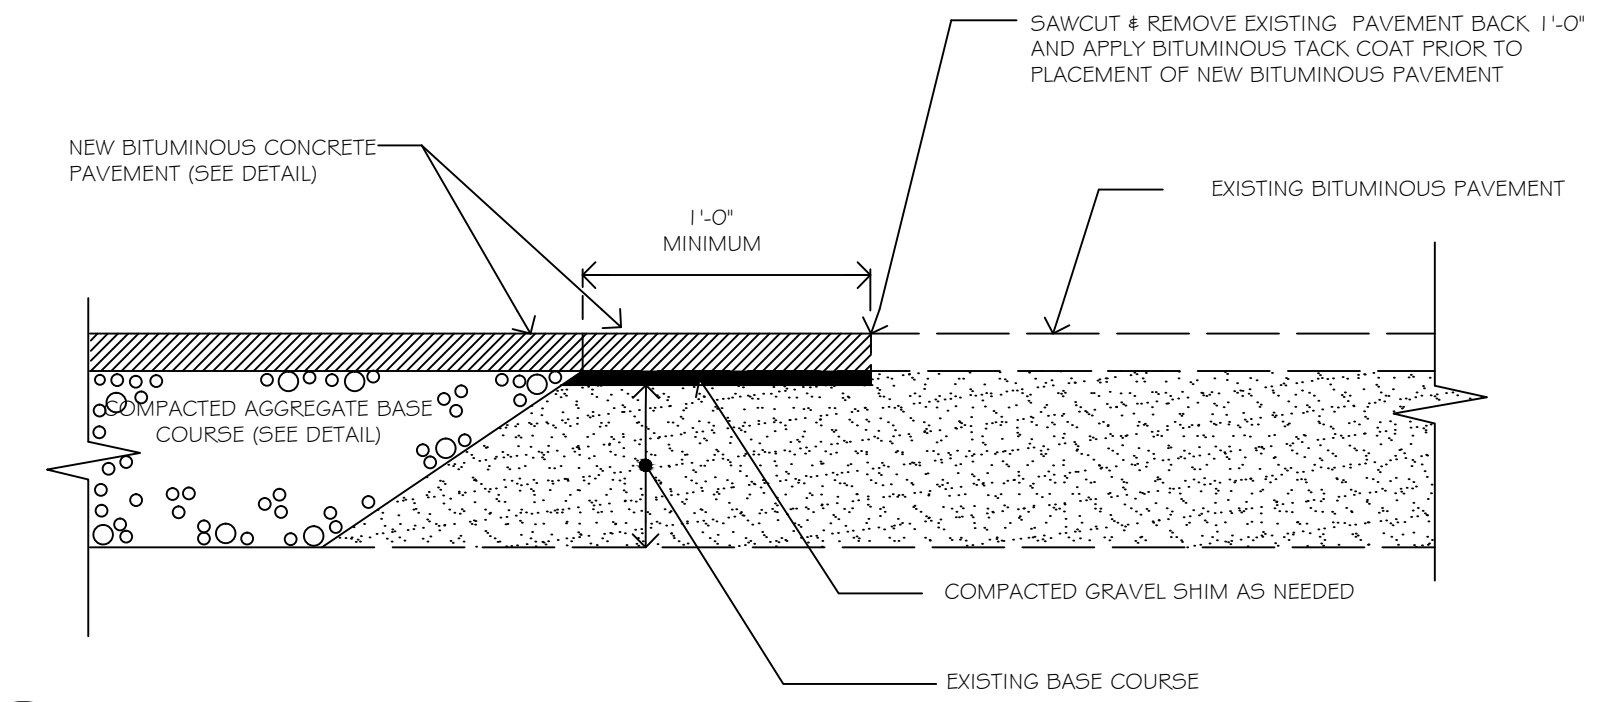


3 PAVEMENT SAW CUT DETAIL
C3.1 NOT TO SCALE

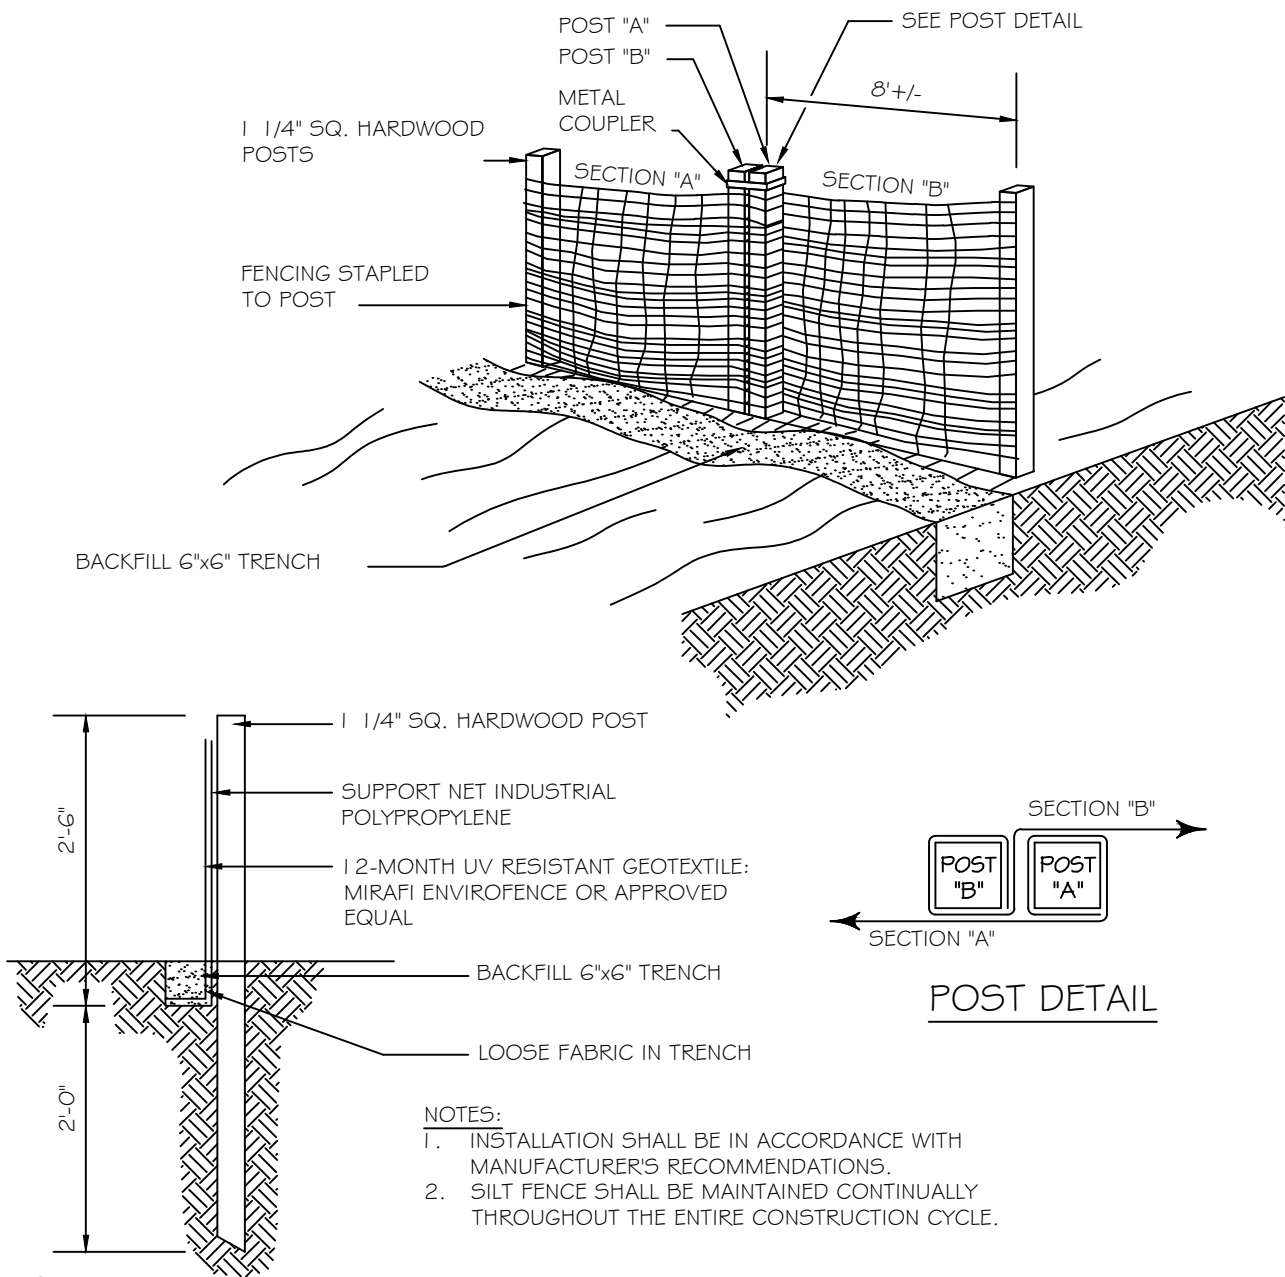


4 PREFABRICATED SILT FENCE
C3.1 NOT TO SCALE

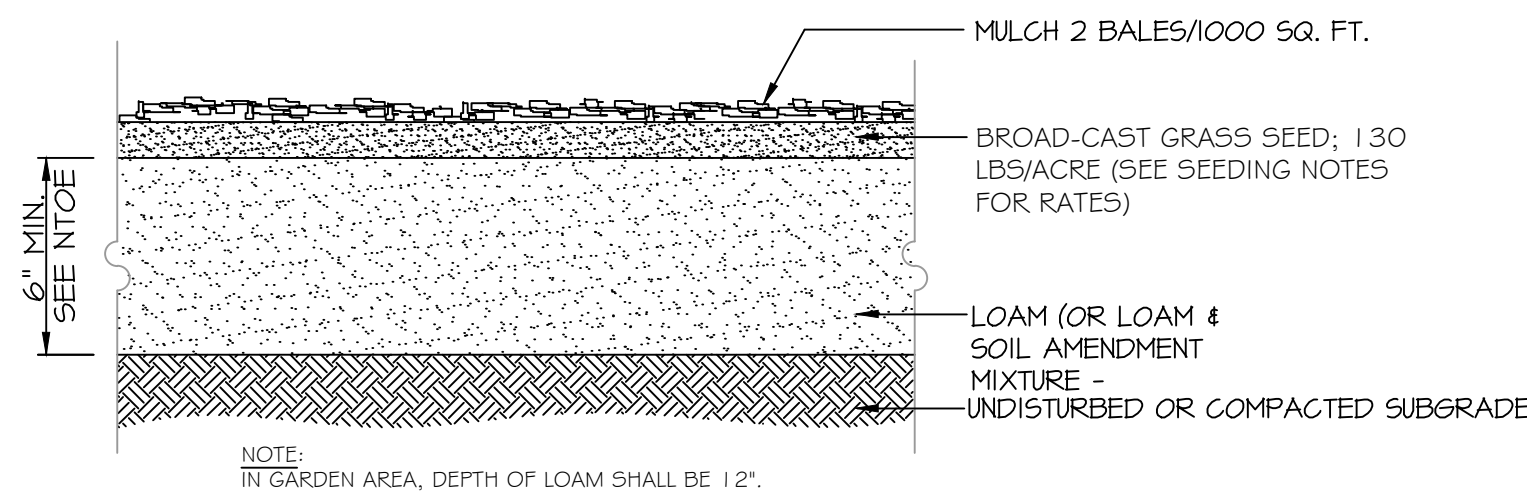


5 LOAM AND SEED DETAIL
C3.1

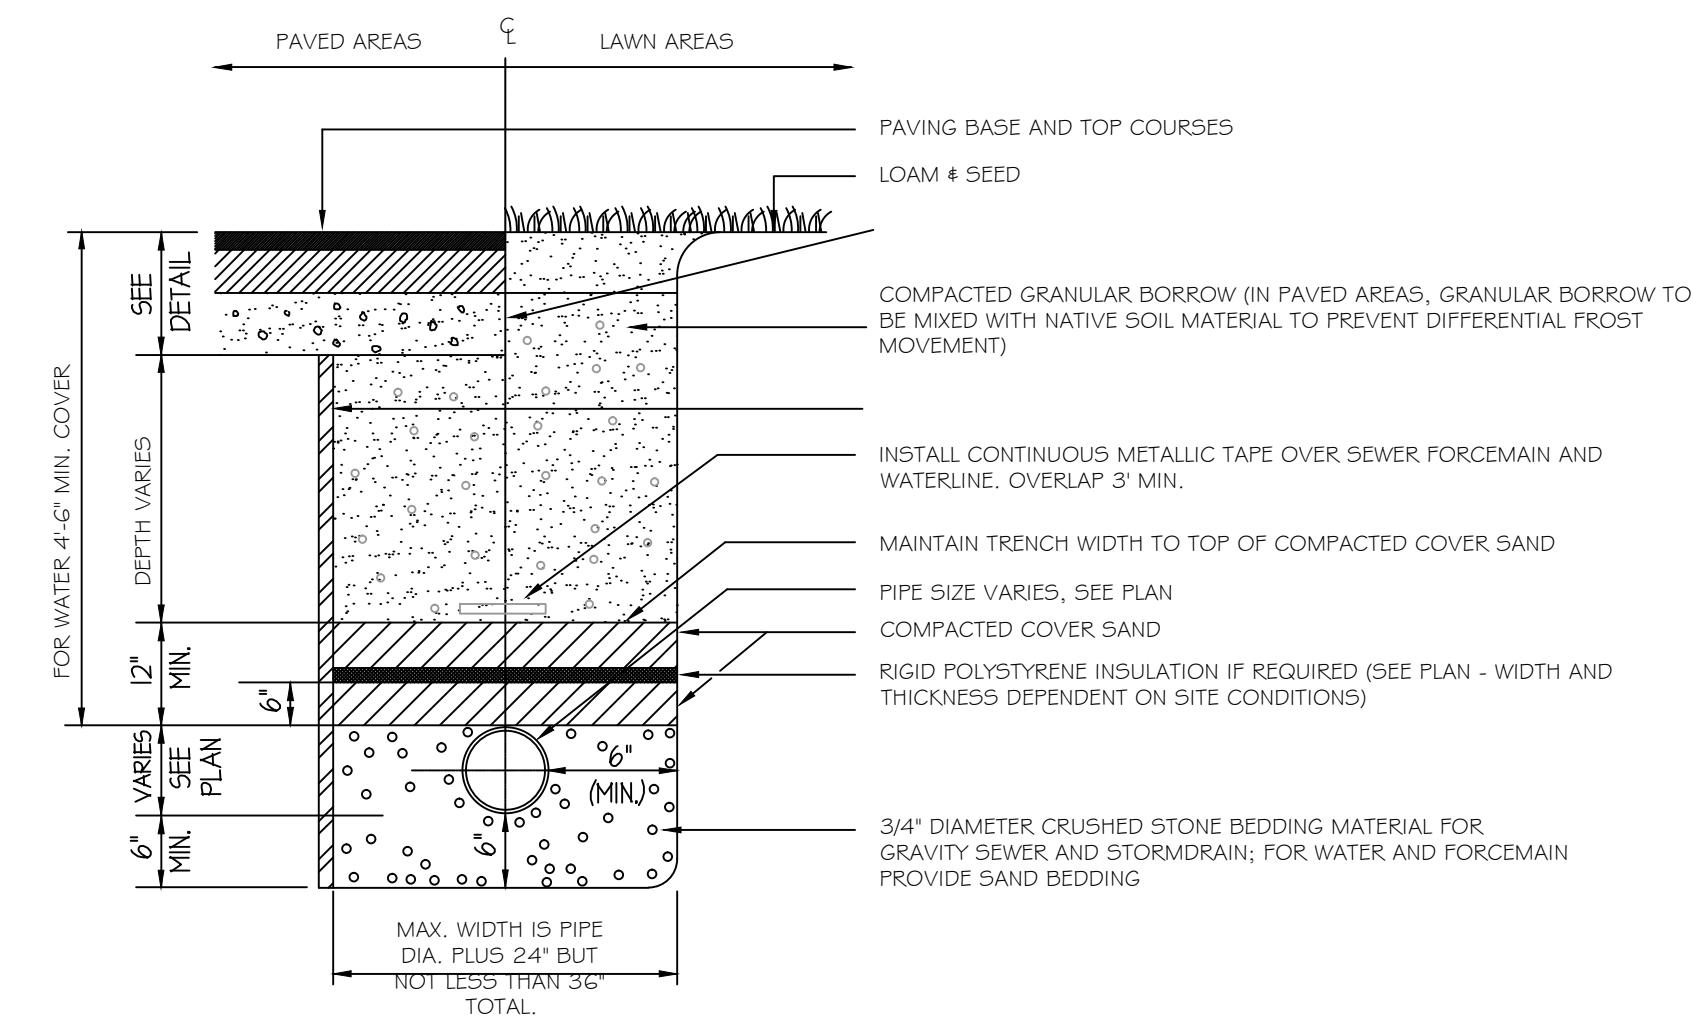

6 TYPICAL PIPE TRENCHING DETAIL
C3.1 NOT TO SCALE

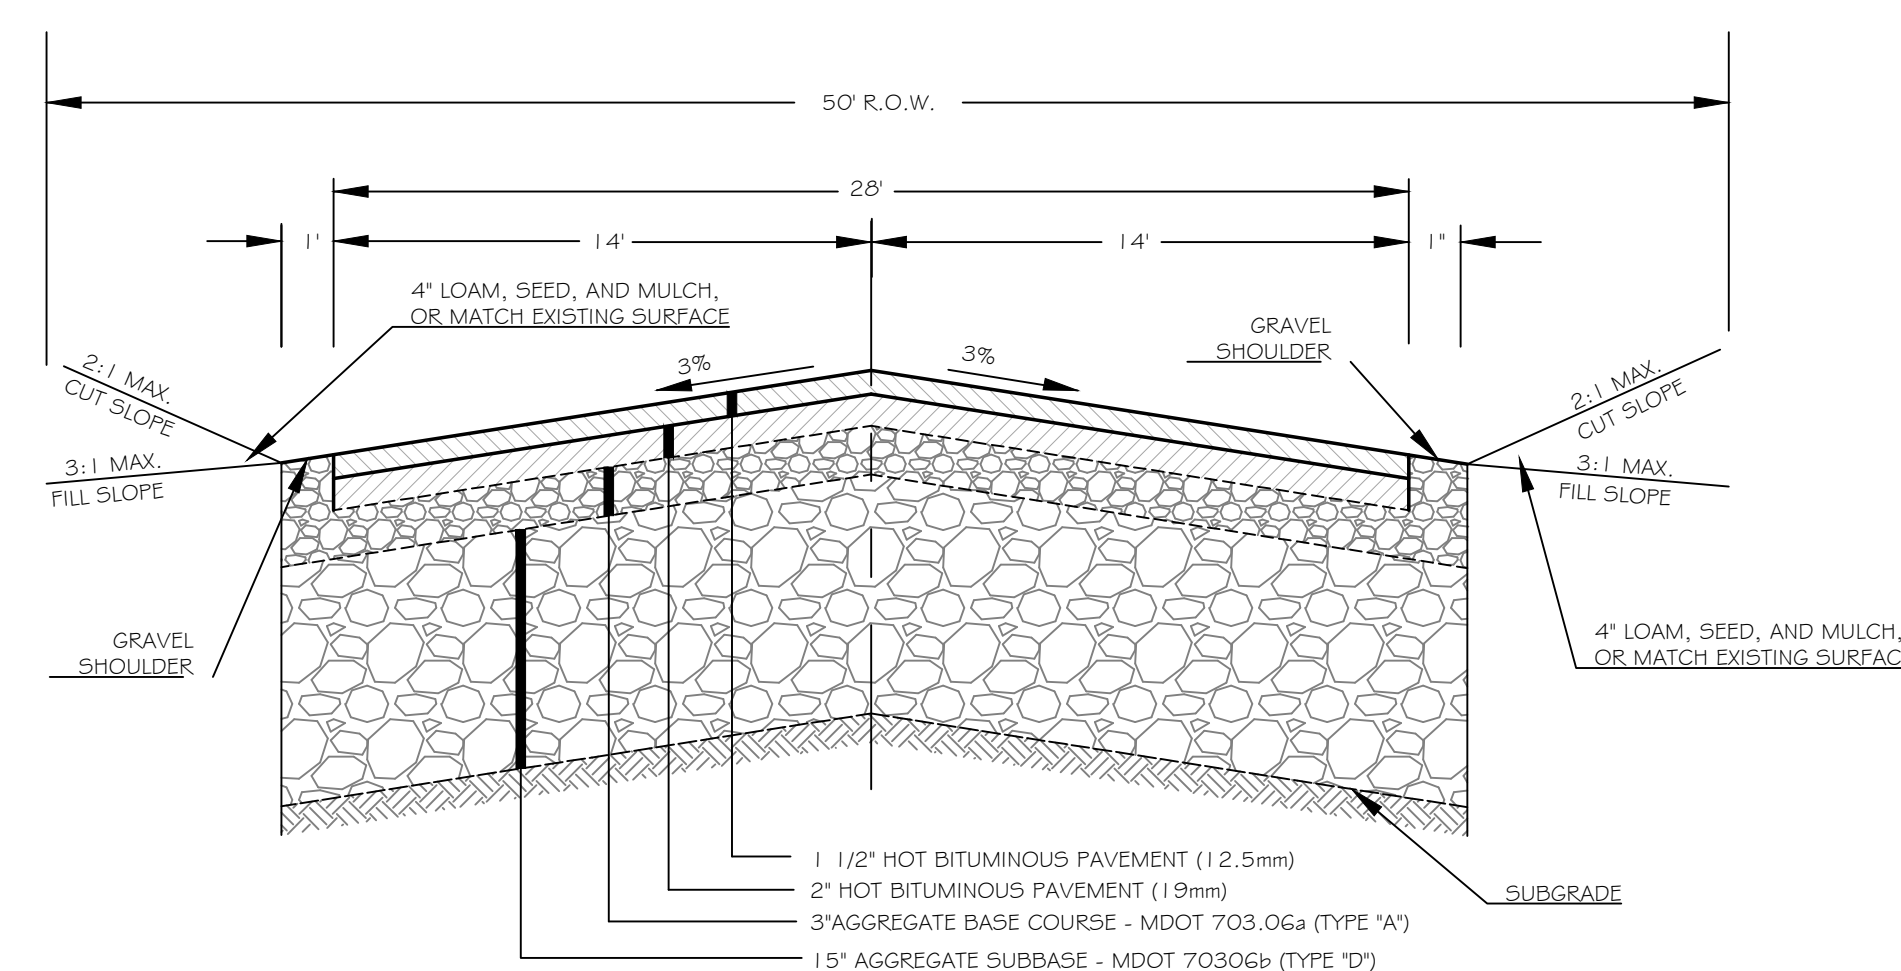


7 TYPICAL ROAD SECTION
C3.1 NOT TO SCALE

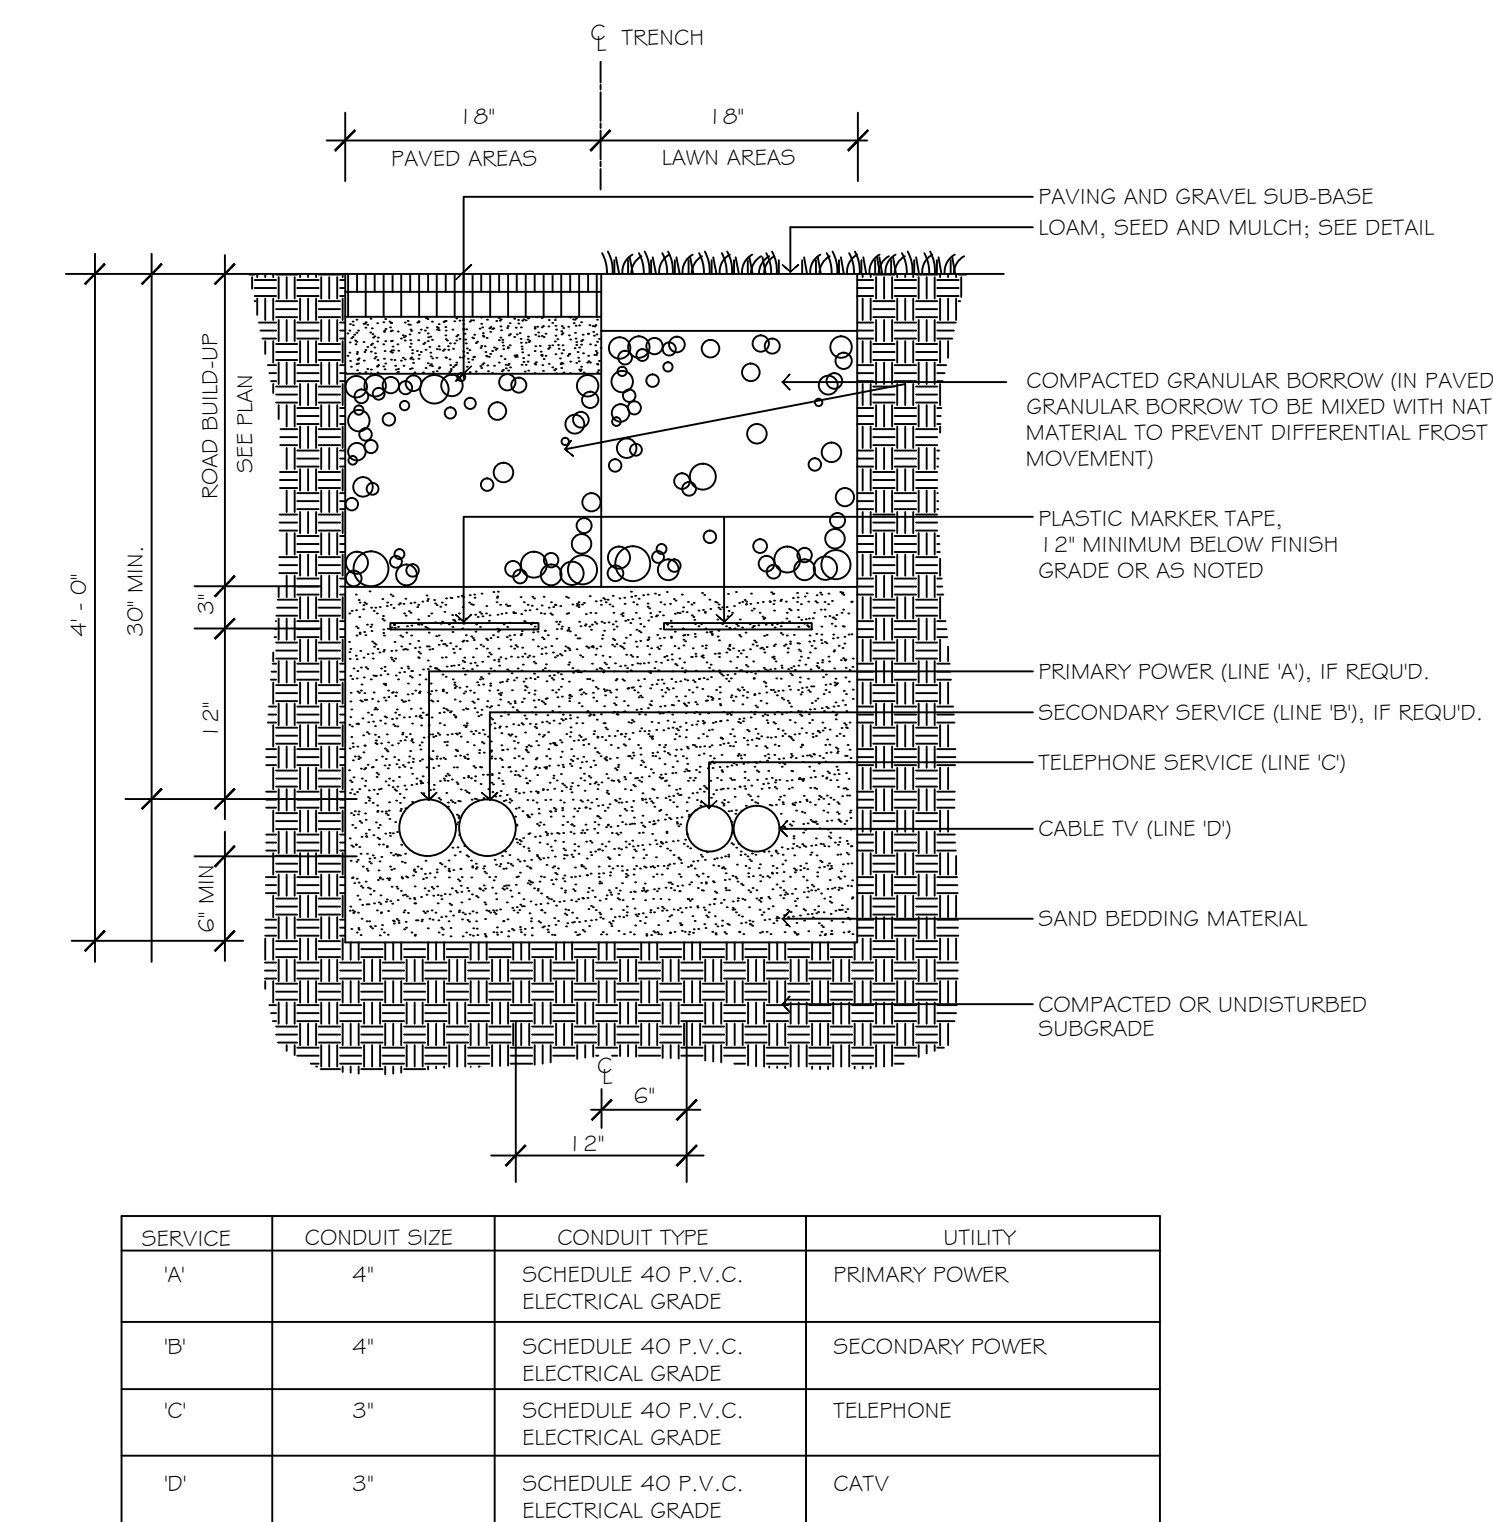

| SERVICE | CONDUIT SIZE | CONDUIT TYPE | UTILITY |
|---------|--------------|-------------------------------------|-----------------|
| 'A' | 4" | SCHEDULE 40 P.V.C. ELECTRICAL GRADE | PRIMARY POWER |
| 'B' | 4" | SCHEDULE 40 P.V.C. ELECTRICAL GRADE | SECONDARY POWER |
| 'C' | 3" | SCHEDULE 40 P.V.C. ELECTRICAL GRADE | TELEPHONE |
| 'D' | 3" | SCHEDULE 40 P.V.C. ELECTRICAL GRADE | CATV |

- NOTES:
1. ALL WORK SHALL COMPLY WITH THE RESPECTIVE UTILITY COMPANY STANDARDS.
 2. SEE UTILITIES PLANS FOR CONDUIT LOCATIONS.
 3. CONTRACTOR TO PROVIDE 1/4\"/>

8 UNDERGROUND UTILITY TRENCH SECTION (MULTIPLE CONDUITS)
C3.1 NOT TO SCALE

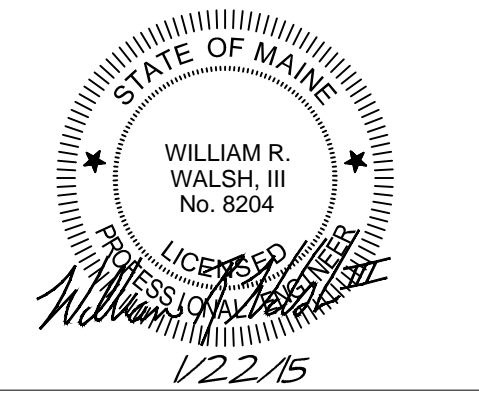

MOTLEY STREET EXTENSION
PORTLAND, MAINE
MOTLEY STREET
SKYLINE REAL ESTATE SERVICES, INC
64 MIDDLE STREET
PORTLAND, MAINE 04101

FOR PERMITTING ONLY - NOT FOR CONSTRUCTION

| Rev. | Date | Description | Drawn | Check |
|------|---------|--|-------|-------|
| A | 1/8/12 | ISSUED FOR SITE PLAN REVIEW | SWC | WRW |
| B | 1/23/13 | REVISED PER CITY OF PORTLAND REVIEW COMMENTS | SWC | WRW |
| C | 1/22/15 | RE-ISSUED FOR SITE PLAN REVIEW | SWC | WRW |

Sheet Title:
SITE DETAILS
Job No.: 173
Date: NOV 9, 2012
Scale: NTS
Drawn: SWC
Checked: WRW
Sheet No.: **C3.1**