


1 FIRST FLOOR LIGHTING & FIRE ALARM PLAN
SCALE: NOT TO SCALE

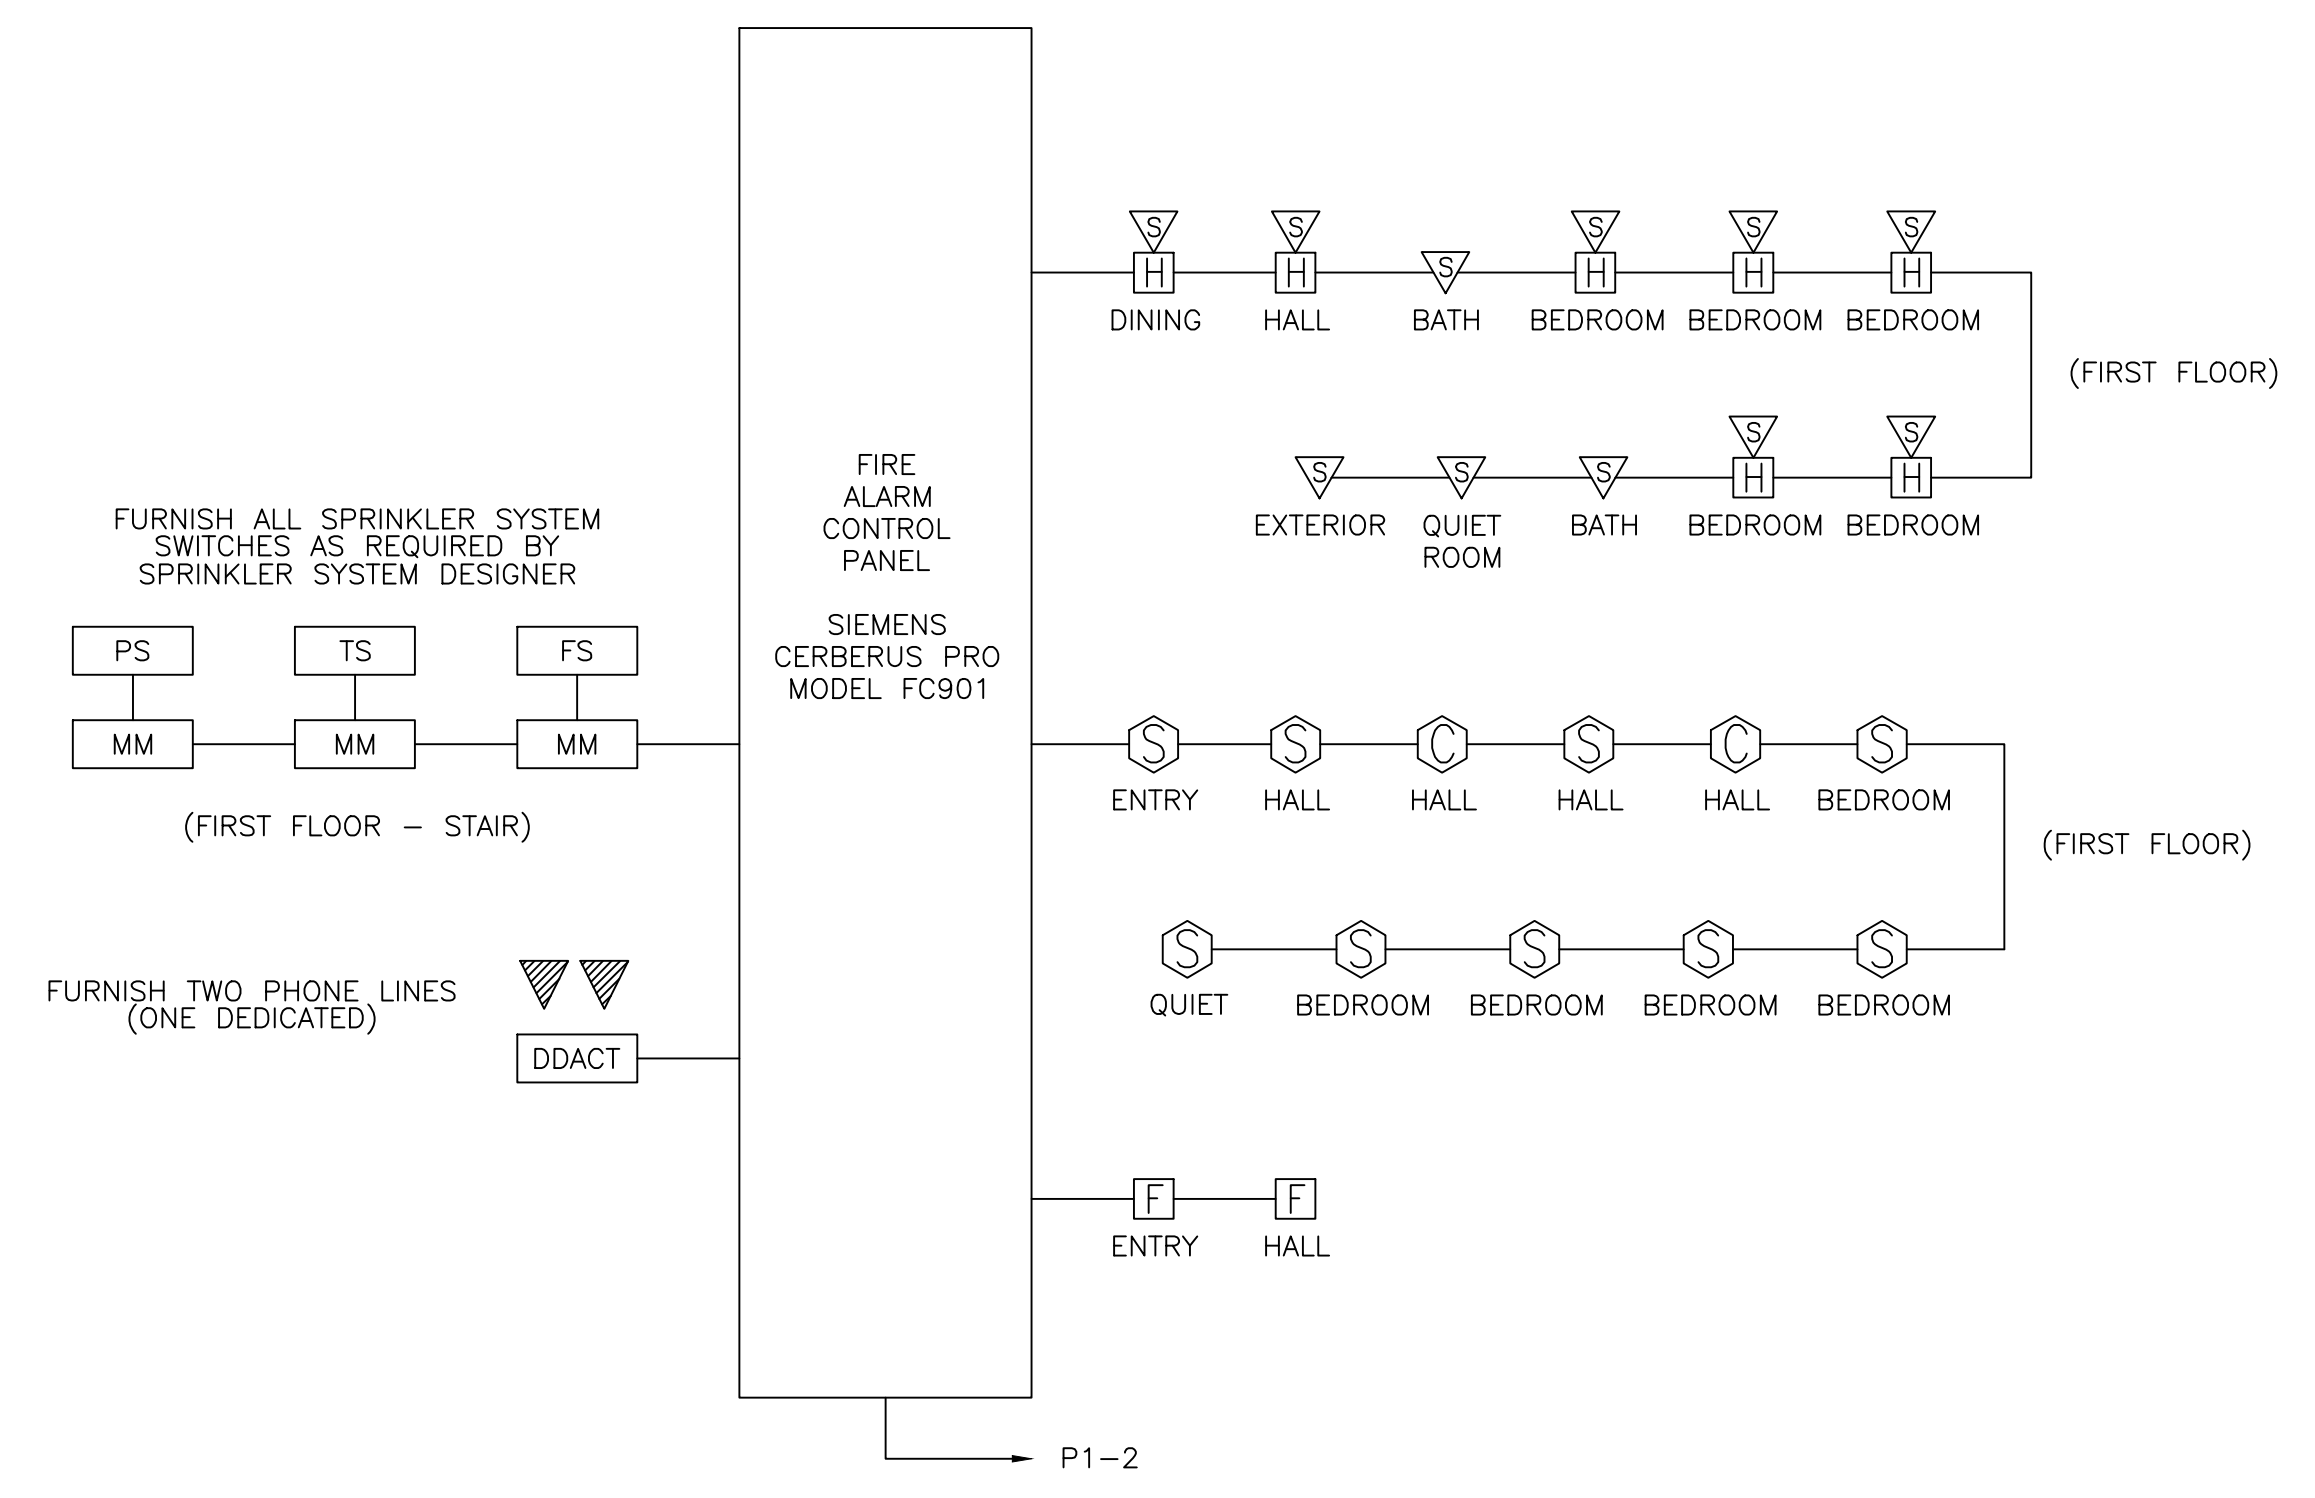

3 FIRE ALARM RISER DIAGRAM
SCALE: NOT TO SCALE

REV	BY	DATE	STATUS
WESTMINSTER SENIOR CENTER PORTLAND, MAINE			
ELECTRICAL LIGHTING & FIRE ALARM PLAN			
	SWIFTCURRENT		DESIGN BY: TDM
	Engineering Services		DRAWN BY: KLM
	10 Forest Falls Dr. Unit 8B Yarmouth, ME 04096 Tel: (207) 847-9280		DATE: 6/4/2013
			JOB: 13012
			SCALE: AS NOTED
			E2.0