


| REVISION | DESCRIPTION                  | DATE      |
|----------|------------------------------|-----------|
| 0        | ISSUED FOR REVIEW & APPROVAL | 9/30/2013 |

RESERVED FOR CITY STAMP

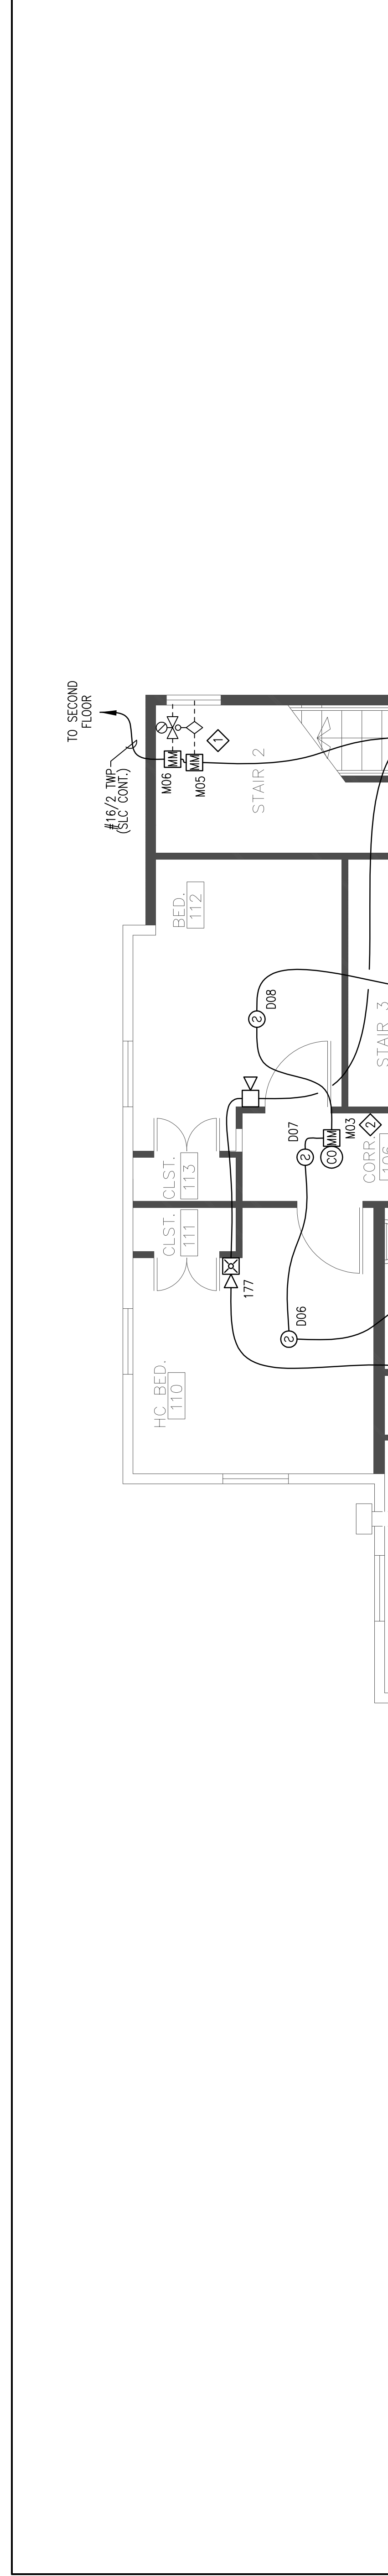

FIRST FLOOR FIRE ALARM PLAN  
SCALE: 1/4"=1'-0"

**CUNNINGHAM**  
Security Systems

10 Princes Point Road, Yarmouth, Maine 04096  
Office: 207.846.3350 • Fax: 207.846.6080

**SHALOM HOUSE**  
503 WOODFORD STREET  
PORTLAND, MAINE 04103  
FIRST FLOOR FIRE ALARM PLAN

|          |                |                   |
|----------|----------------|-------------------|
| DRAWN    | JPB            | UNICAD JOB #13531 |
| CHECKED  | WAYNE B. HAWES | NCET # 90496      |
| DATE     | 9/30/2013      |                   |
| REVISION | 0              |                   |
| SCALE    | 1/4"=1'-0"     |                   |

**FA-3**

**SHEET NOTES:**

- ◇ ADDRESSABLE MONITOR MODULE(S) PROVIDED TO MONITOR ALL WATER FLOW PRESSURE SWITCHES, TAMPER SWITCHES AND POST INDICATING VALVES. ASSOCIATED WITH THE FIRE SPRINKLER SYSTEM. INSTALLING CONTRACTOR SHALL FIELD VERIFY EXACT MOUNTING, CIRCUITING AND PROGRAMMING REQUIREMENTS. FIELD VERIFY EXACT QUANTITY AND LOCATION(S).
- ◇ ADDRESSABLE MONITOR MODULE(S) PROVIDED TO MONITOR CARBON MONOXIDE DETECTOR. INSTALLING CONTRACTOR SHALL FIELD VERIFY EXACT MOUNTING, CIRCUITING AND PROGRAMMING REQUIREMENTS. FIELD VERIFY EXACT QUANTITY AND LOCATION(S).

**UNICAD** Inc.  
Fire Alarm Design & Drafting Services

www.unicad.net