


REVISION	DESCRIPTION	DATE
0	ISSUED FOR REVIEW & APPROVAL	9/30/2013

RESERVED FOR CITY STAMP

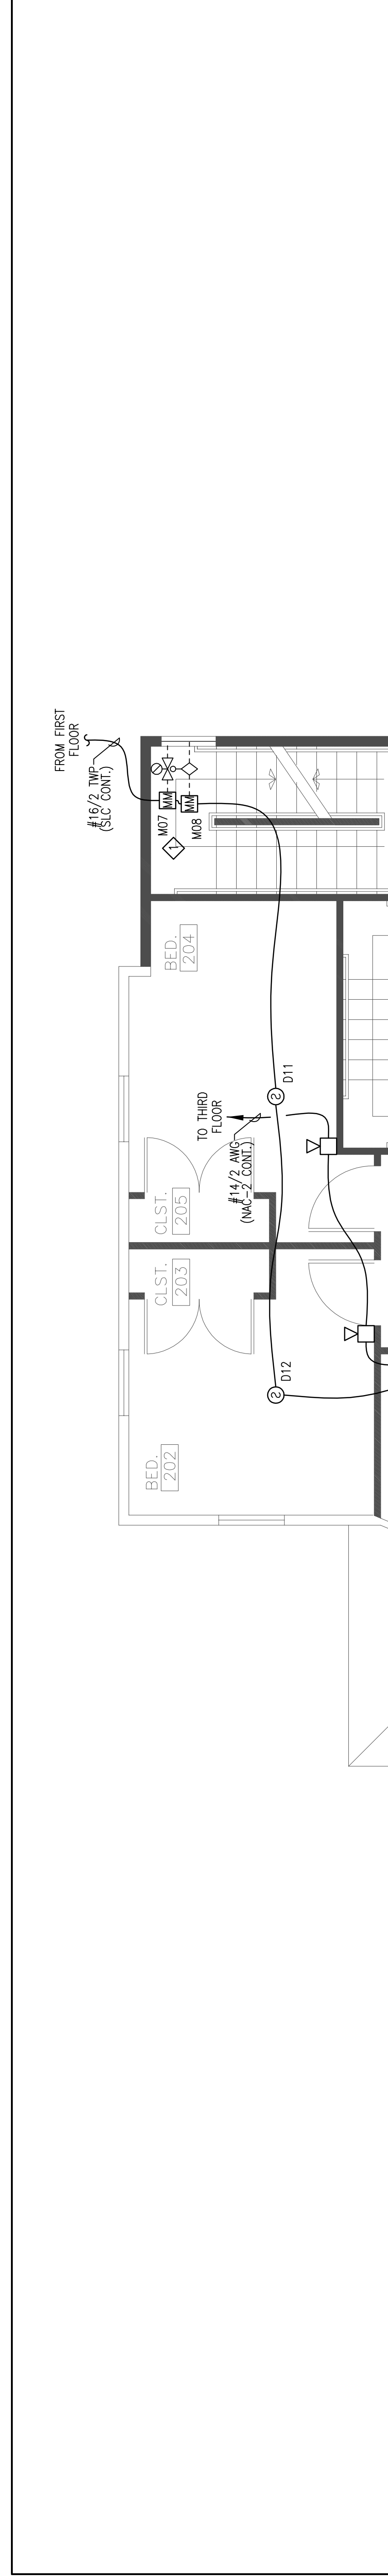

SECOND FLOOR FIRE ALARM PLAN
SCALE: 1/4"=1'-0"

CUNNINGHAM
Security Systems
10 Princes Point Road, Yarmouth, Maine 04096
Office: 207.846.3350 • Fax: 207.846.6080

SHALOM HOUSE
503 WOODFORD STREET
PORTLAND, MAINE 04103
SECOND FLOOR FIRE ALARM PLAN

DRAWN	JPB UNICAD JOB #13531
CHECKED	WAYNE B. HAWES NGEET # 90496
DATE	9/30/2013
REVISION	0
SCALE	1/4"=1'-0"

FA-4

SHEET NOTES:

- ◇ ADDRESSABLE MONITOR MODULE(S) PROVIDED TO MONITOR ALL WATER FLOW, PRESSURE SWITCHES, TAMPER SWITCHES AND POST INDICATING VALVES ASSOCIATED WITH THE FIRE SPRINKLER SYSTEM. INSTALLING CONTRACTOR SHALL FIELD VERIFY EXACT MOUNTING, CIRCUITING AND PROGRAMMING REQUIREMENTS. FIELD VERIFY EXACT QUANTITY AND LOCATION(S).
- ◇ ADDRESSABLE MONITOR MODULE(S) PROVIDED TO MONITOR CARBON MONOXIDE DETECTOR. INSTALLING CONTRACTOR SHALL FIELD VERIFY EXACT MOUNTING, CIRCUITING AND PROGRAMMING REQUIREMENTS. FIELD VERIFY EXACT QUANTITY AND LOCATION(S).