


REVISION	DESCRIPTION	DATE
0	ISSUED FOR REVIEW & APPROVAL	9/30/2013

RESERVED FOR CITY STAMP

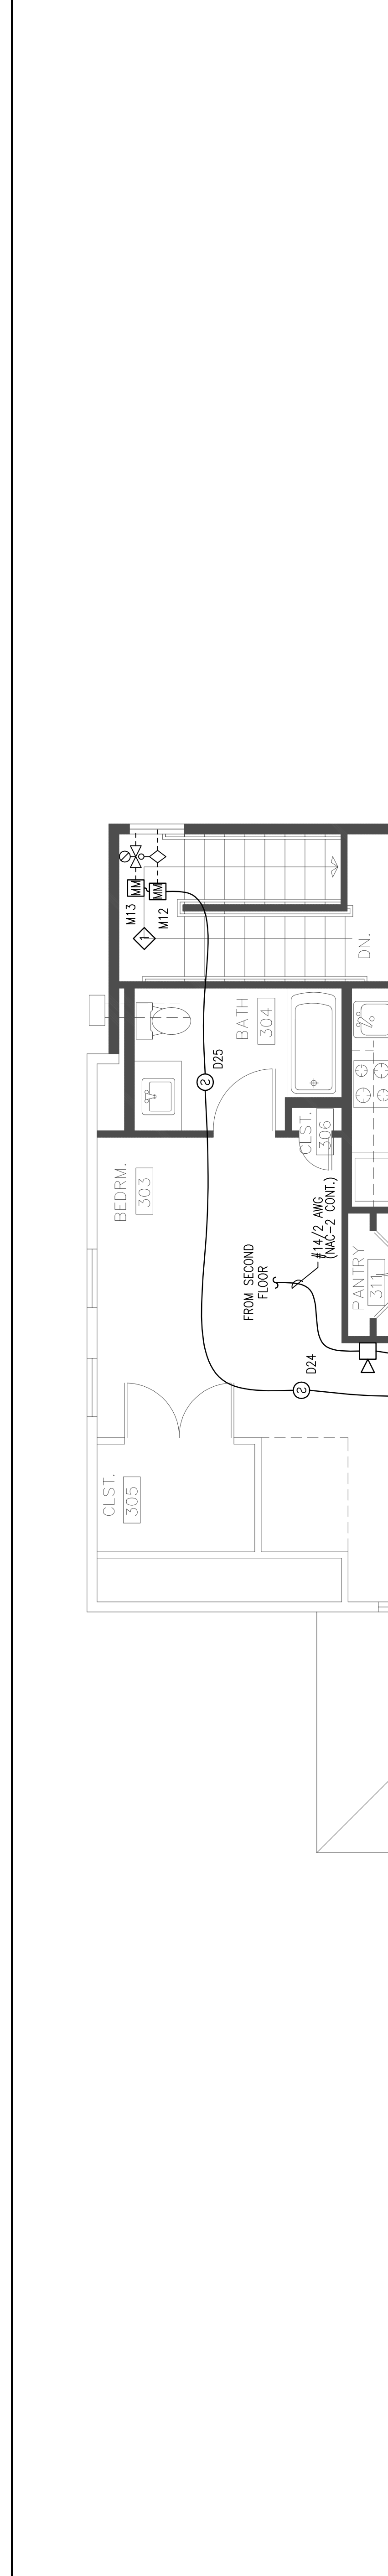

CUNNINGHAM
 Security Systems
 10 Princes Point Road, Yarmouth, Maine 04096
 Office: 207.846.3350 • Fax: 207.846.6080

SHALOM HOUSE
 503 WOODFORD STREET
 PORTLAND, MAINE 04103
THIRD FLOOR FIRE ALARM PLAN

DRAWN	JPB	UNICAD JOB #13531
CHECKED	WAYNE B. HAWES	NCET # 90496
DATE	9/30/2013	
REVISION	0	
SCALE	1/4"=1'-0"	

FA-5

SHEET NOTES:

- ◇ ADDRESSABLE MONITOR MODULE(S) PROVIDED TO MONITOR ALL WATER FLOW PRESSURE SWITCHES, TAMP SWITCHES AND POST INDICATING VALVES ASSOCIATED WITH THE FIRE SPRINKLER SYSTEM. INSTALLING CONTRACTOR SHALL FIELD VERIFY EXACT MOUNTING, CIRCUITING AND PROGRAMMING REQUIREMENTS. FIELD VERIFY EXACT QUANTITY AND LOCATION(S).
- ◇ ADDRESSABLE MONITOR MODULE(S) PROVIDED TO MONITOR CARBON MONOXIDE DETECTOR. INSTALLING CONTRACTOR SHALL FIELD VERIFY EXACT MOUNTING, CIRCUITING AND PROGRAMMING REQUIREMENTS. FIELD VERIFY EXACT QUANTITY AND LOCATION(S).

THIRD FLOOR FIRE ALARM PLAN
 SCALE: 1/4"=1'-0"