
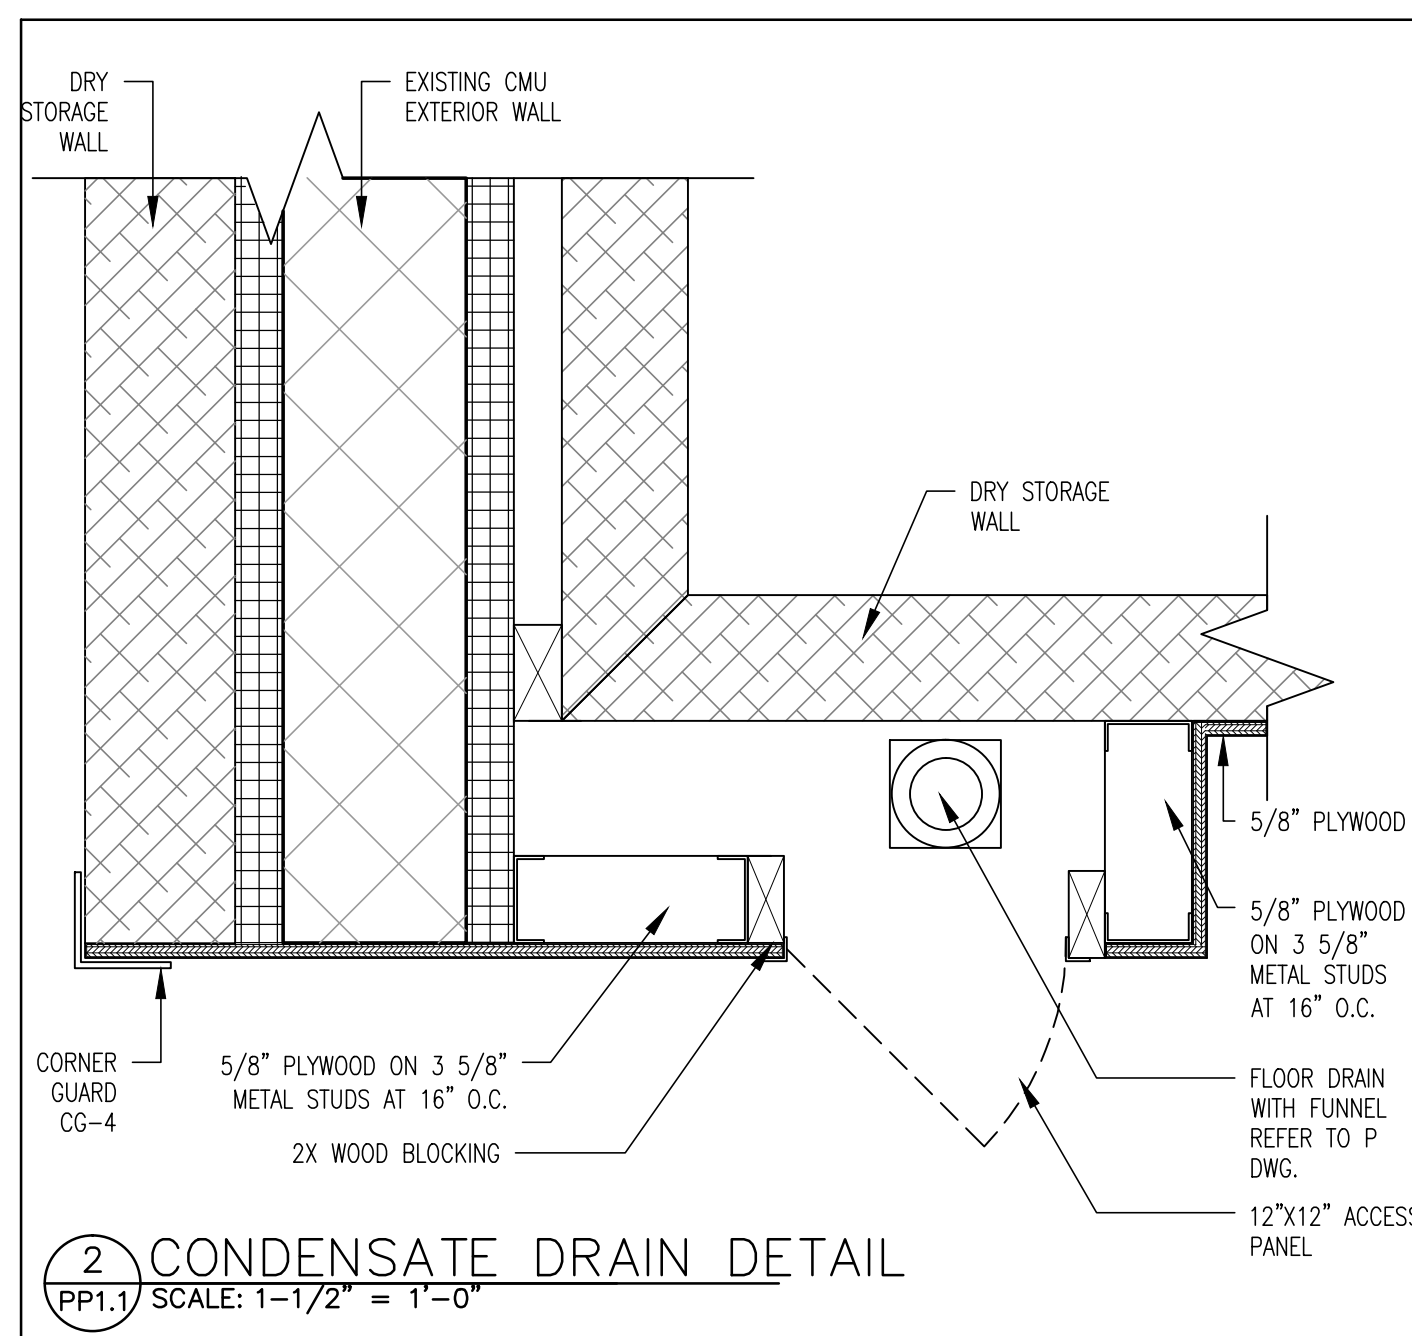
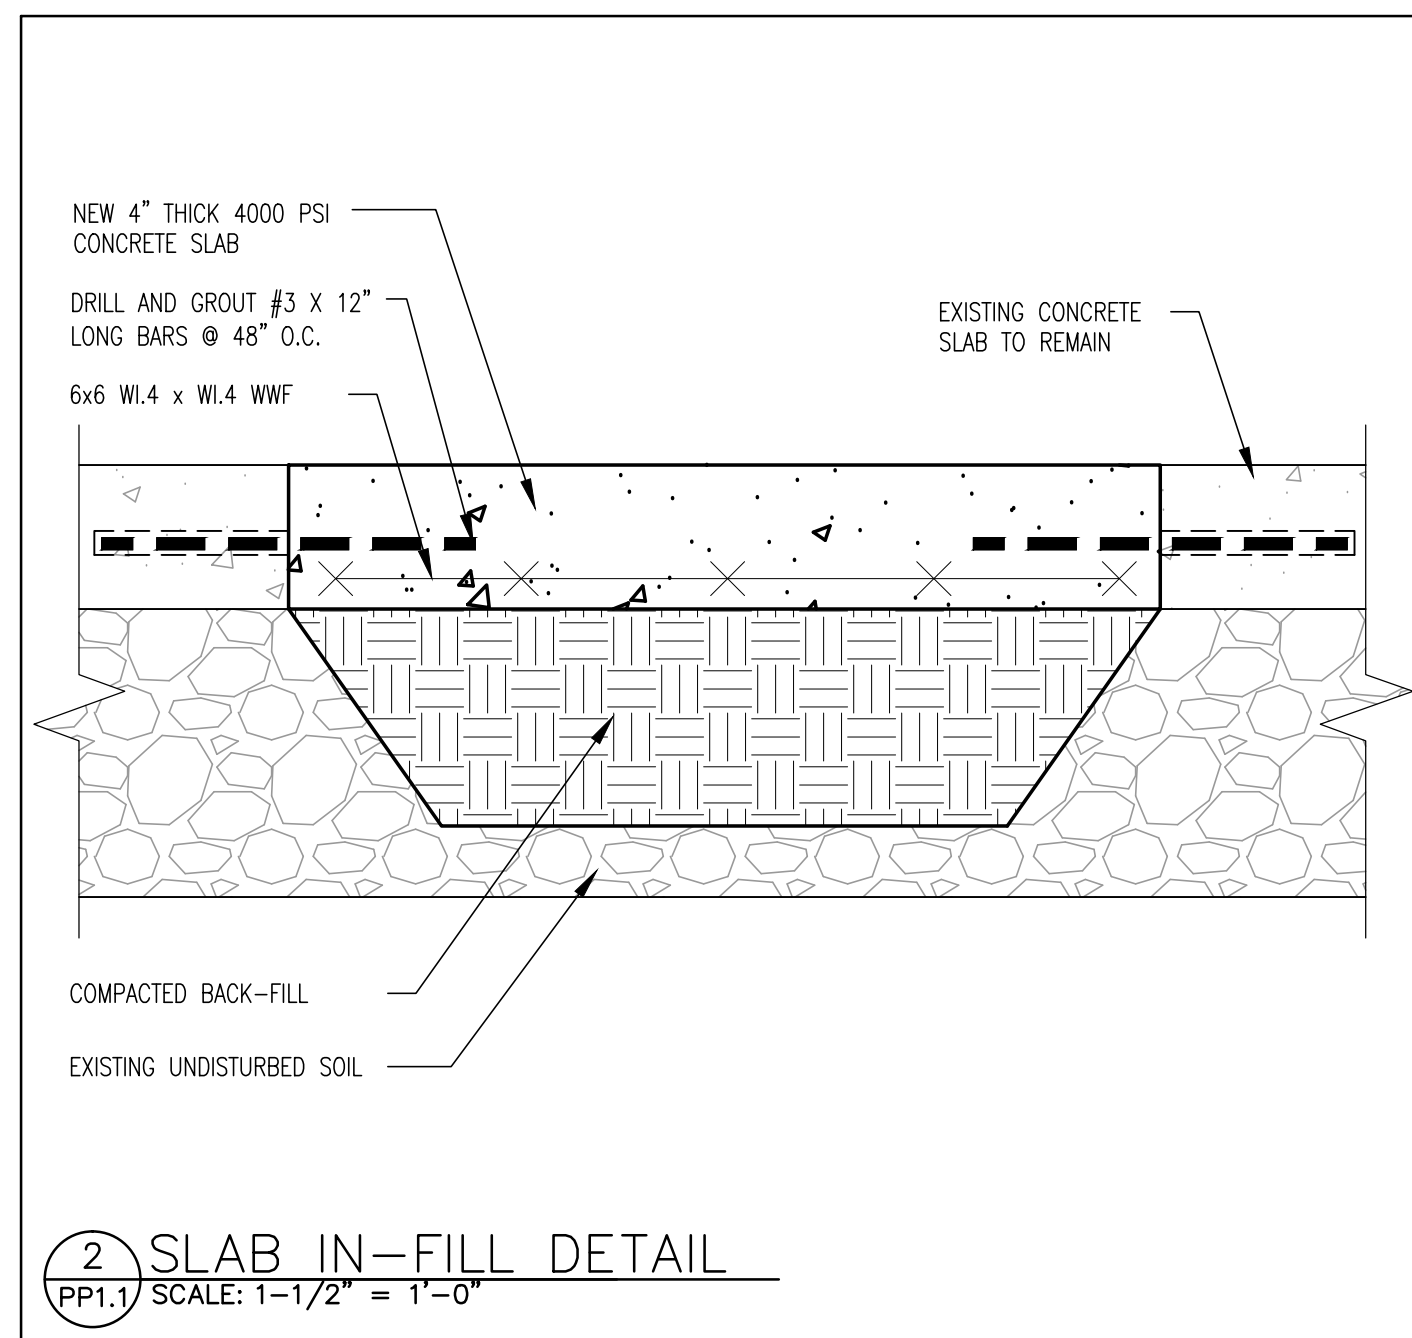
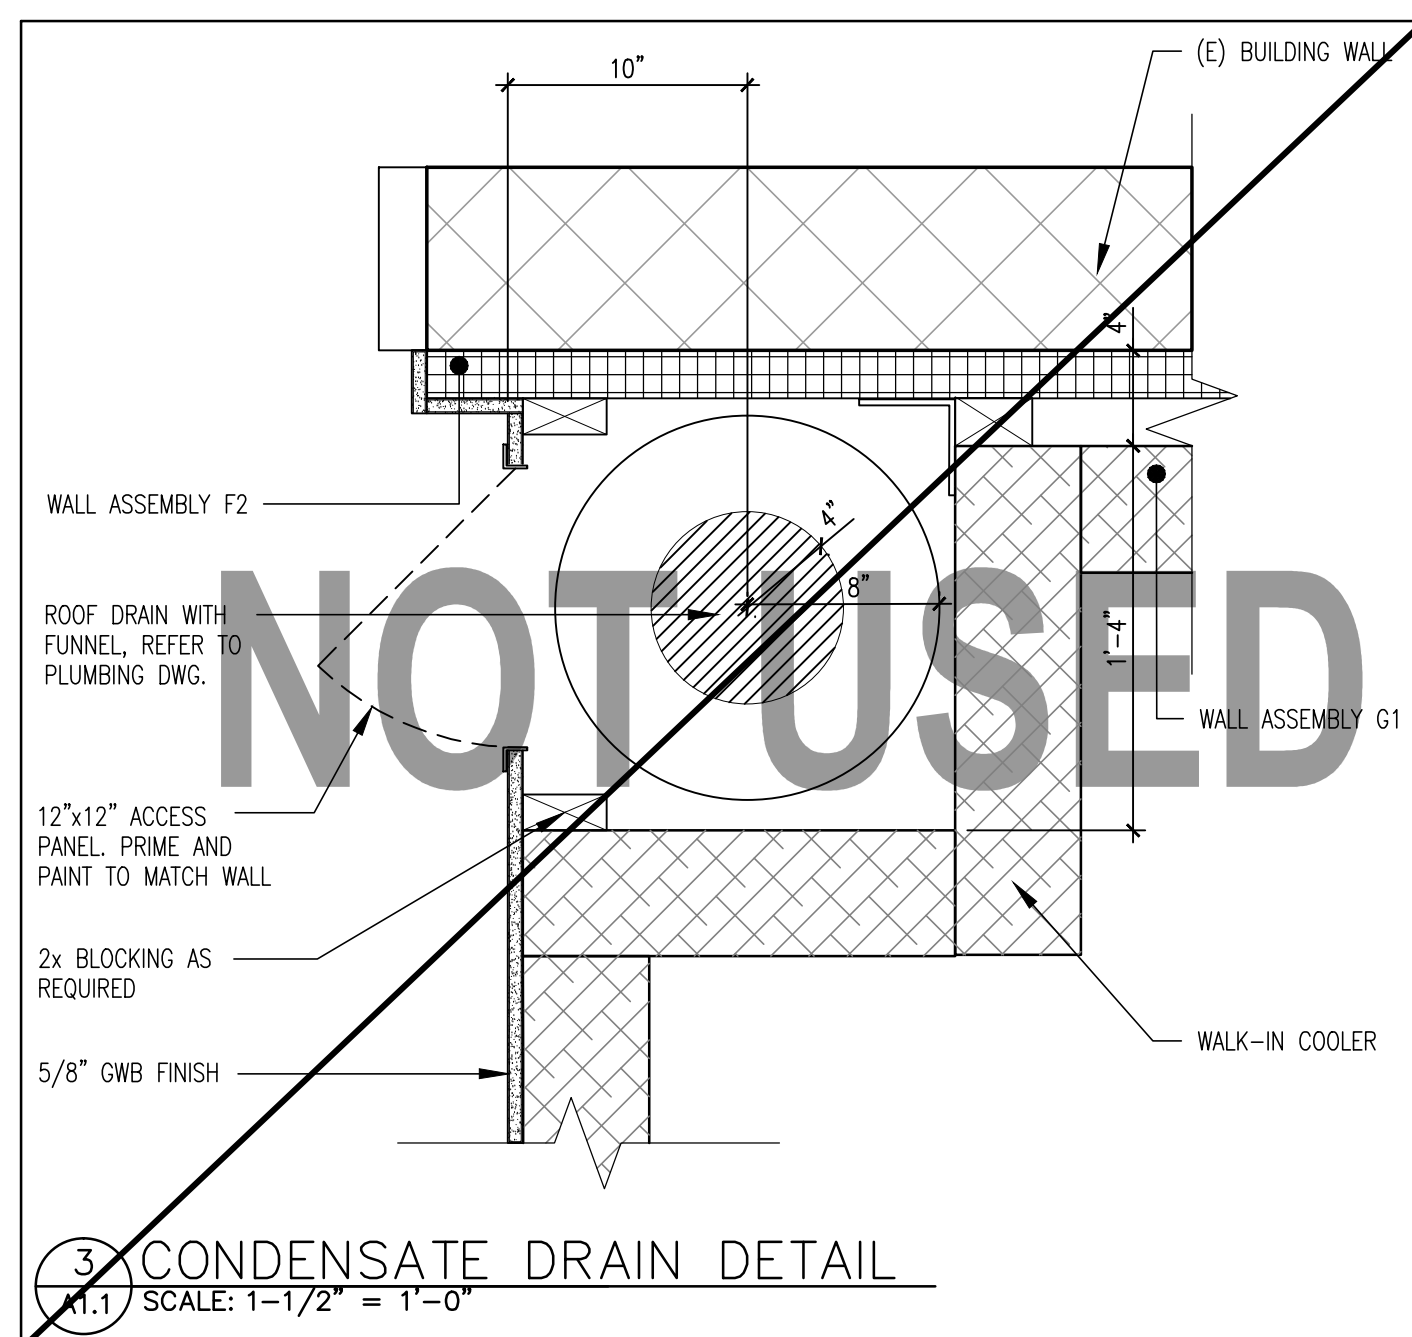


No.	Date	Issued for
-	11/22/13	90% CD Review Set
-	01/24/14	Bid & Permit

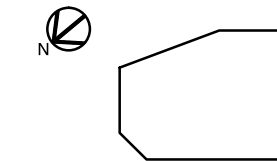


NOTES

- LAYOUT DIMENSIONS INDICATED ON THIS DRAWING ARE INTENDED TO BE UTILIZED FOR GUIDELINE PURPOSES ONLY. REFER TO MANUFACTURER'S INSTALLATION GUIDELINES FOR INSTALLATION TOLERANCES REQUIRED FOR SPECIFIC PLUMBING FIXTURES AND ACCESSORIES
- PLUMBING CONTRACTOR'S WORK TO END 10' FROM THE BUILDING. ALL CONNECTIONS TO SITE UTILITY PIPING SHALL BE PROVIDED BY THE PLUMBING CONTRACTOR.
- SEE P.01 FOR PLUMBING PRODUCT SPECIFICATIONS.

LEGEND

	FLOOR DRAIN (REFER TO PLUMBING DWG.)
	FLOOR SINK (REFER TO PLUMBING DWG.)
	FLOOR CLEANOUT (REFER TO PLUMBING DWG.)
	REFRIGERANT AND/OR ELECTRIC CONDUIT
	PLUMBING FIXTURE (REFER TO PLUMBING DWG.)
	CONCRETE SLAB IN-FILL

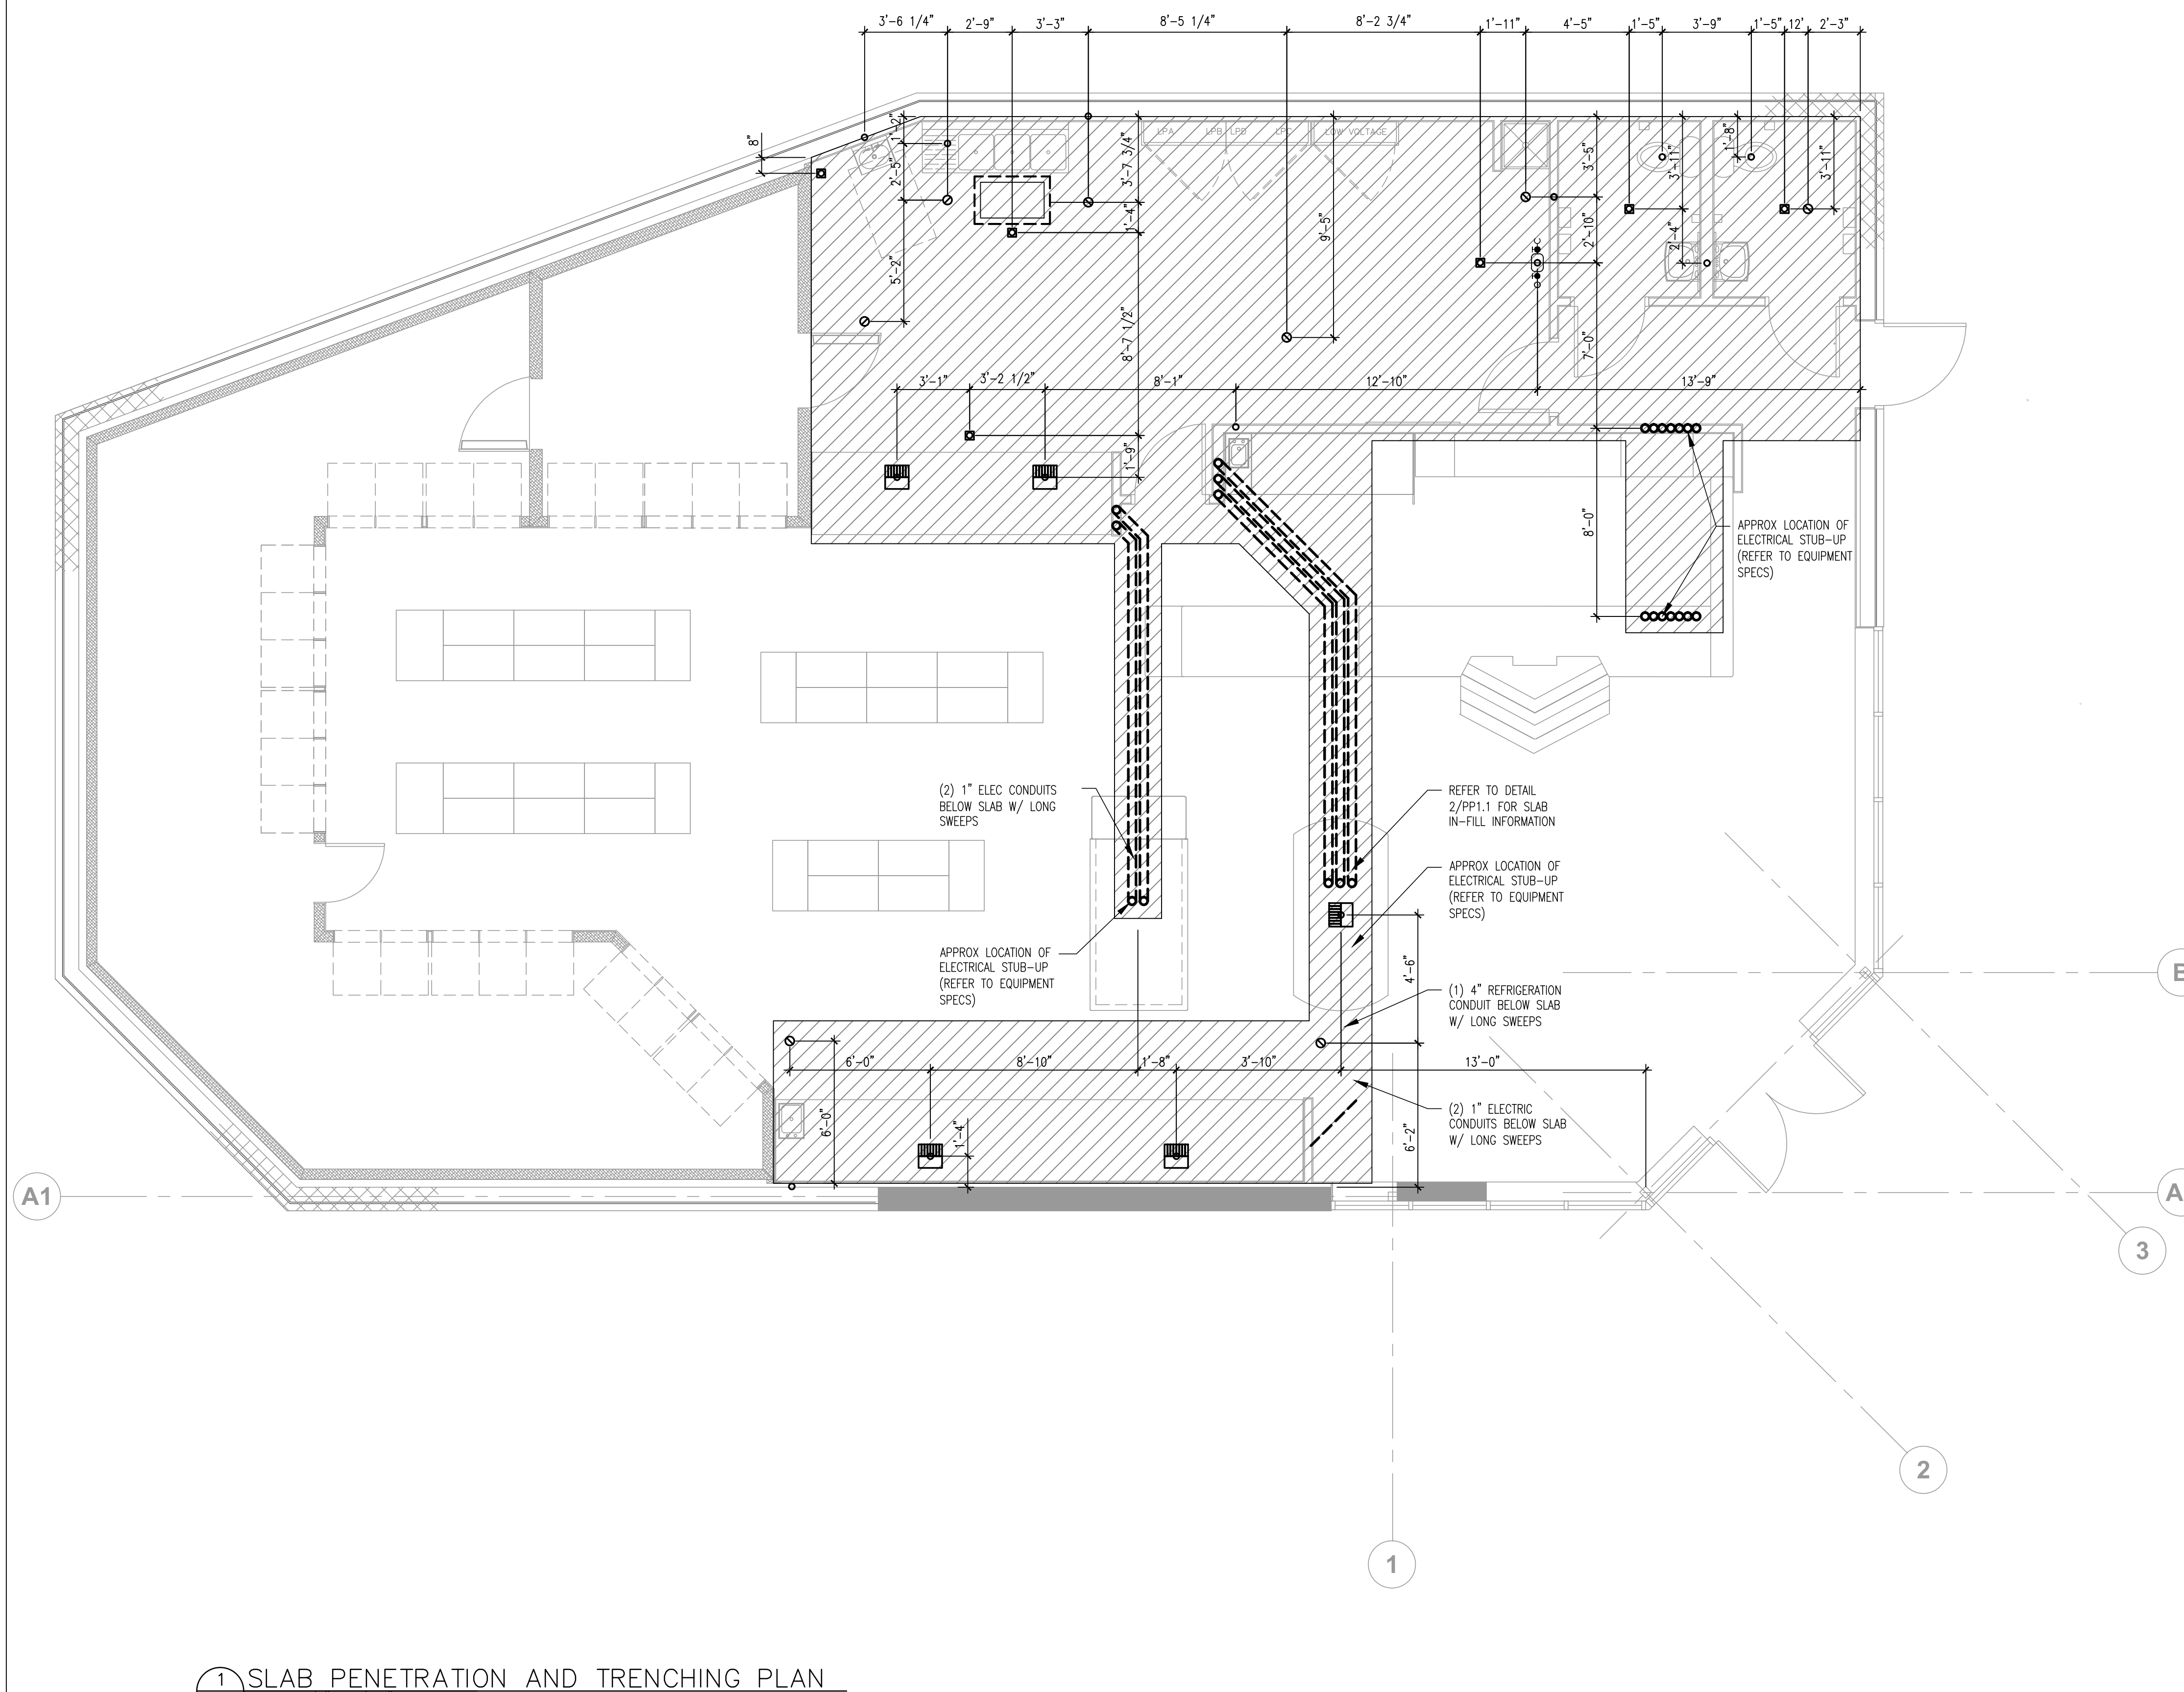

1 SLAB PENETRATION AND TRENCHING PLAN
PP1.1 SCALE: 1/4" = 1'-0"