


Revisions

No.	Date	Issued for
-	11/22/13	90% CD Review Set
-	01/24/14	Bid & Permit
1	03/18/14	Cashier Revisions
2	04/03/14	Addendum 01
3	04/07/14	Addendum 02

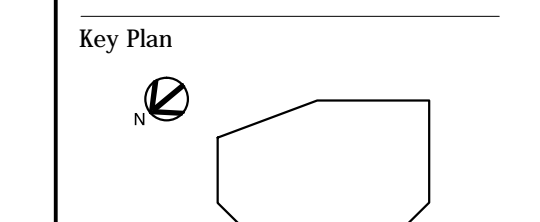

Title
REFLECTED CEILING PLAN

Date
Drawing No.

A1.3
Cumberland Farms
Project No. 2113119


REFLECTED CEILING PLAN LEGEND

	2'x2' RECESSED FLUORESCENT LIGHT		RECESSED EXTERIOR DOWN LIGHT		WALL MOUNTED LINEAR SUPPLY DIFFUSER		CEILING MOUNTED AUDIBLE/VISUAL DEVICE		LIGHT FIXTURE WITH EMERGENCY BALLAST
	2'x4' RECESSED FLUORESCENT LIGHT		RECESSED INTERIOR DOWN LIGHT WITH LENS		LINEAR SUPPLY DIFFUSER		CEILING MOUNTED VISUAL DEVICE		REMOTE TEST STATION & LED
	SURFACE MOUNTED FLUORESCENT LIGHT FOR COOLER/FREEZER		RECESSED INTERIOR DOWN LIGHT		SUPPLY DIFFUSER		MANUAL PULL STATION		FIRE ALARM RADIO MASTER BOX
	SURFACE MOUNTED LED DIRECTIONAL LIGHT		PENDANT COOLER LIGHT		RETURN AIR GRILLE		SMOKE DETECTOR		VINYL SOFFIT PANELS
	INTERNALLY ILLUMINATED EXTERIOR WALL MOUNTED SIGNAGE		TRACK LIGHT		CEILING MOUNTED		HEAT DETECTOR		GYP SUM WALLBOARD CEILING
	BATHROOM WALL MOUNTED VANITY FIXTURE		LIGHTING FIXTURE W/ EMERGENCY BALLAST		EXHAUST FAN		SURFACE MTD. EXTERIOREMERGENCY LIGHT		
							EXIT SIGN		
							RELAY		

REFLECTED CEILING PLAN KEY NOTES

- 01 NEW RECESSED CAN LIGHTS, TYP.
- 02 NEW VENTED VINYL CEILING PANEL.
- 03 EXISTING ALUMINUM SOFFIT AND FASCIA TO REMAIN.
- 04 NEW EXTERIOR LED LIGHT FIXTURE.

*NOTE: SEE DWG A0.3 FOR WALL TYPES & WALL FINISH SPECS
SEE DWG A1.5 FOR EQUIPMENT PLAN
SEE DWG A2.1 FOR DOOR SCHEDULE

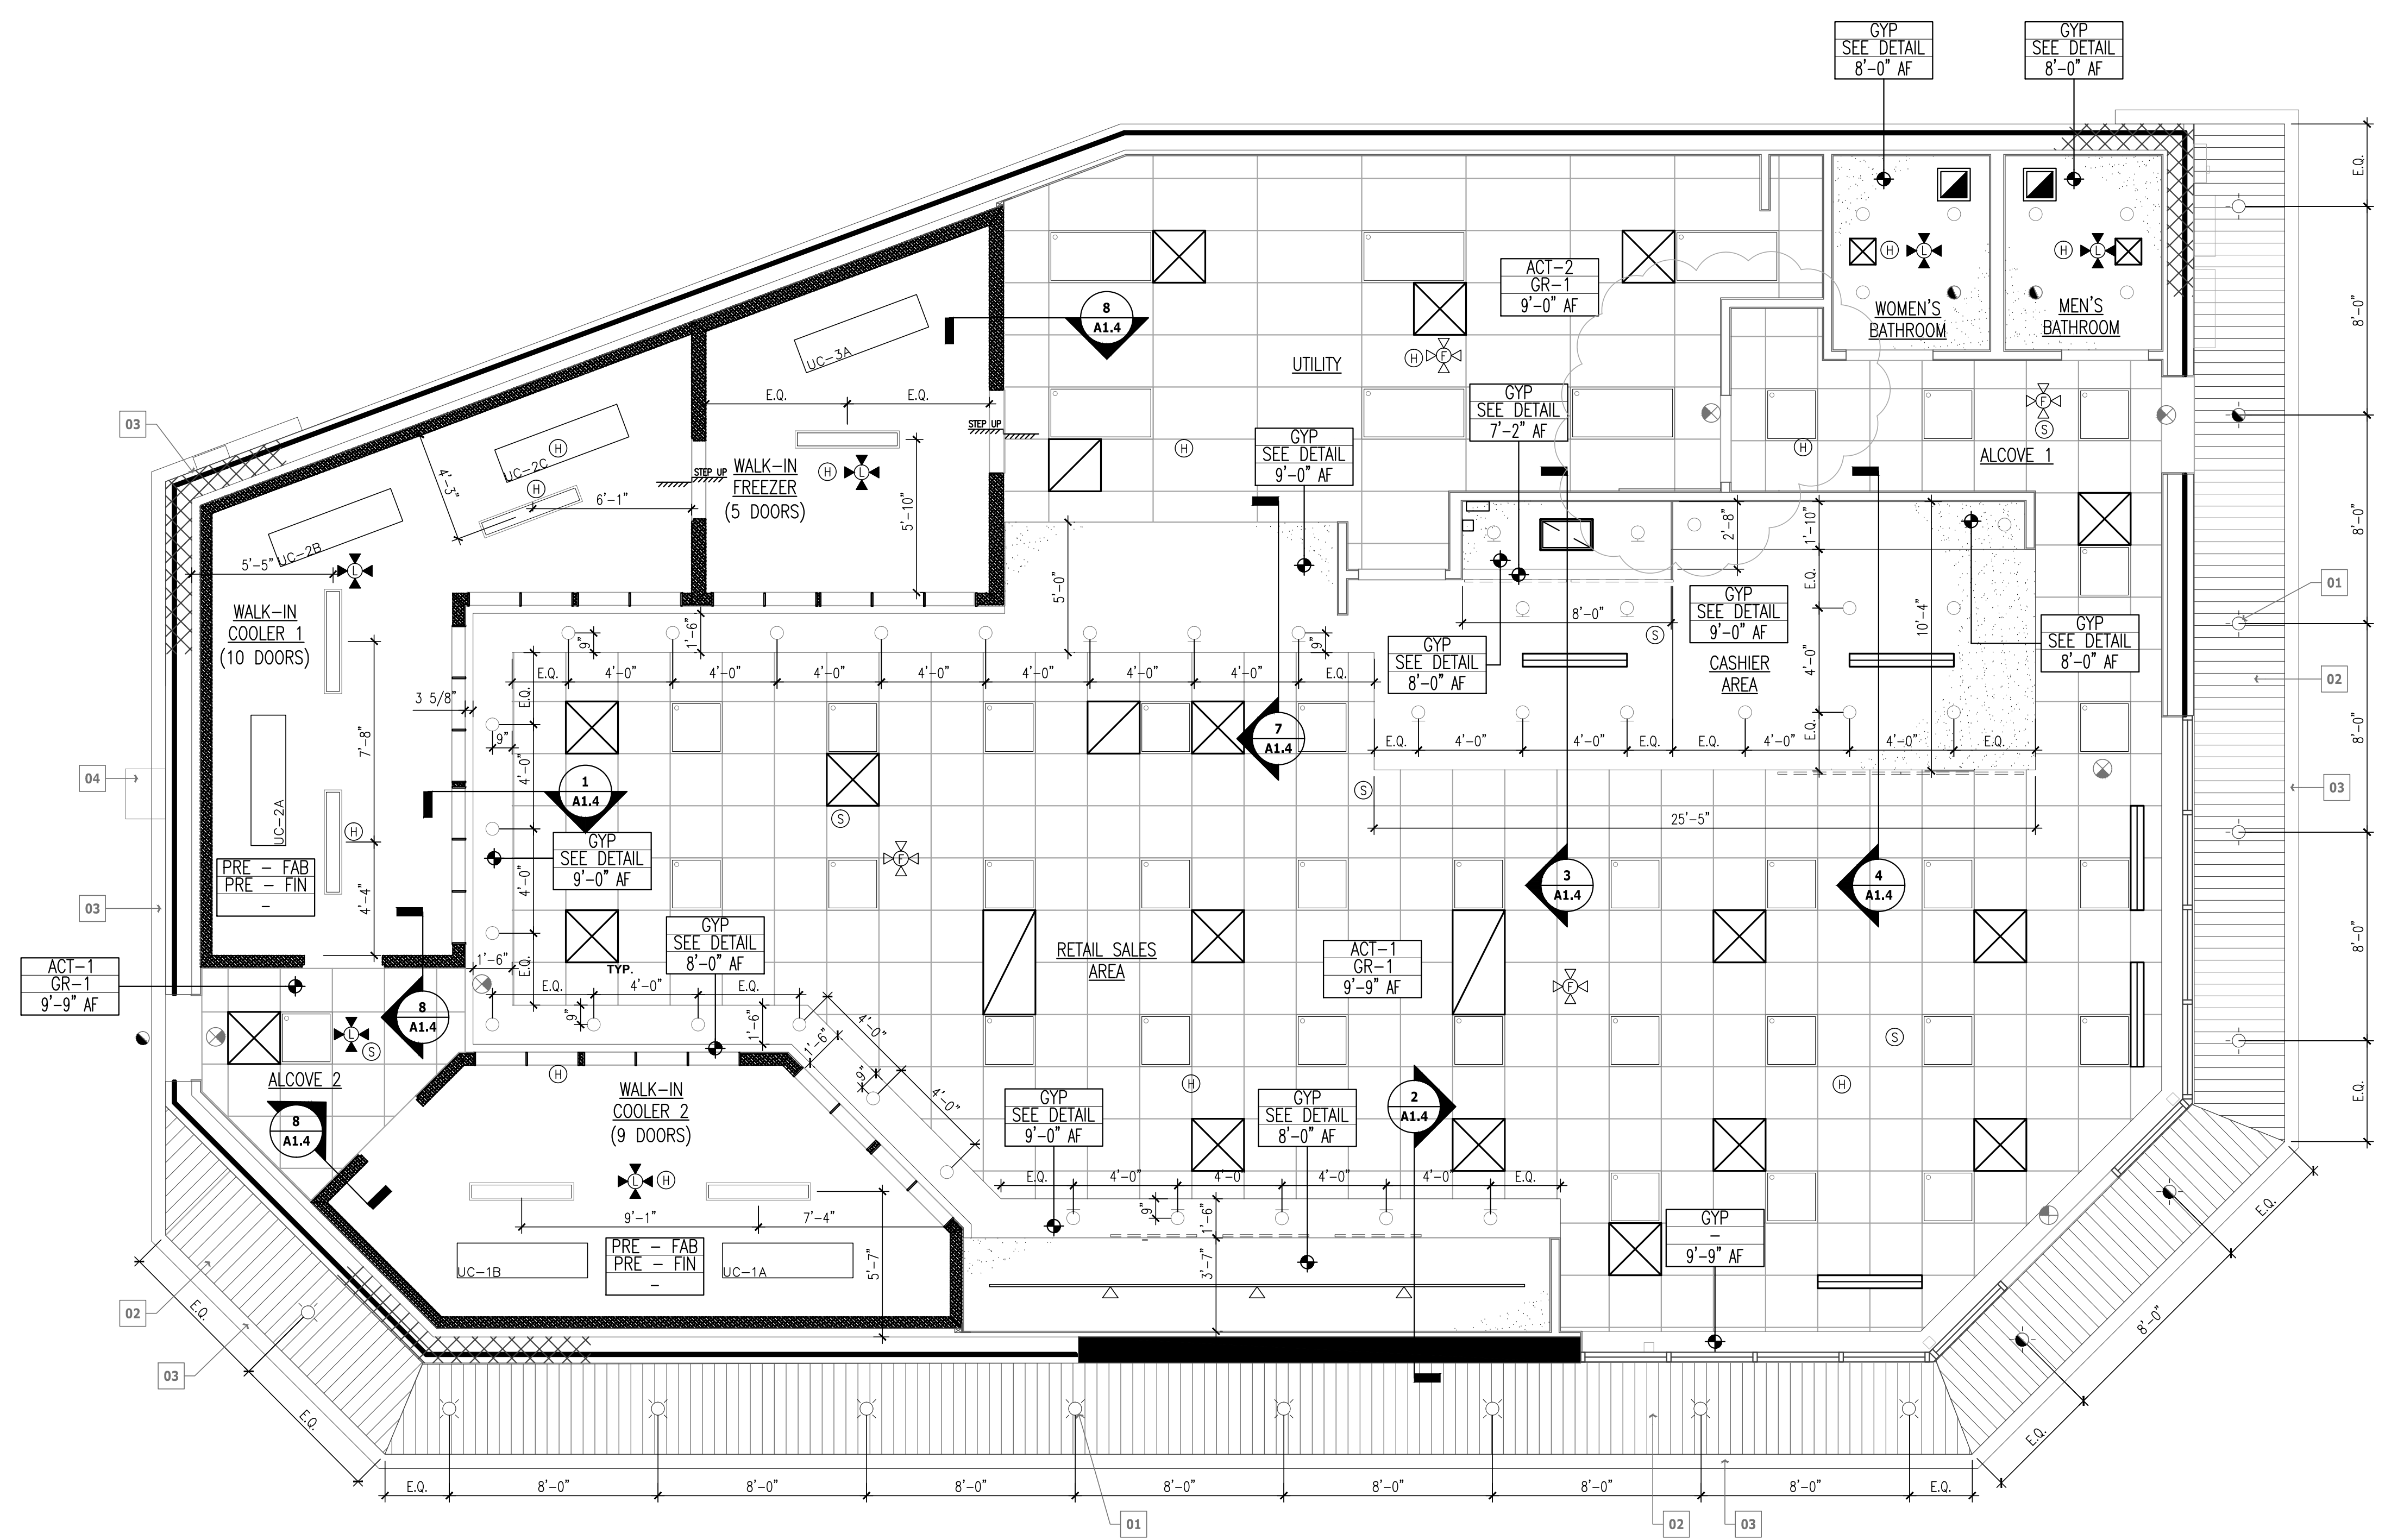

1 REFLECTED CEILING PLAN
A1.3 SCALE: 1/4" = 1'-0"