


DR MICHAEL BUFO... PROPOSED OFFICE LAYOUT

TELEPHONE & DATA SPECIFICATIONS

AUGUST 2, 2013

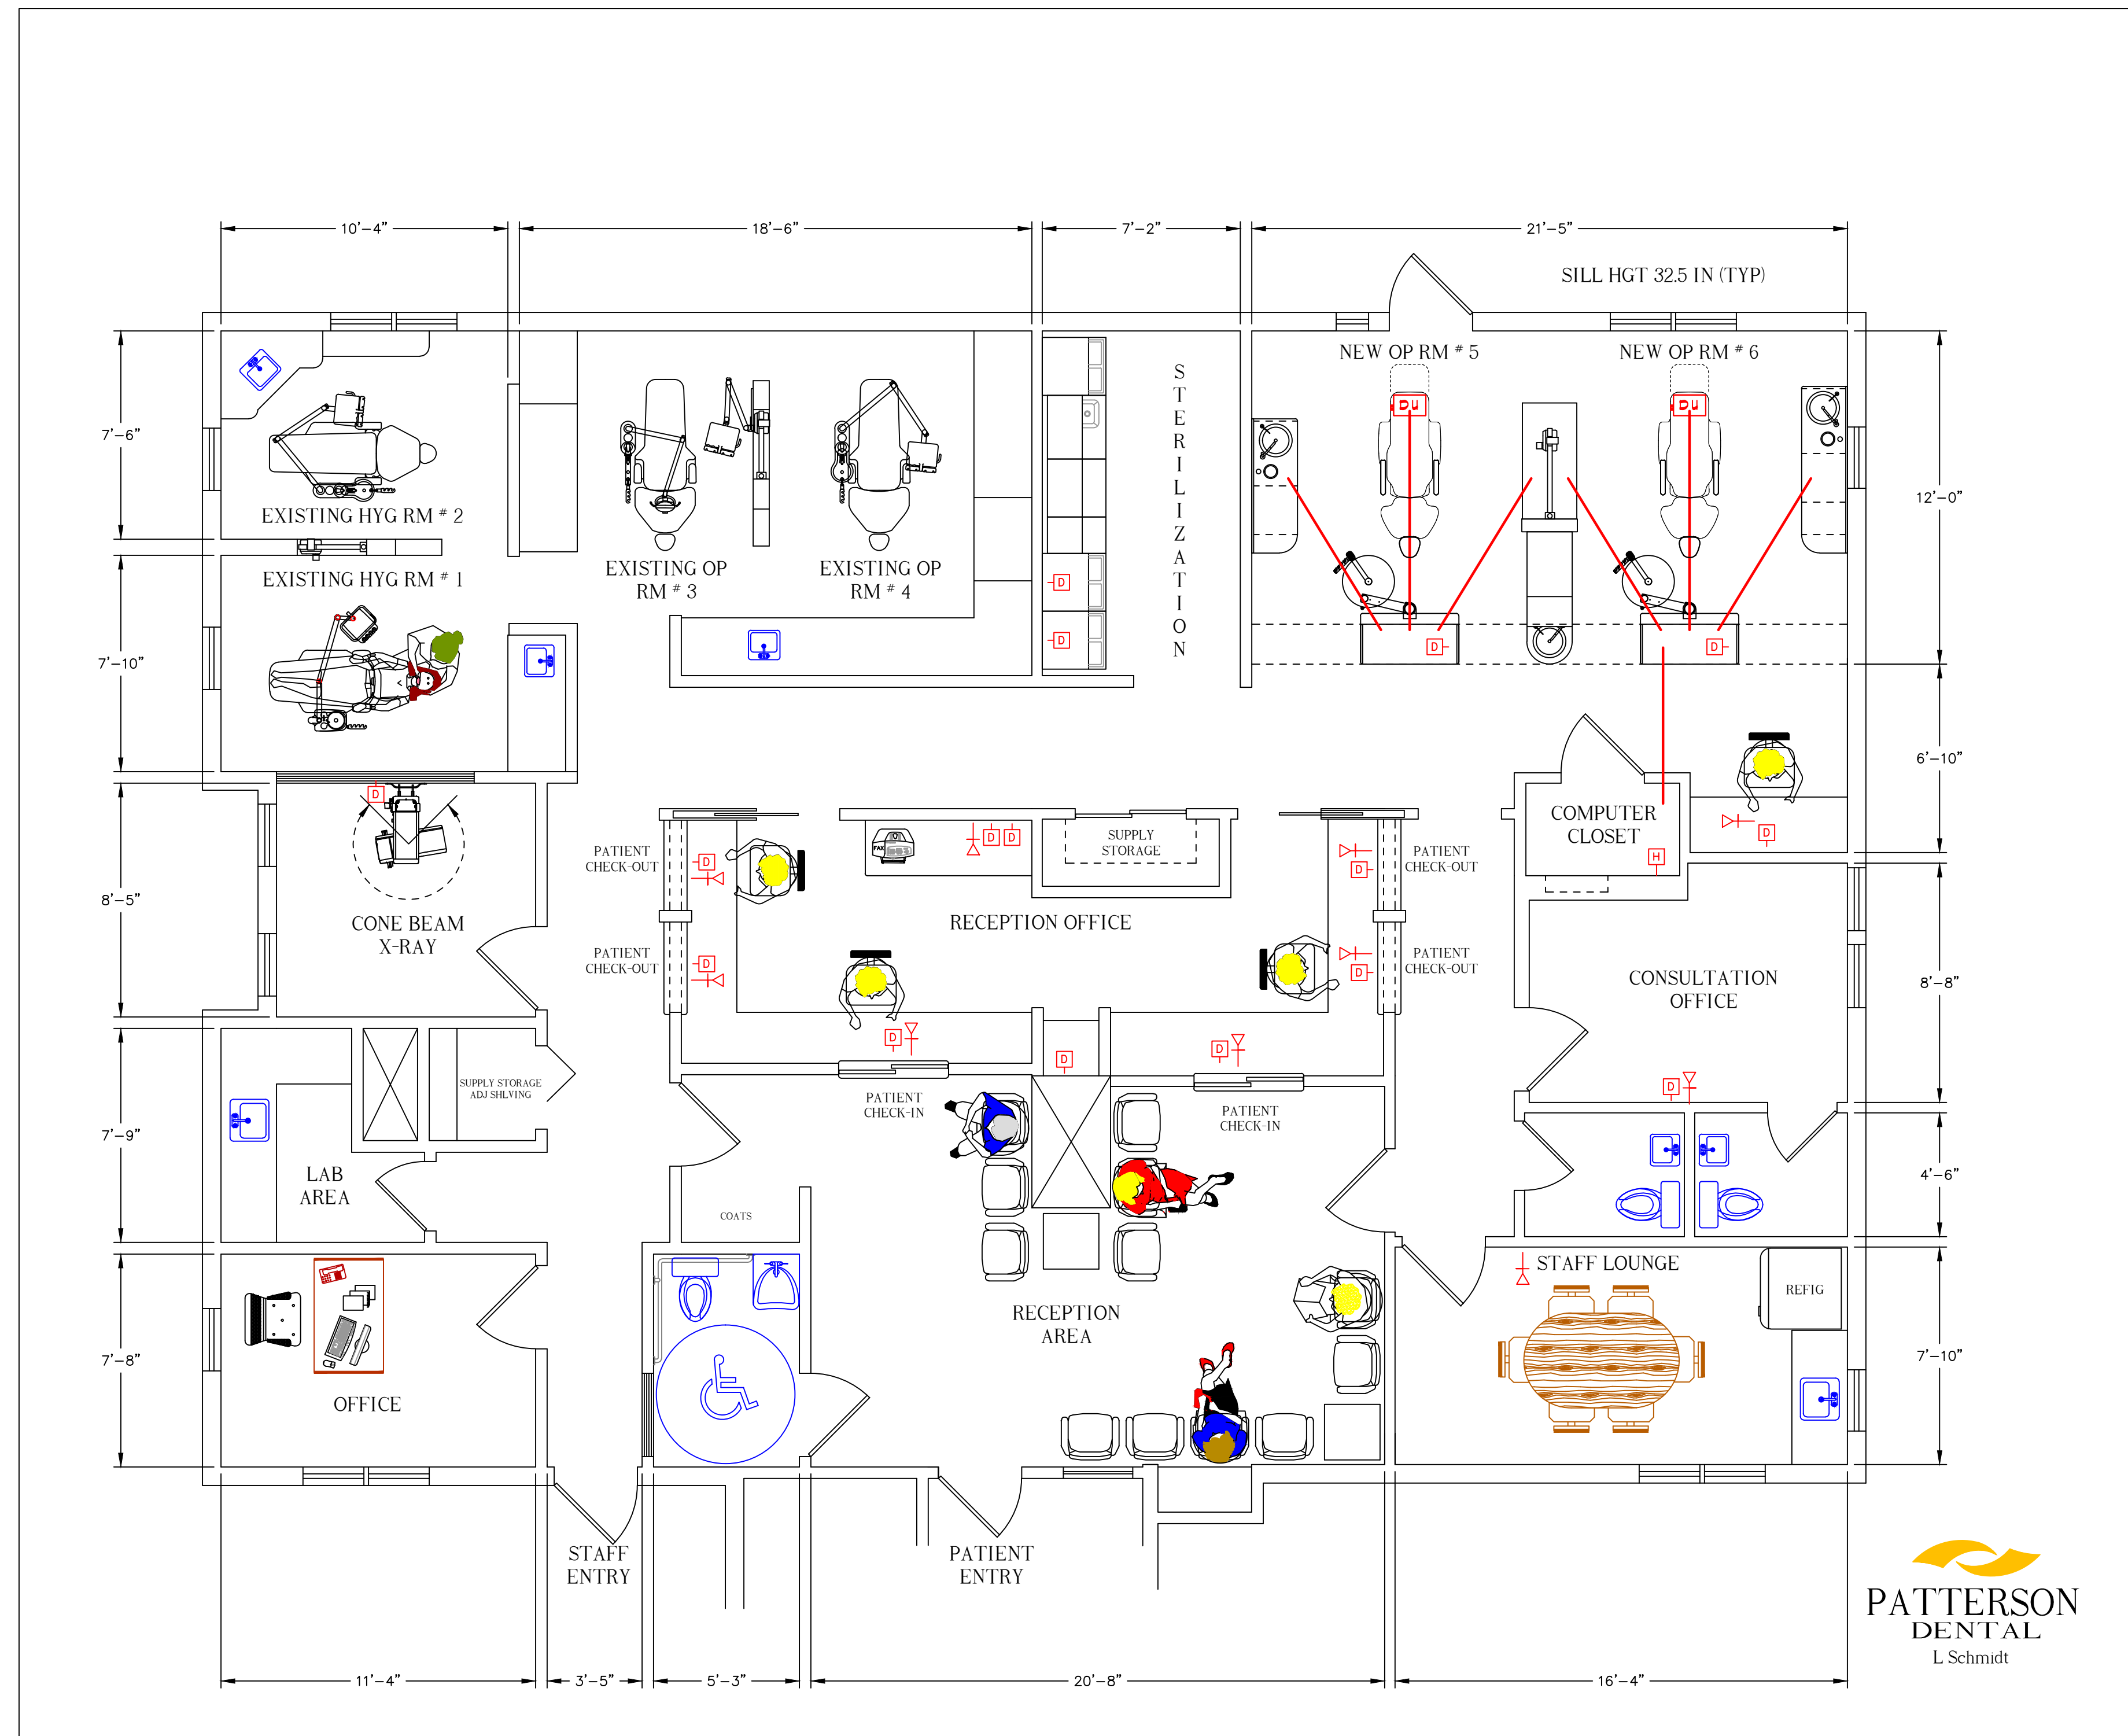

TELEPHONE & DATA SPECIFICATIONS	
	Electrician shall pull CAT6 (min) cables for data / computer system.
	TELEPHONE OUTLET - Verify height and locations with doctor.
	DATA TERMINATION POINT - Run CAT 6 min back to HUB / ROUTER
	COMPUTER HUB / ROUTER - Run all CAT6 min Data lines from this location. CONSULT WITH DR BUFO OR SEE THE PATTERSON DENTAL REPRESENTATIVE
	2 INCH CONDUIT - Run 2" PVC Pipe sub-slab as shown on plan to allow the ability to pull computer cables, etc between various pieces of dental equipment. See the Patterson Dental Rep.

202 Gannett Drive
South Portland, ME
800 639-1801



Designed by
L Schmidt


THESE DRAWINGS AND SPECIFICATIONS ARE THE PROPERTY OF PATTERSON DENTAL. NO PART OF THESE DRAWINGS OR SPECIFICATIONS ARE TO BE REPRODUCED, COPIED, OR TRANSMITTED IN ANY FORM OR BY ANY MEANS, ELECTRONIC OR MECHANICAL, INCLUDING PHOTOCOPYING, RECORDING, OR BY ANY INFORMATION STORAGE AND RETRIEVAL SYSTEM, WITHOUT THE WRITTEN PERMISSION OF PATTERSON DENTAL SUPPLY, INC. WRITTEN DIMENSIONS SHALL TAKE PREFERENCE OVER SCALE DIMENSIONS AND SHALL BE REFERRED TO IN THE EVENT OF A DISCREPANCY. THE CONTRACTOR SHALL BE RESPONSIBLE FOR ALL CURRENT AMERICAN PATTERSON DENTAL SUPPLY PRIOR TO THE COMMENCEMENT OF ANY WORK. THE CONTRACTOR SHALL ALSO BE RESPONSIBLE FOR ALL REQUIRED BACKFLOW PREVENTERS AND SHALL COMPLY WITH ALL STATE, CITY AND LOCAL CODES PERTAINING TO THE CONSTRUCTION OF THIS PROJECT.

DENTAL OFFICE BUILDING
DR M BUFO
612 BRIGHTON AVE
PORTLAND MAINE

DATE: AUGUST 2, 2013	SCALE: 1/4" = 1'-0"
REVISED	DATE:

SHEET NO.
D5
5 of 6

THESE DIAGRAMS ARE NOT AN ARCHITECTURAL PLAN. THESE DIAGRAMS ARE NOT DRAWN TO ARCHITECTURAL SCALE NOR DO THEY INCLUDE ALL OF THE REQUIREMENTS THAT MAY BE REQUIRED FOR AN ARCHITECT TO PROVIDE YOU WITH COMPLETE ARCHITECTURAL PLANS. PATTERSON'S DIAGRAMS MAY NOT BE SUBMITTED AS FINISHED ARCHITECTURAL DRAWINGS FOR THE PURPOSE OF OBTAINING A BUILDING PERMIT. IF YOU SHOULD CHOOSE TO USE PATTERSON'S DIAGRAM IN THE PLACEMENT OF YOU EQUIPMENT, YOU SHOULD RETAIN A REGISTERED ARCHITECT TO CONVERT THE DIAGRAM INTO PROPER AND COMPLETE ARCHITECTURAL PLANS. PATTERSON WILL WORK WITH THE ARCHITECT YOU SELECT TO DEVELOP COMPLETE ARCHITECTURAL PLANS.

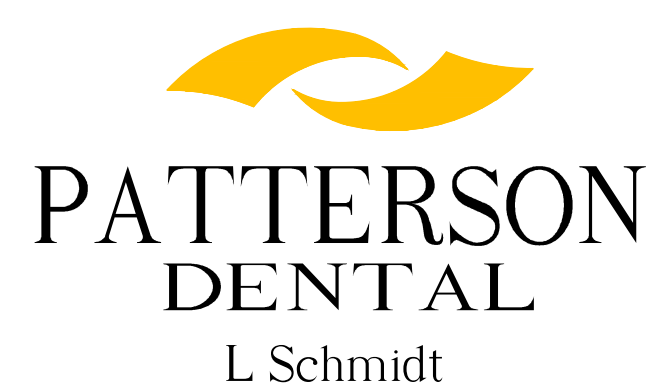

BUFO D5
Tel Data Plan
9/06/2013