



DRAWING TITLE:
PROPOSED 2ND FLOOR PLAN

PROJECT NAME:
COLLIN RESIDENCE
76 FRANCIS ST., PORTLAND MAINE

THIS DRAWING IS THE PROPERTY OF
LINDA BRALEY AND IS NOT TO BE
COPIED OR REPRODUCED IN PART OR
WHOLE. 2017 © LINDA BRALEY


DATE OF ISSUE
JULY 24, 2017
DESCRIPTION
CONCEPTUAL
SCALE
1/8" = 1'-0"
PROJECT NUMBER
2015-0400

A102

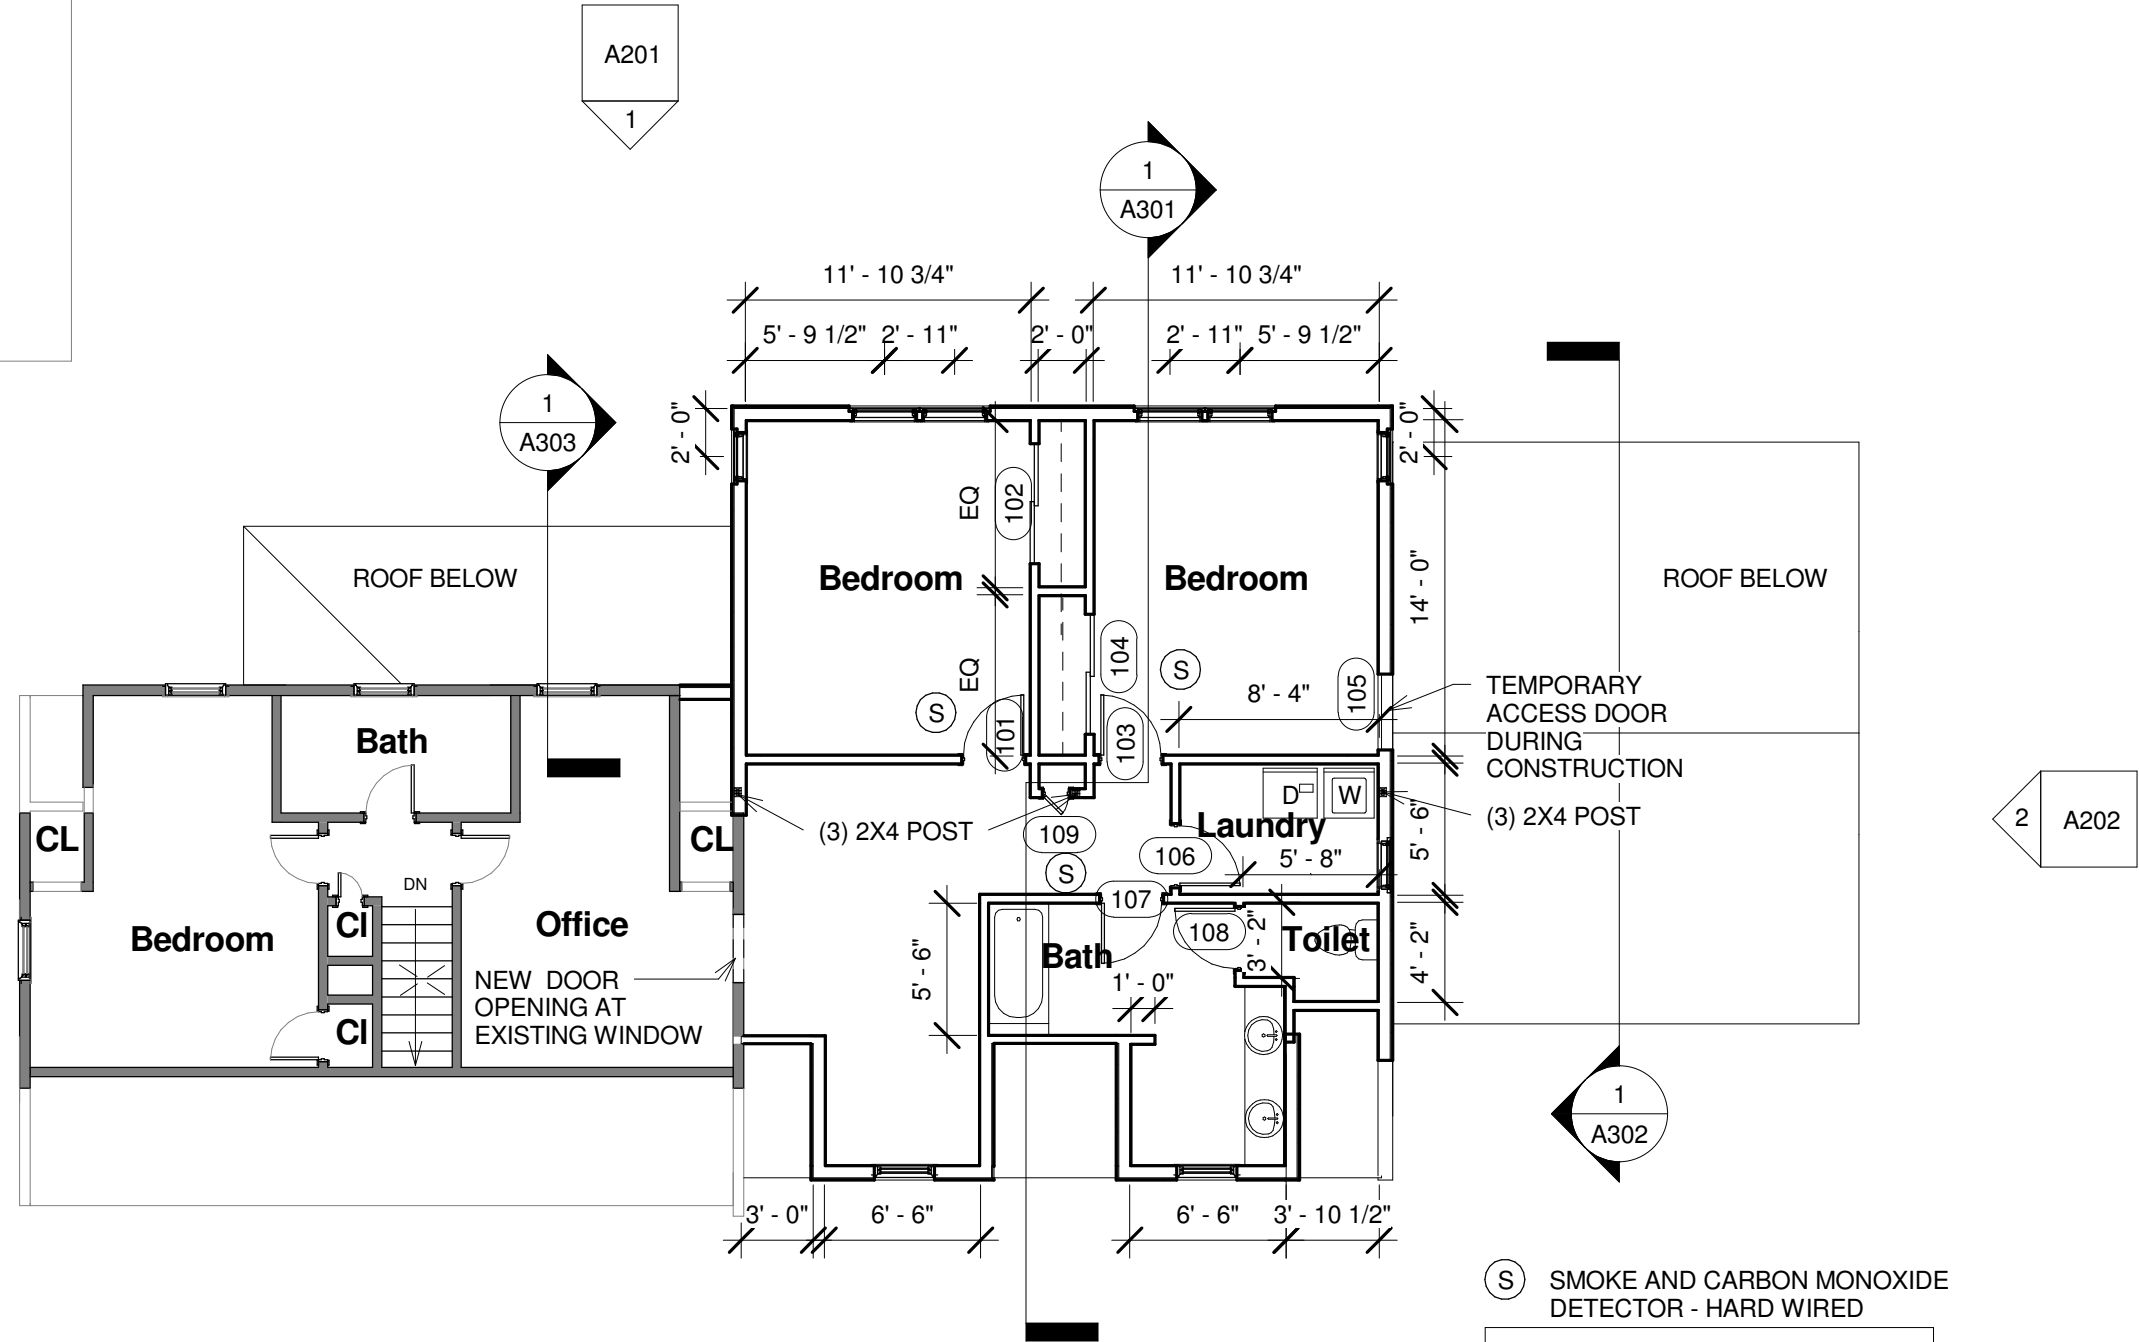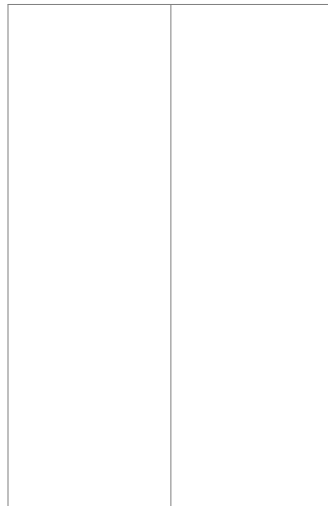

(S) SMOKE AND CARBON MONOXIDE
DETECTOR - HARD WIRED

 ALL PLUMBING FIXTURES BY
OWNER, VERIFY LOCATION



1 SECOND FLOOR
A102 1/8" = 1'-0"

