

DRAWING STATUS
 OFFICE REVIEW
 CLIENT REVIEW
 PERMIT REVIEW
 BID SET
 CONTRACT DRAWING
 CONSTRUCTION

No drawing shall be recognized as a construction document unless it bears a blue inked registration seal.

SHEET TITLE
SECOND FLOOR REFLECTED CEILING PLAN

JOB NO.
 201512

DRAWN BY
 EBJ

CHECKED BY
 TRN


SCALE
 AS NOTED

ORIGINAL DATE
 09-19-2016

REVISION DATE
 10-19-16

SHEET

A402

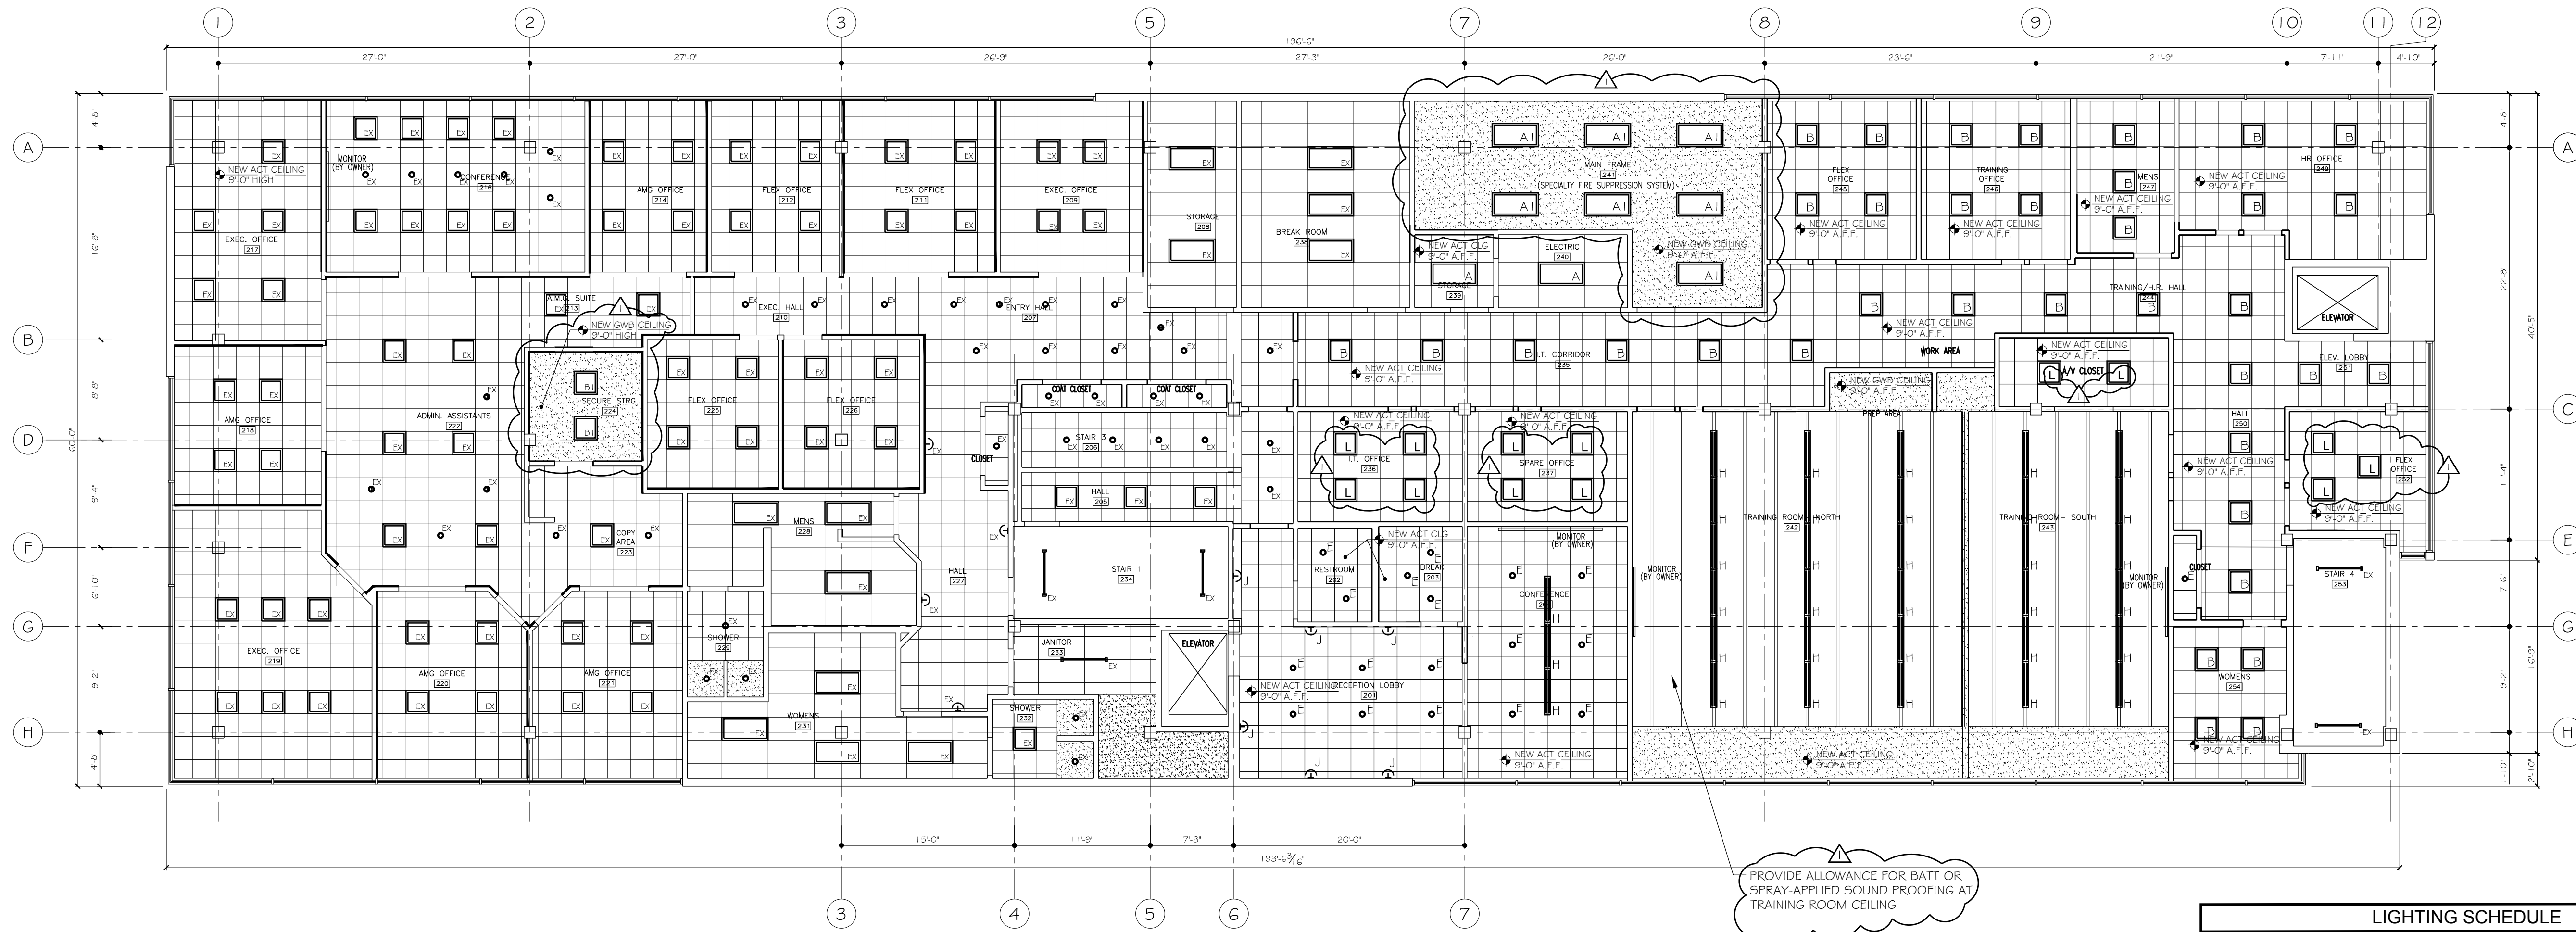

LIGHTING SCHEDULE	
	LIGHTING FIXTURE TYPE A = 2' x 4' RECESSED LED SPEC: LITHONIA LIGHTING P27TL2-40L-ADP-EZ1-1P835-00A24F5(T)
	LIGHTING FIXTURE TYPE AI = 2' x 4' SURFACE-MOUNTED LED SPEC: LITHONIA LIGHTING P27TL2-40L-ADP-EZ1-1P835-00A24F5(T)
	LIGHTING FIXTURE TYPE B = 2' x 2' RECESSED LED SPEC: LITHONIA LIGHTING P27TL2-33L-ADP-EZ1-1P835-00A24F5(T)
	LIGHTING FIXTURE TYPE BI = 2' x 2' SURFACE-MOUNTED LED SPEC: LITHONIA LIGHTING P27TL2-33L-ADP-EZ1-1P835-00A24F5(T)
	LIGHTING FIXTURE TYPE C = INTERIOR WALL-MOUNTED LED SCONCE SPEC: NOT USED
	LIGHTING FIXTURE TYPE D = INTERIOR WALL-MOUNTED LED SCONCE SPEC: NOT USED
	LIGHTING FIXTURE TYPE E = 4' RECESSED INTERIOR LED DOWNLIGHT SPEC: ATLANTIC LIGHTING PLED4-DLM20-35K-1-LIDE-3LED-0-WH
	LIGHTING FIXTURE TYPE F = 4' RECESSED ADJUSTABLE LED DOWNLIGHT SPEC: ATLANTIC PLED4-DLM20-35K-1-LIDE-3LED-0-WH
	LIGHTING FIXTURE TYPE G = 48' INTERIOR STRIP LIGHT SPEC: LINAK #UCM114-LED-1P615-SW
	LIGHTING FIXTURE TYPE H = 48' INTERIOR UPDOWN LINEAR LIGHT SPEC: LUMENWORKS #SMHTEL-RMCH-LED-247-750-500-35-4-LIN-0-1-1-33WAC3-6W
	LIGHTING FIXTURE TYPE J = RE-USE EXISTING INTERIOR WALL-MOUNTED SCONCE SPEC: EXISTING FIXTURES RETAINED FROM SECOND FLOOR
	LIGHTING FIXTURE TYPE K = RE-USE EXISTING 48' UPDOWN LINEAR LIGHT SPEC: EXISTING FIXTURES RETAINED FROM THIRD FLOOR
	LIGHTING FIXTURE TYPE L = RE-USE EXISTING 2' x 2' RECESSED FIXTURES SPEC: EXISTING FIXTURES RETAINED FROM THE SECOND & THIRD FLOORS

**BID DOCUMENTS
 NOT FOR CONSTRUCTION**