

DRAWING STATUS

- OFFICE REVIEW
- CLIENT REVIEW
- PERMIT REVIEW
- BID SET
- CONTRACT DRAWING
- CONSTRUCTION

No drawing shall be recognized as a construction document unless it bears a blue inked registration seal.

SHEET TITLE
THIRD FLOOR REFLECTED CEILING PLAN

JOB NO.
 201512

DRAWN BY
 EBJ


CHECKED BY
 TRN

SCALE
 AS NOTED

ORIGINAL DATE
 09-19-2016

REVISION DATE
 10-19-16

SHEET
A403

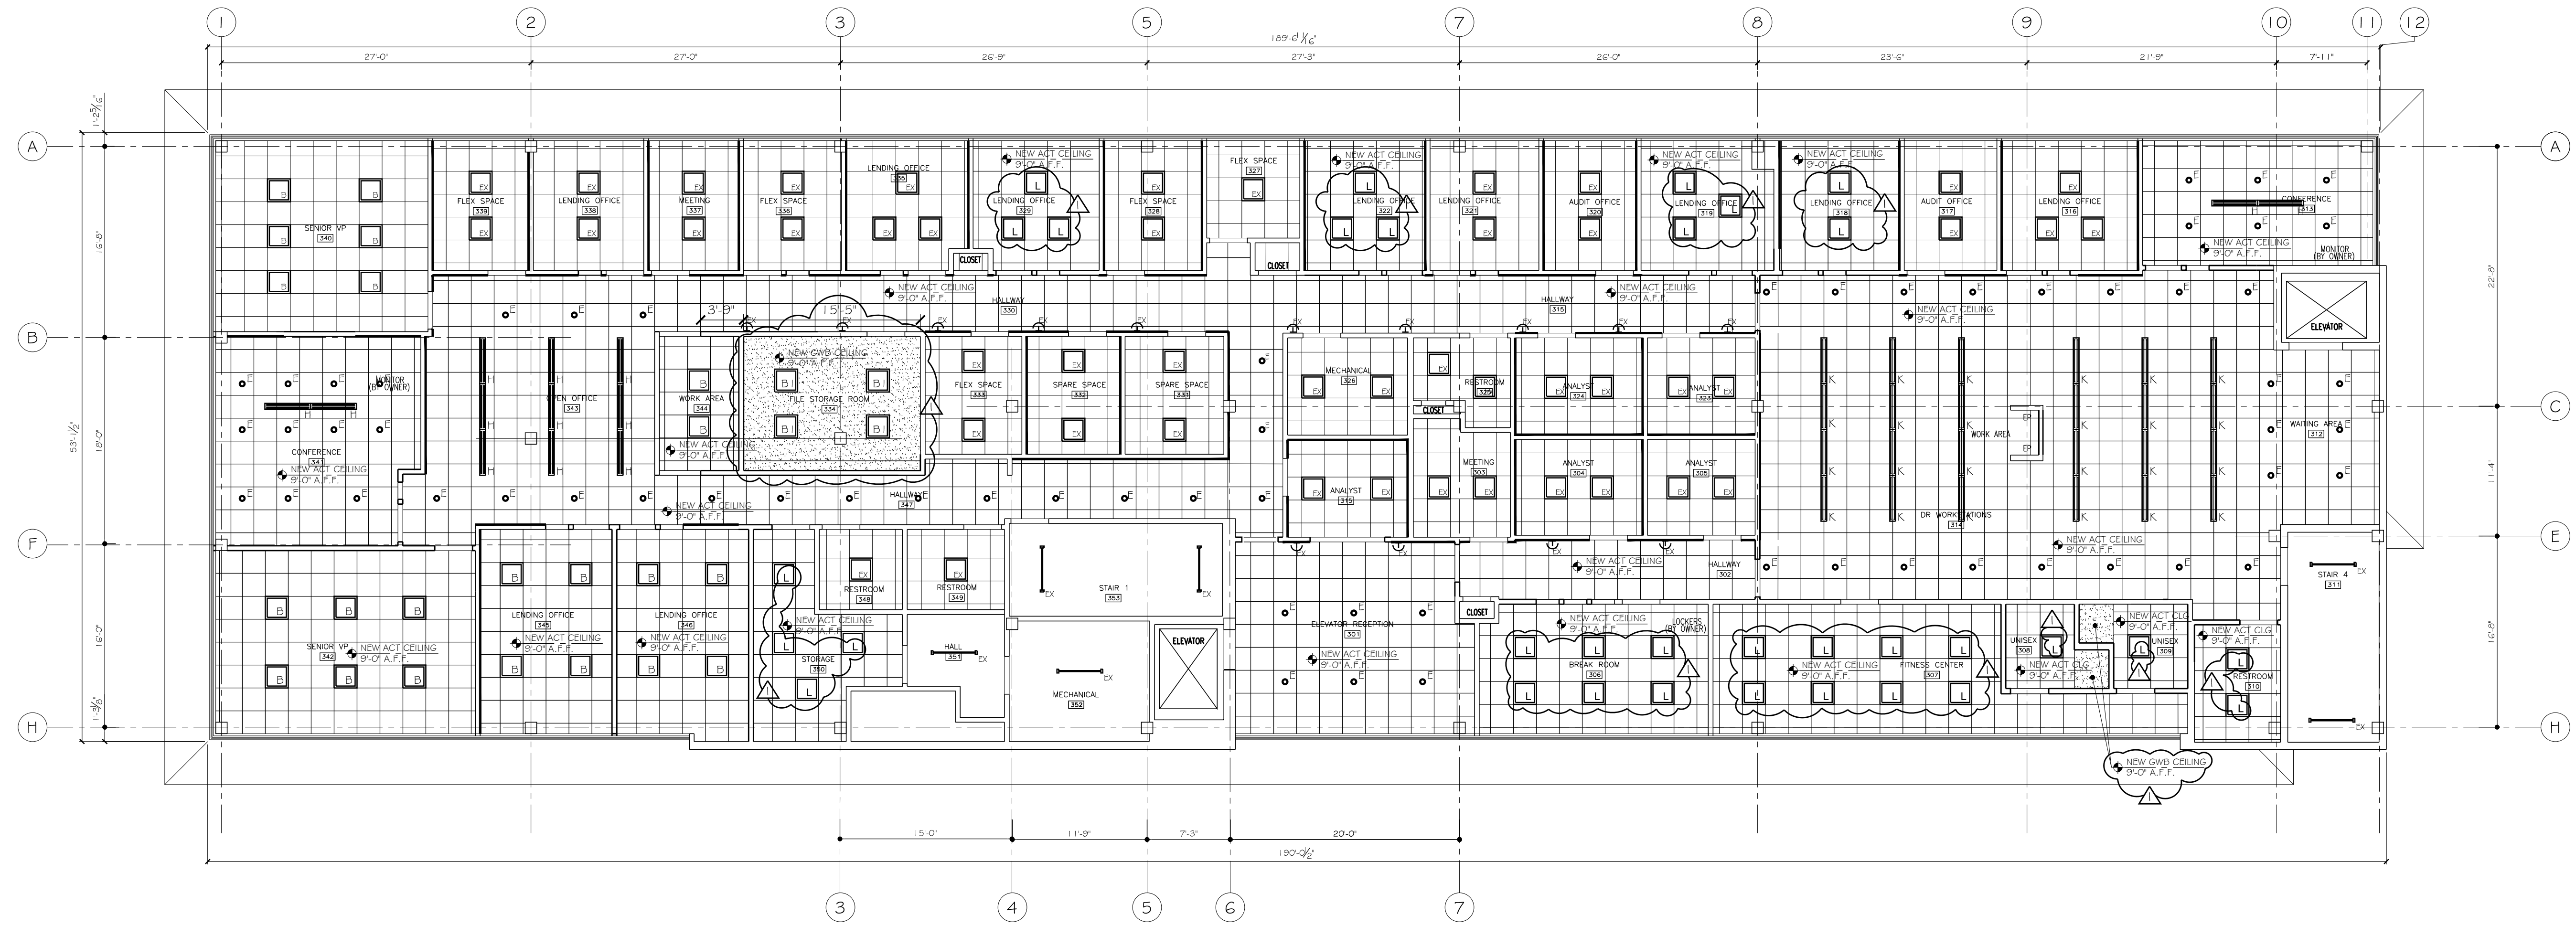

LIGHTING SCHEDULE	
	LIGHTING FIXTURE TYPE A = 2' x 4' RECESSED LED SPEC: LITRONA LIGHTING #20TL2-40L-40R-E21-UP35V
	LIGHTING FIXTURE TYPE AI = 2' x 4' SURFACE MOUNTED LED SPEC: LITRONA LIGHTING #20TL2-40L-40R-E21-UP35V-DGAS4F5T1
	LIGHTING FIXTURE TYPE B = 2' x 2' RECESSED LED SPEC: LITRONA LIGHTING #20TL2-35L-40R-E21-UP35V
	LIGHTING FIXTURE TYPE BI = 2' x 2' SURFACE MOUNTED LED SPEC: LITRONA LIGHTING #20TL2-35L-40R-E21-UP35V-DGAS4F5T1
	LIGHTING FIXTURE TYPE C = INTERIOR WALL-MOUNTED LED SCIENCE SPEC: NOT USED
	LIGHTING FIXTURE TYPE D = INTERIOR WALL-MOUNTED LED SCIENCE SPEC: NOT USED
	LIGHTING FIXTURE TYPE E = 4" RECESSED INTERIOR LED DOWNLIGHT SPEC: ATLANTIC LIGHTING #ED4-10M20-35K-U-1DE-4LED10-WH
	LIGHTING FIXTURE TYPE F = 4" RECESSED ADJUSTABLE LED DOWNLIGHT SPEC: ATLANTIC LIGHTING #ED4-10M20-35K-U-1DE-4LED10-WH
	LIGHTING FIXTURE TYPE G = 48" INTERIOR STRIP LIGHT SPEC: LUMAX #UCM114-801PC-10-SW
	LIGHTING FIXTURE TYPE H = 48" INTERIOR UP/DOWN LINEAR LIGHT SPEC: LUMAX #UCM114-801PC-10-SW
	LIGHTING FIXTURE TYPE J = RE-USE EXISTING INTERIOR WALL-MOUNTED SCIENCE SPEC: EXISTING FIXTURES RETAINED FROM SECOND FLOOR
	LIGHTING FIXTURE TYPE K = RE-USE EXISTING 48" UP/DOWN LINEAR LIGHT SPEC: EXISTING FIXTURES RETAINED FROM THIRD FLOOR
	LIGHTING FIXTURE TYPE L = RE-USE EXISTING 2' x 2' RECESSED FIXTURES SPEC: EXISTING FIXTURES RETAINED FROM THE SECOND & THIRD FLOORS

**BID DOCUMENTS
 NOT FOR CONSTRUCTION**