

DRAWING STATUS

<input type="checkbox"/>	OFFICE REVIEW
<input type="checkbox"/>	CLIENT REVIEW
<input type="checkbox"/>	PERMIT REVIEW
<input checked="" type="checkbox"/>	BID SET
<input type="checkbox"/>	CONTRACT DRAWING
<input type="checkbox"/>	CONSTRUCTION

No drawing shall be recognized as a construction document unless it bears a blue inked registration seal.

SHEET TITLE  
**SECOND FLOOR  
 POWER & DATA  
 PLAN**

JOB NO.  
 201512

DRAWN BY  
 TRN


SCALE  
 AS NOTED

ORIGINAL DATE  
 09-19-2016

REVISION DATE  
 10-03-16

SHEET  
**E102**

INSB-1200 CONGRESS CONDOCS  
 ARCHPLANS 1010-FLOORPLANS.DWG

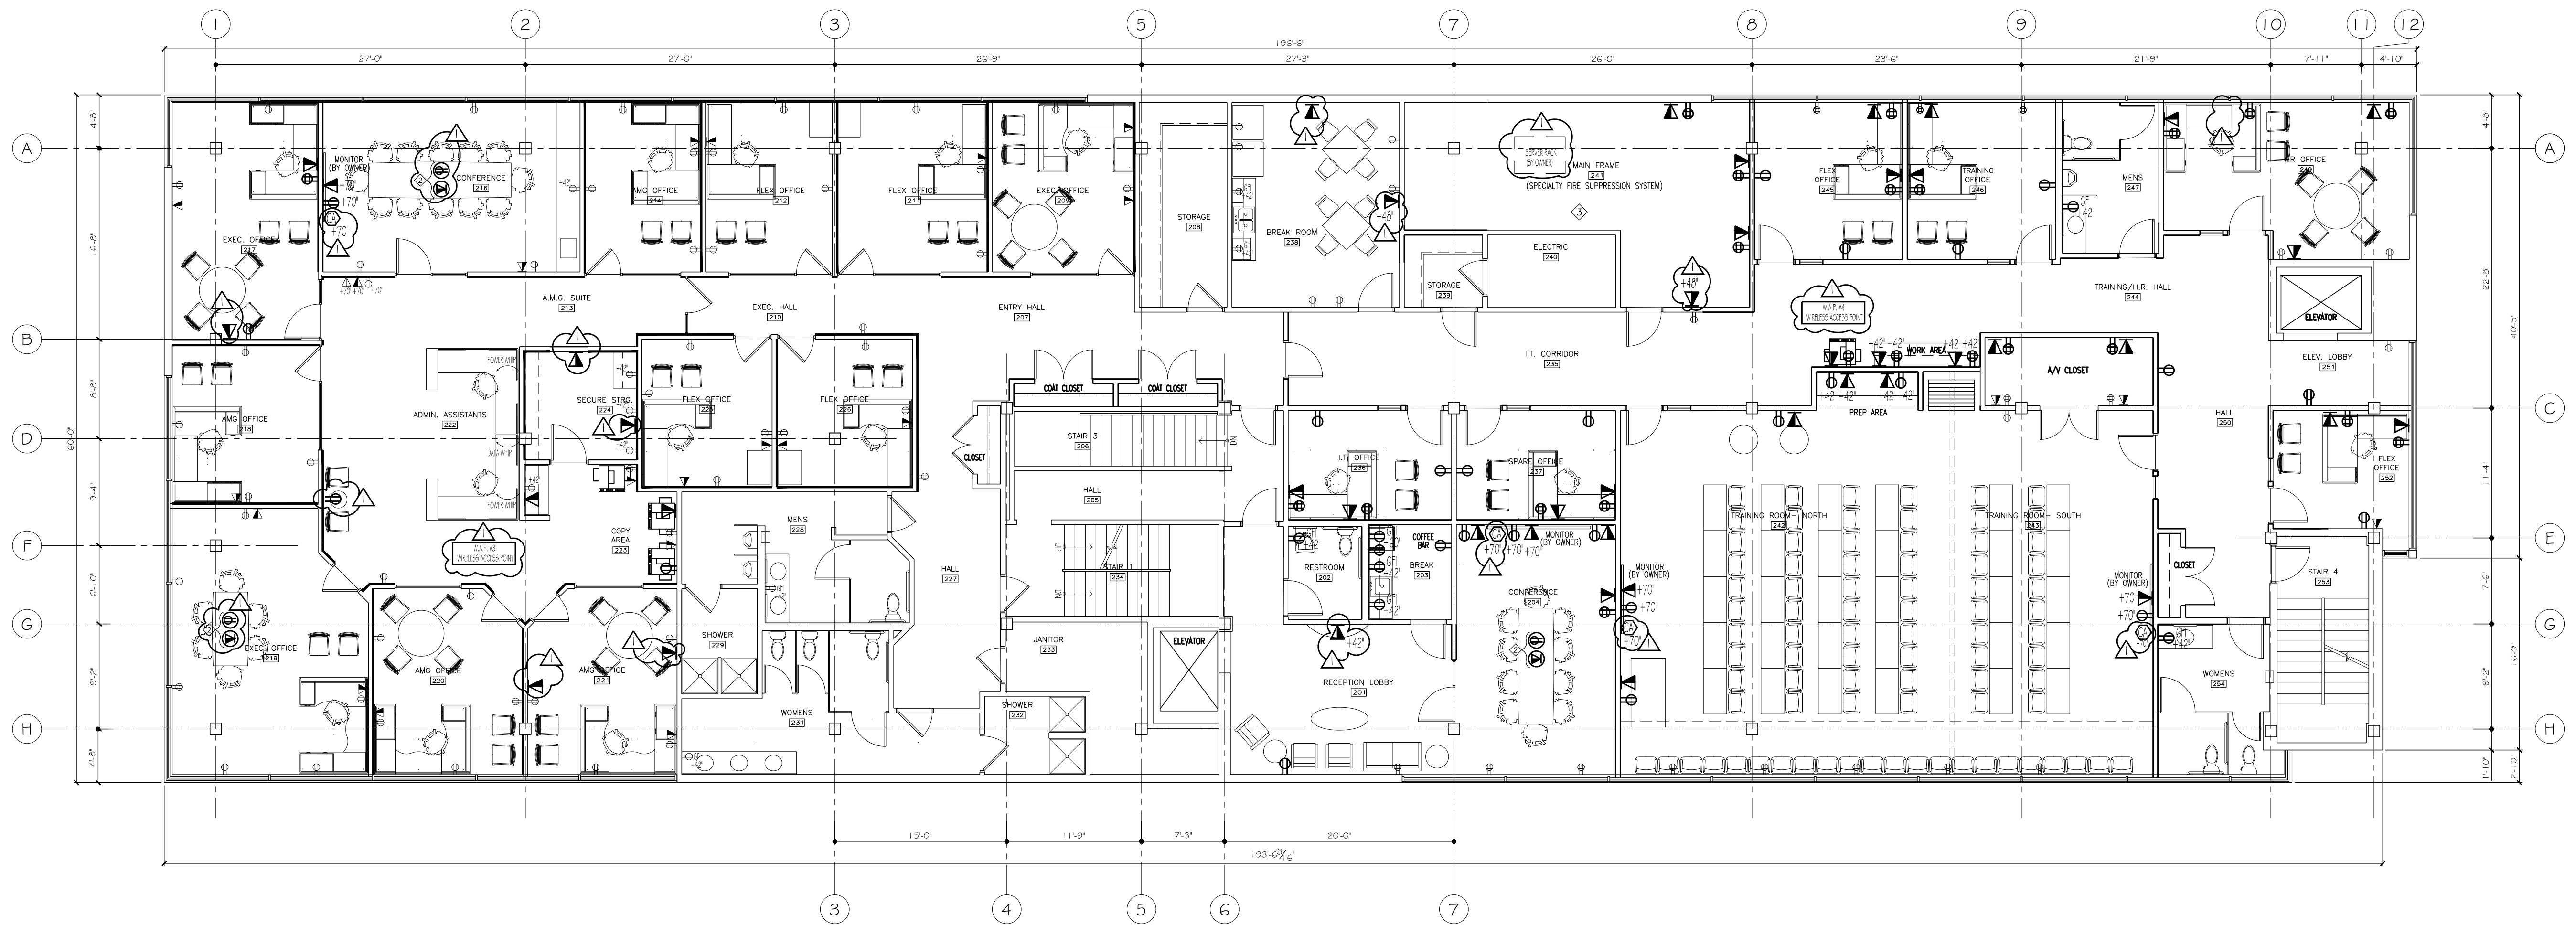


GENERAL DATA NOTE:

- 1. A - EXISTING DATA POINTS TO REMAIN SHALL BE NEW IN-WALL DUP EX JA K (WHITE COVER)

KEYED POWER/DATA NOTES:

- ◇ COORDINATION OF FLOOR OUT ETS/DATA WITH ARCHITECT
- ◇ COORDINATION OF IN-CABINET/FLOOR OUT ETS/DATA WITH ARCHITECT
- ◇ 3" CONDUIT TO DATA ROOM

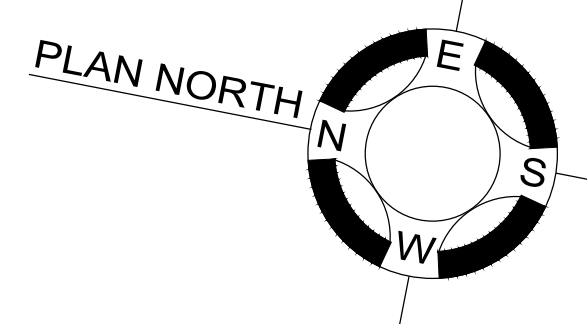

**1** SECOND FLOOR POWER & DATA PLAN  
 SCALE: 1/8" = 1'-0"

**BID DOCUMENTS  
 NOT FOR CONSTRUCTION**