

<input type="checkbox"/>	OFFICE REVIEW
<input type="checkbox"/>	CLIENT REVIEW
<input type="checkbox"/>	PERMIT REVIEW
<input type="checkbox"/>	BID SET
<input checked="" type="checkbox"/>	CONTRACT DRAWING
<input type="checkbox"/>	CONSTRUCTION

No drawing shall be recognized as a construction document unless it bears a blue inked registration seal.

SHEET TITLE  
**THIRD FLOOR  
 POWER & DATA  
 PLAN**

JOB NO.  
**201512**

DRAWN BY  
**EBJ**

CHECKED BY  
**TRN**

SCALE  
**AS NOTED**


ORIGINAL DATE  
**09-16-2016**

REVISION DATE  
**10-03-16**

SHEET

**E103**

INSB-1200 CONGRESS CONCOURSE  
 ARCH PLANS 1010-FLOOR PLANS.DWG

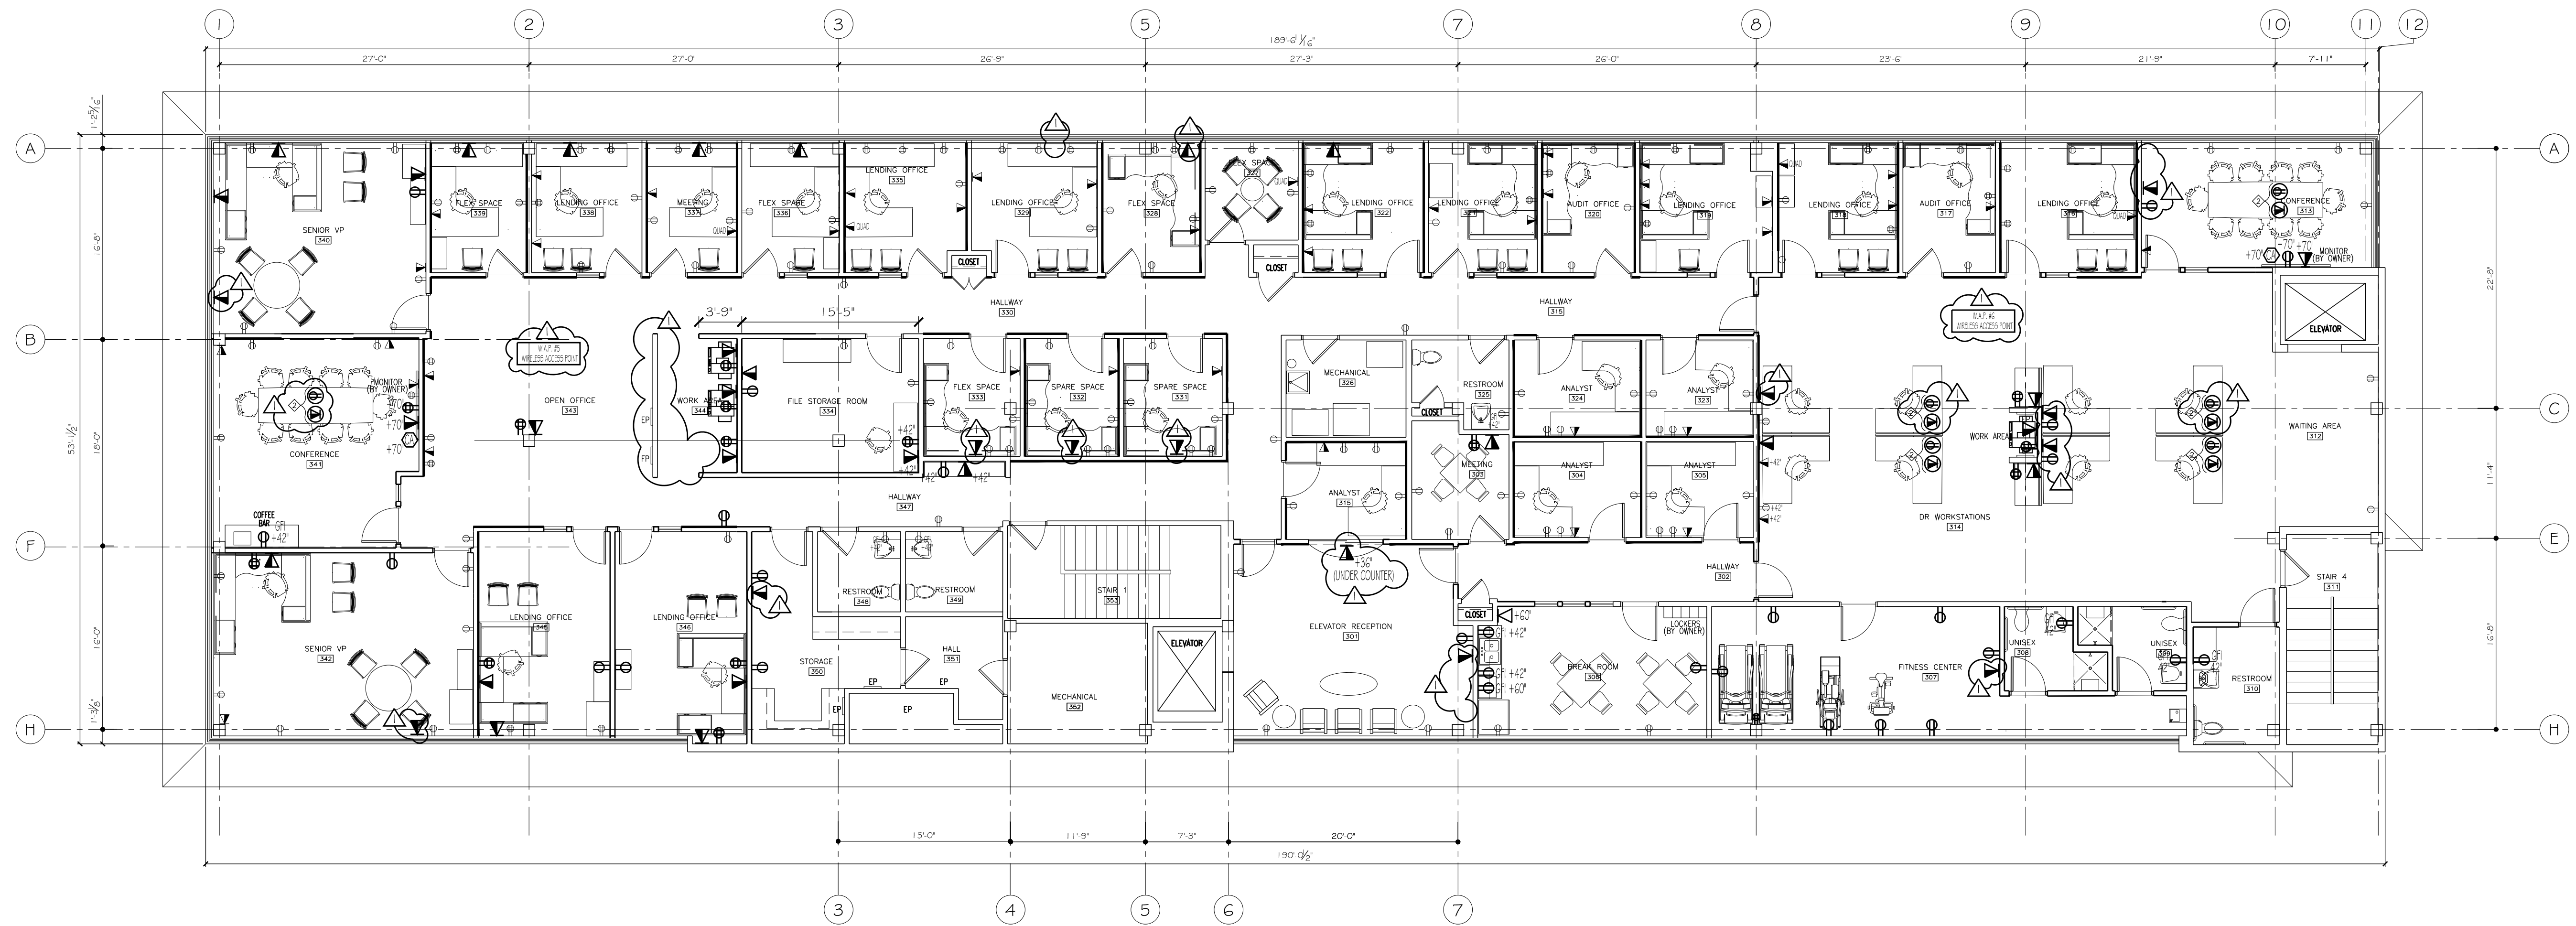


**GENERAL DATA NOTE:**

- 1. A - EXISTING DATA LOCATIONS TO REMAIN SHALL RECEIVE NEW IN-WALL DUP EX-JACK (WHITE COVER)

**KEYED POWER/DATA NOTES:**

- ◇ COORDINATE LOCATION OF FLOOR OUTLET DATA WITH ARCHITECT
- ◇ COORDINATE LOCATION OF IN-CABINET/FLOOR OUTLET DATA WITH ARCHITECT
- ◇ RELOCATED EXISTING OUTLET DATA RECEPTACLE
- ◇ 1' CONDUIT TO DATA ROOM

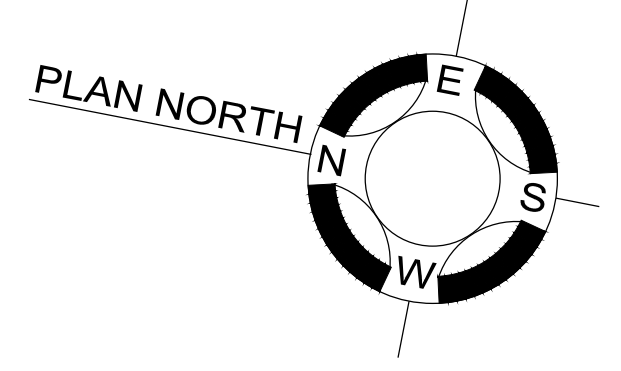

**1** **THIRD FLOOR POWER & DATA PLAN**  
 SCALE: 1/8" = 1'-0"

**BID DOCUMENTS  
 NOT FOR CONSTRUCTION**