

DRAWING STATUS

- OFFICE REVIEW
- CLIENT REVIEW
- PERMIT REVIEW
- BID SET
- CONTRACT DRAWING
- CONSTRUCTION

No drawing shall be recognized as a construction document unless it bears a blue inked registration seal.

SHEET TITLE
 THIRD FLOOR REFLECTED CEILING PLAN

JOB NO. 201512

DRAWN BY EBJ CHECKED BY TRN

SCALE AS NOTED


ORIGINAL DATE 12-29-2016

REVISION DATE

SHEET

A403

1201512-1200CONGRESSCONDOCS ARCH101FLRPLAN.SVG

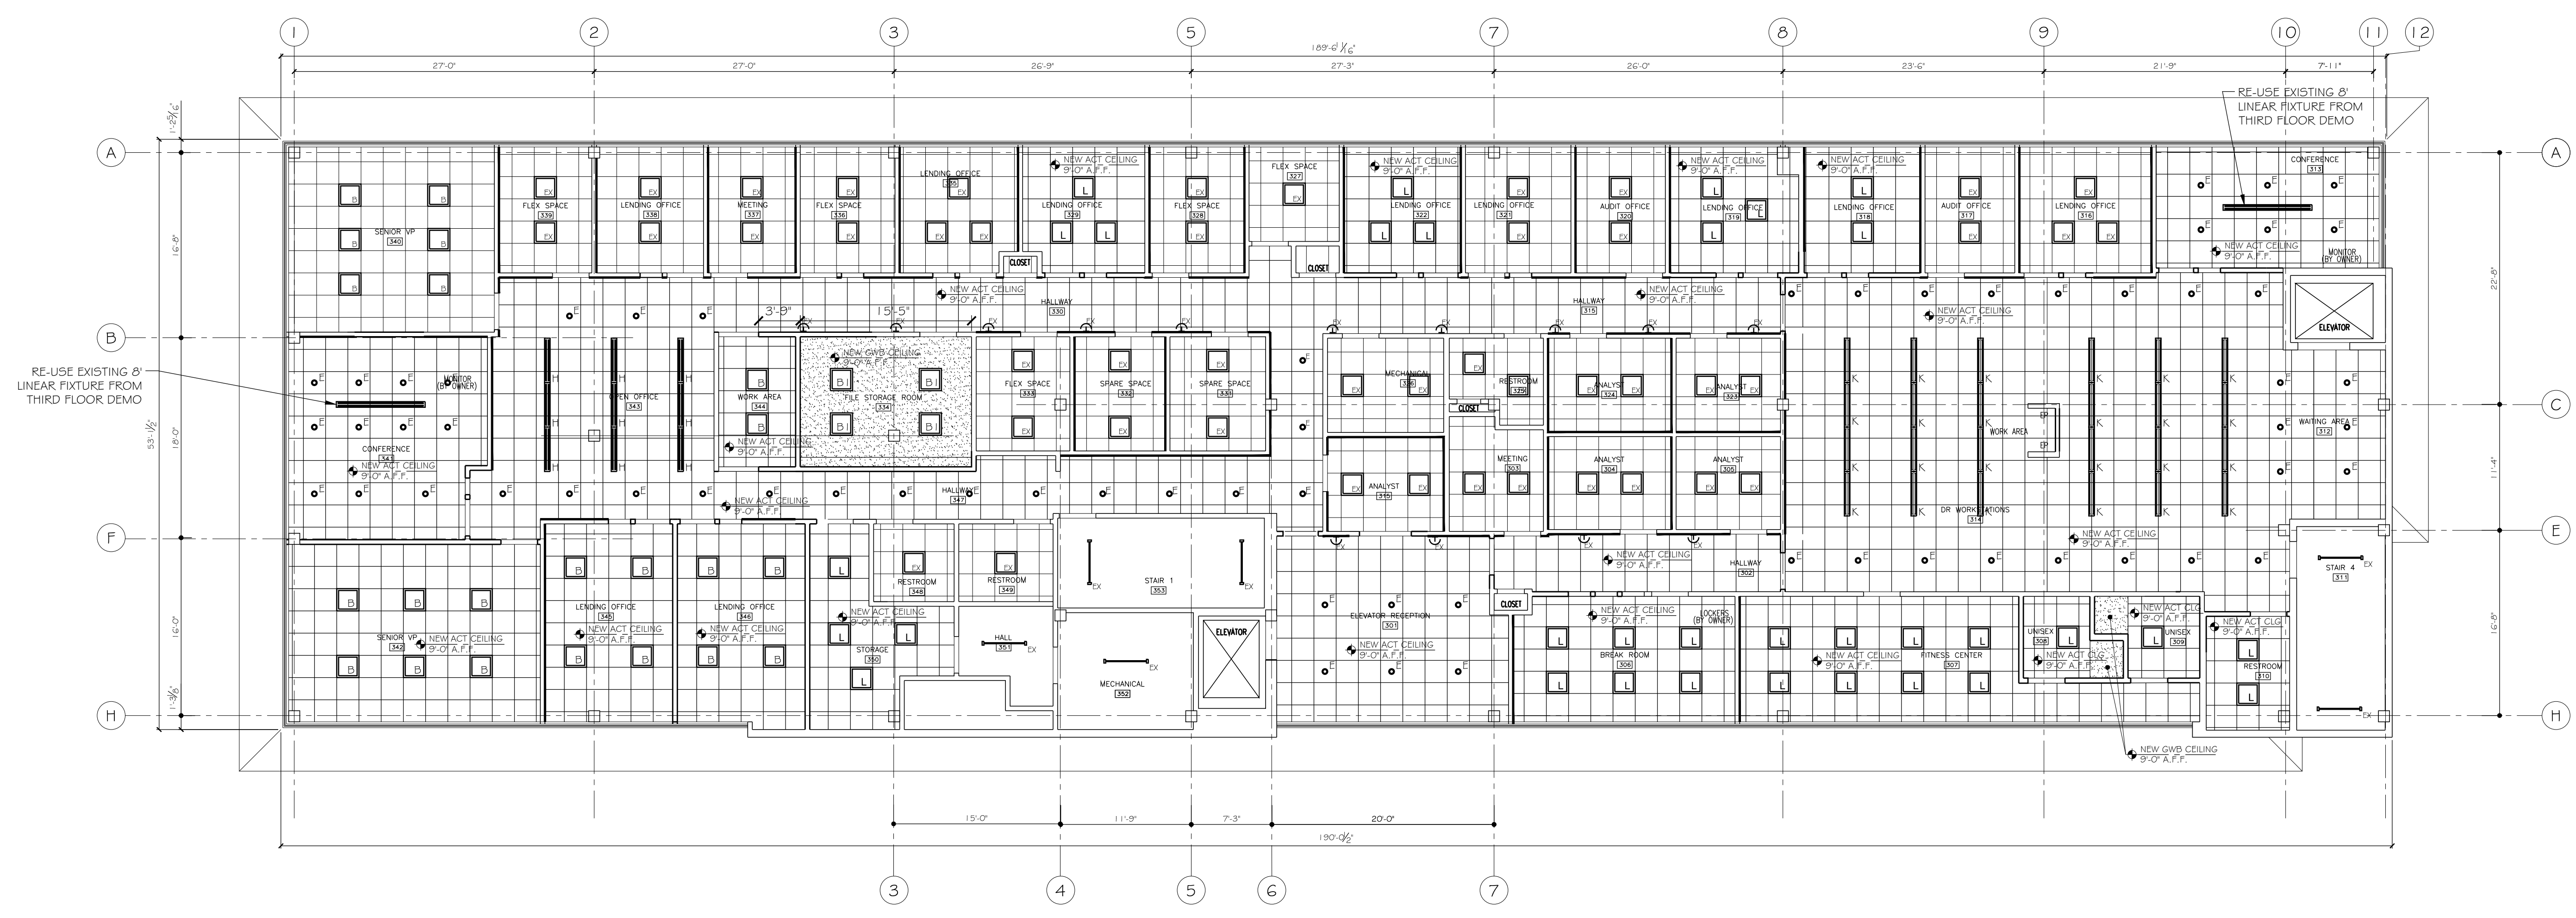

LIGHTING SCHEDULE	
	LIGHTING FIXTURE TYPE A = 2' x 4' RECESSED LED SPEC: LITHONIA LIGHTING #2VTL4-40L-ADP-EZ1-LP835 2
	LIGHTING FIXTURE TYPE AI = 2' x 4' SURFACE-MOUNTED LED SPEC: LITHONIA LIGHTING #2VTL4-40L-ADP-EZ1-LP835-DGA24FSV1 2
	LIGHTING FIXTURE TYPE B = 2' x 2' RECESSED LED SPEC: LITHONIA LIGHTING #2VTL2-33L-ADP-EZ1-LP835 2
	LIGHTING FIXTURE TYPE BI = 2' x 2' RECESSED LED SPEC: LITHONIA LIGHTING #2VTL2-33L-ADP-EZ1-LP835-DGA24FSV1 2
	LIGHTING FIXTURE TYPE C = INTERIOR WALL-MOUNTED LED SCENCE SPEC: NOT USED 2
	LIGHTING FIXTURE TYPE D = INTERIOR WALL-MOUNTED LED SCENCE SPEC: NOT USED 2
	LIGHTING FIXTURE TYPE E = 4' RECESSED INTERIOR LED DOWNLIGHT SPEC: ATLANTIC LIGHTING #LED4-DLM20-35K-U-LDE-4LED10-WH 2
	LIGHTING FIXTURE TYPE F = 4' RECESSED ADJUSTABLE LED DOWNLIGHT SPEC: ATLANTIC #LED4ADJ-VR20-35K-1-2WR4UDJ-WH 2
	LIGHTING FIXTURE TYPE G = 48' INTERIOR STRIP LIGHT SPEC: LUMAX #JCM114-801PC-10-SW
	LIGHTING FIXTURE TYPE H = 48' INTERIOR UP/DOWN LINEAR LIGHT SPEC: LUMENVERX #SMIPCL-FMO-LED-80-750-500-35-4-URV-Q-1-53WAC36-W 2
	LIGHTING FIXTURE TYPE J = RE-USE EXISTING INTERIOR WALL-MOUNTED SCENCE SPEC: EXISTING FIXTURES RETAINED FROM SECOND FLOOR
	LIGHTING FIXTURE TYPE K = RE-USE EXISTING 48' UP/DOWN LINEAR LIGHT SPEC: EXISTING FIXTURES RETAINED FROM THIRD FLOOR
	LIGHTING FIXTURE TYPE L = RE-USE EXISTING 2' x 2' RECESSED FIXTURES SPEC: EXISTING FIXTURES RETAINED FROM THE SECOND & THIRD FLOORS

1 THIRD FLOOR REFLECTED CEILING PLAN
 SCALE: 1/8" = 1'-0"