


Proposed Renovation of:
NORWAY SAVINGS BANK
 1200 Congress Avenue
 Portland, Maine

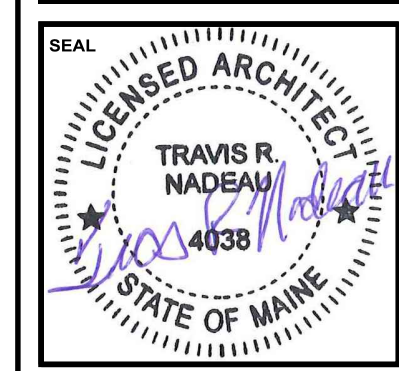

<input type="checkbox"/>	OFFICE REVIEW
<input type="checkbox"/>	CLIENT REVIEW
<input type="checkbox"/>	PERMIT REVIEW
<input type="checkbox"/>	BID SET
<input type="checkbox"/>	CONTRACT DRAWING
<input checked="" type="checkbox"/>	CONSTRUCTION

No drawing shall be recognized as a construction document unless it bears a blue inked registration seal.

SHEET TITLE
**THIRD FLOOR
 POWER & DATA
 PLAN**

JOB NO.
201512

DRAWN BY
EBJ

CHECKED BY
TRN

SCALE
AS NOTED


ORIGINAL DATE
12-29-2016

REVISION DATE

SHEET

E103

INSB-1200 CONGRESS CONDOCS
 ARCH PLANS 103-FLOOR PLANS.DWG

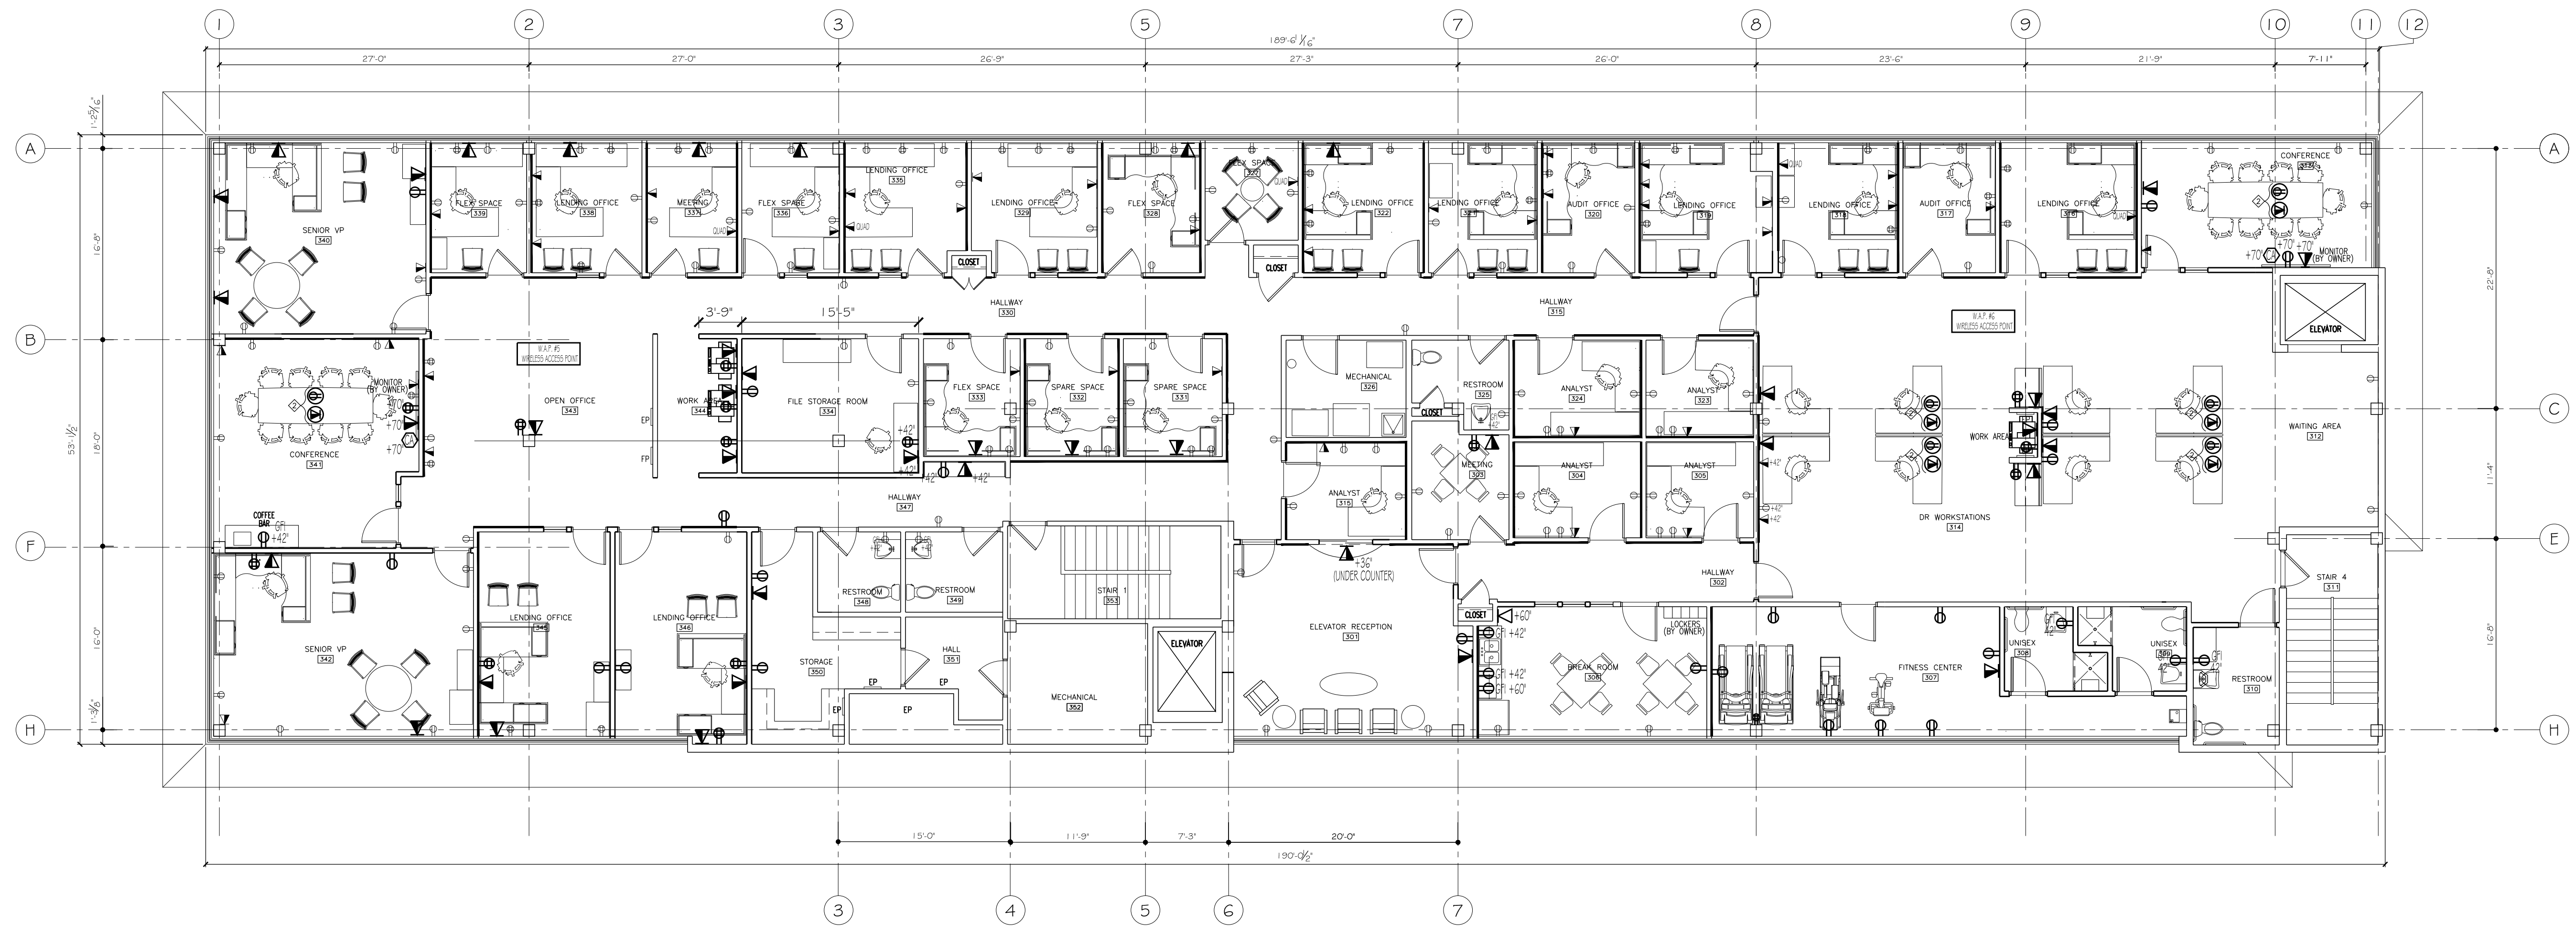


GENERAL DATA NOTE:

- ALL EXISTING DATA LOCATIONS TO REMAIN SHALL RECEIVE NEW IN-WALL DUPLEX JACK (WHITE COVER)

KEYED POWER/DATA NOTES:

- ◇ COORDINATE LOCATION OF FLOOR OUTLETS/DATA WITH ARCHITECT
- ◇ COORDINATE LOCATION OF IN-CABINET/FLOOR OUTLETS/DATA WITH ARCHITECT
- ◇ RELOCATED EXISTING OUTLET/DATA RECEPTACLE
- ◇ 1" CONDUIT TO DATA ROOM

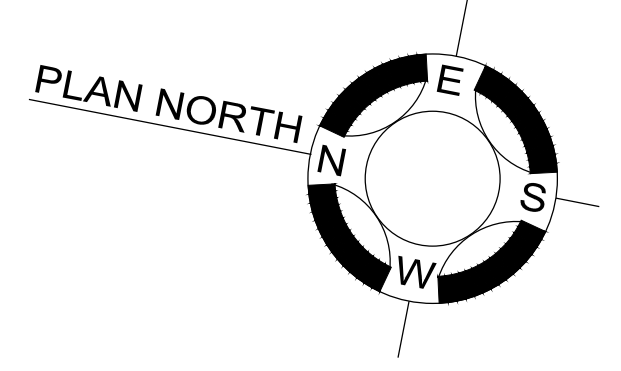

1 **THIRD FLOOR POWER & DATA PLAN**
 SCALE: 1/8" = 1'-0"