

FIRST FLOOR LIGHTING LEGEND						
SYMBOL	LABEL	DESCRIPTION	MANUFACTURER	CATALOG NUMBER	LAMPS	NOTES
	A	2' X 2' LED	COOPER LIGHTING-METALUX	22EN-LD1-34-UNV-L835-CD1-U	3500K LEDS	
	B	2' X 4' LED	COOPER LIGHTING-METALUX	24EN-LD1-45-UNV-L835-CD1-U	3500K LEDS	
	B-1	2' X 4' LED	COOPER LIGHTING-METALUX	24EN-LD1-54-UNV-L835-CD1-U	3500K LEDS	
	E	2' X 4' EXISTING				REPLACE BULBS WITH NEW 3500K FLUORESCENT

- NOTES:**
- 7 EXISTING HVAC UNITS
 - VERIFY LOCATIONS IN FIELD
 - MECHANICAL CONTRACTOR TO BE RESPONSIBLE TO INSPECT SYSTEM AND UPDATE TO NEW LAYOUT.
 - ADD DIFFUSERS AND RETURNS AS NECESSARY FOR NEW LAYOUT
 - ADDITIONAL EXHAUSTS TO BE ADDED TO BATHROOMS SPLIT INTO TWO
 - SMOKE DAMPERS TO BE INSTALLED IN DUCTWORK RUNNING BETWEEN SUITE 2A & SUITE 2B


- SPRINKLER HEADS ARE CONCEALED.
- ADD AND ADJUST SPRINKLER LAYOUT TO NEW FLOOR PLAN LAYOUTS WITH HEADS TO MATCH EXISTING

EXISTING HVAC LAYOUT SHOWN IN GREY


EXISTING DIFFUSER

EXISTING RETURN


2 1st FLOOR REFLECTED CEILING PLAN
SCALE: 1/8" = 1'-0"

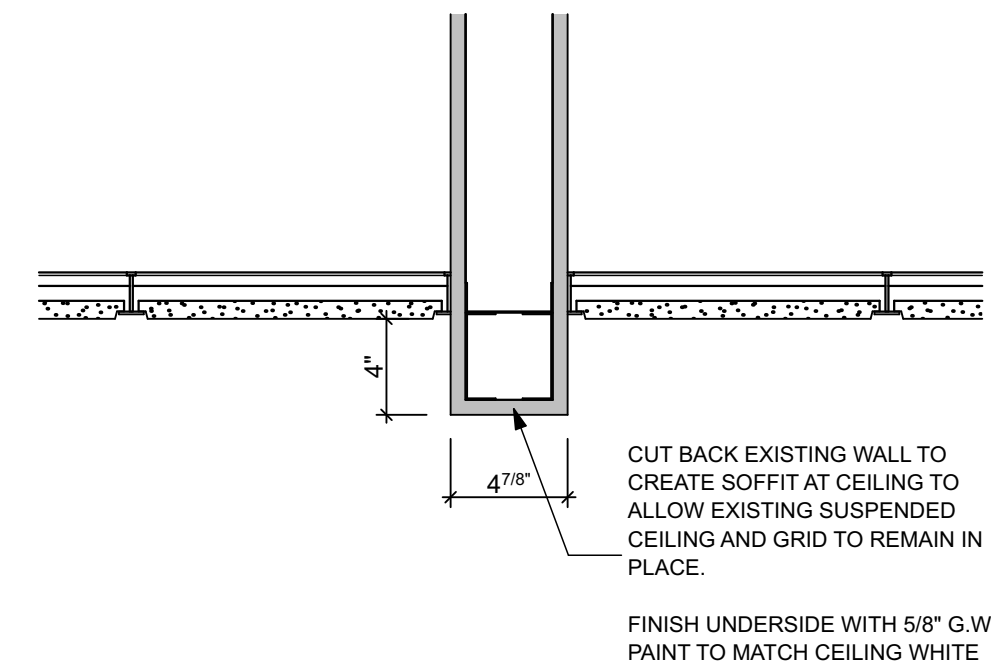


3 SOFFIT DETAIL WHERE WALL IS REMOVED
SCALE: 1 1/2" = 1'-0"

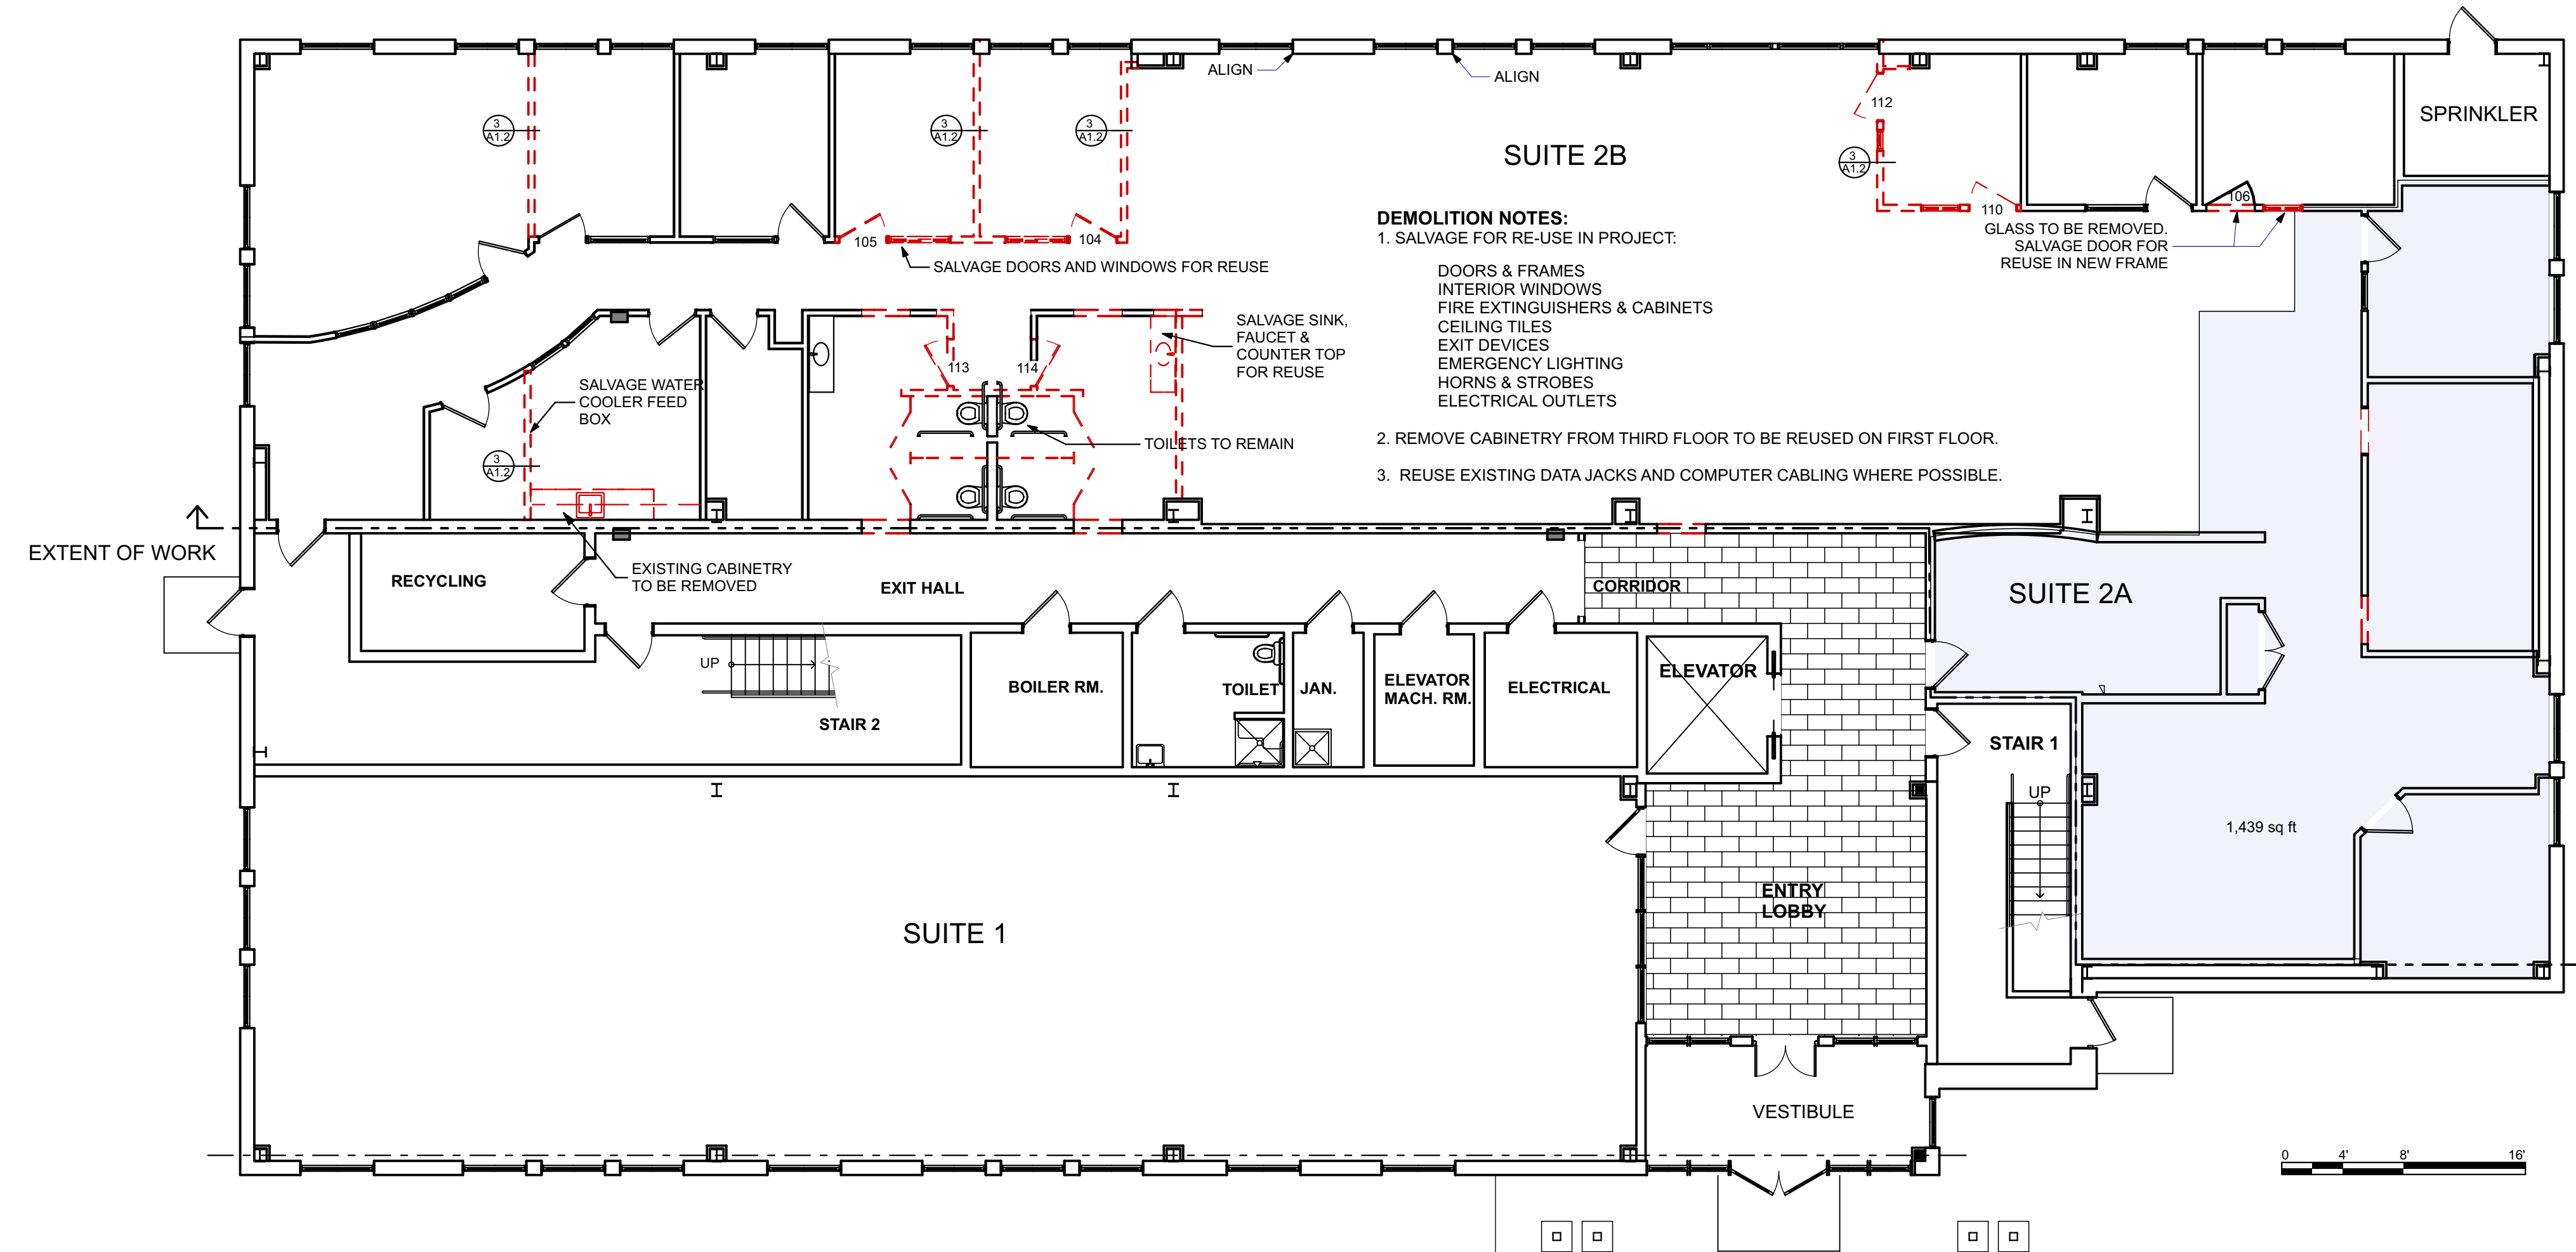

1 1st FLOOR DEMO PLAN
SCALE: 1/8" = 1'-0"

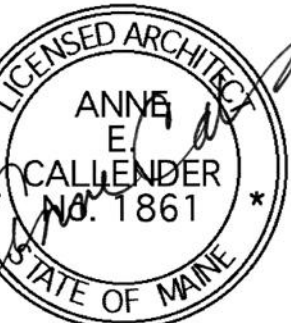

WHIPPLE
CALLENDER
ARCHITECTS

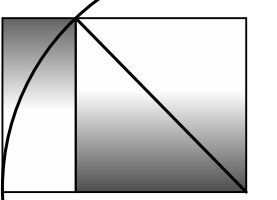

136 PLEASANT AVE.
PORTLAND, ME 04103
P 207.775.2696
F 207.775.3631
www.whipplecallender.com

DATE	DESCRIPTION
10/5/2016	ISSUED FOR PRICING
10/21/2016	ELECT/DATA UPDATES TO PRICING SET
12/20/2016	UPDATES + PERMITTING

DATE: 12/20/16
CHECKED BY: AEC
DRAWN BY: CCL / NPC
JOB: 16-DAP

SHEET TITLE:
FIRST FLOOR
DEMO AND
REFLECTED
CEILING PLANS

A1.2

ISSUED FOR PERMITTING DECEMBER 20, 2016
ISSUED FOR PRICING OCTOBER 5, 2016

THIS DRAWING IS AN INSTRUMENT OF SERVICE AND SHALL REMAIN THE PROPERTY OF WHIPPLE CALLENDER ARCHITECTS. IT SHALL NOT BE USED FOR ANY OTHER PURPOSE THAT FOR WHICH IT IS SPECIFICALLY FURNISHED.