


NOTES:  
 1. CHECK ON WAIT 454 FIXTURE

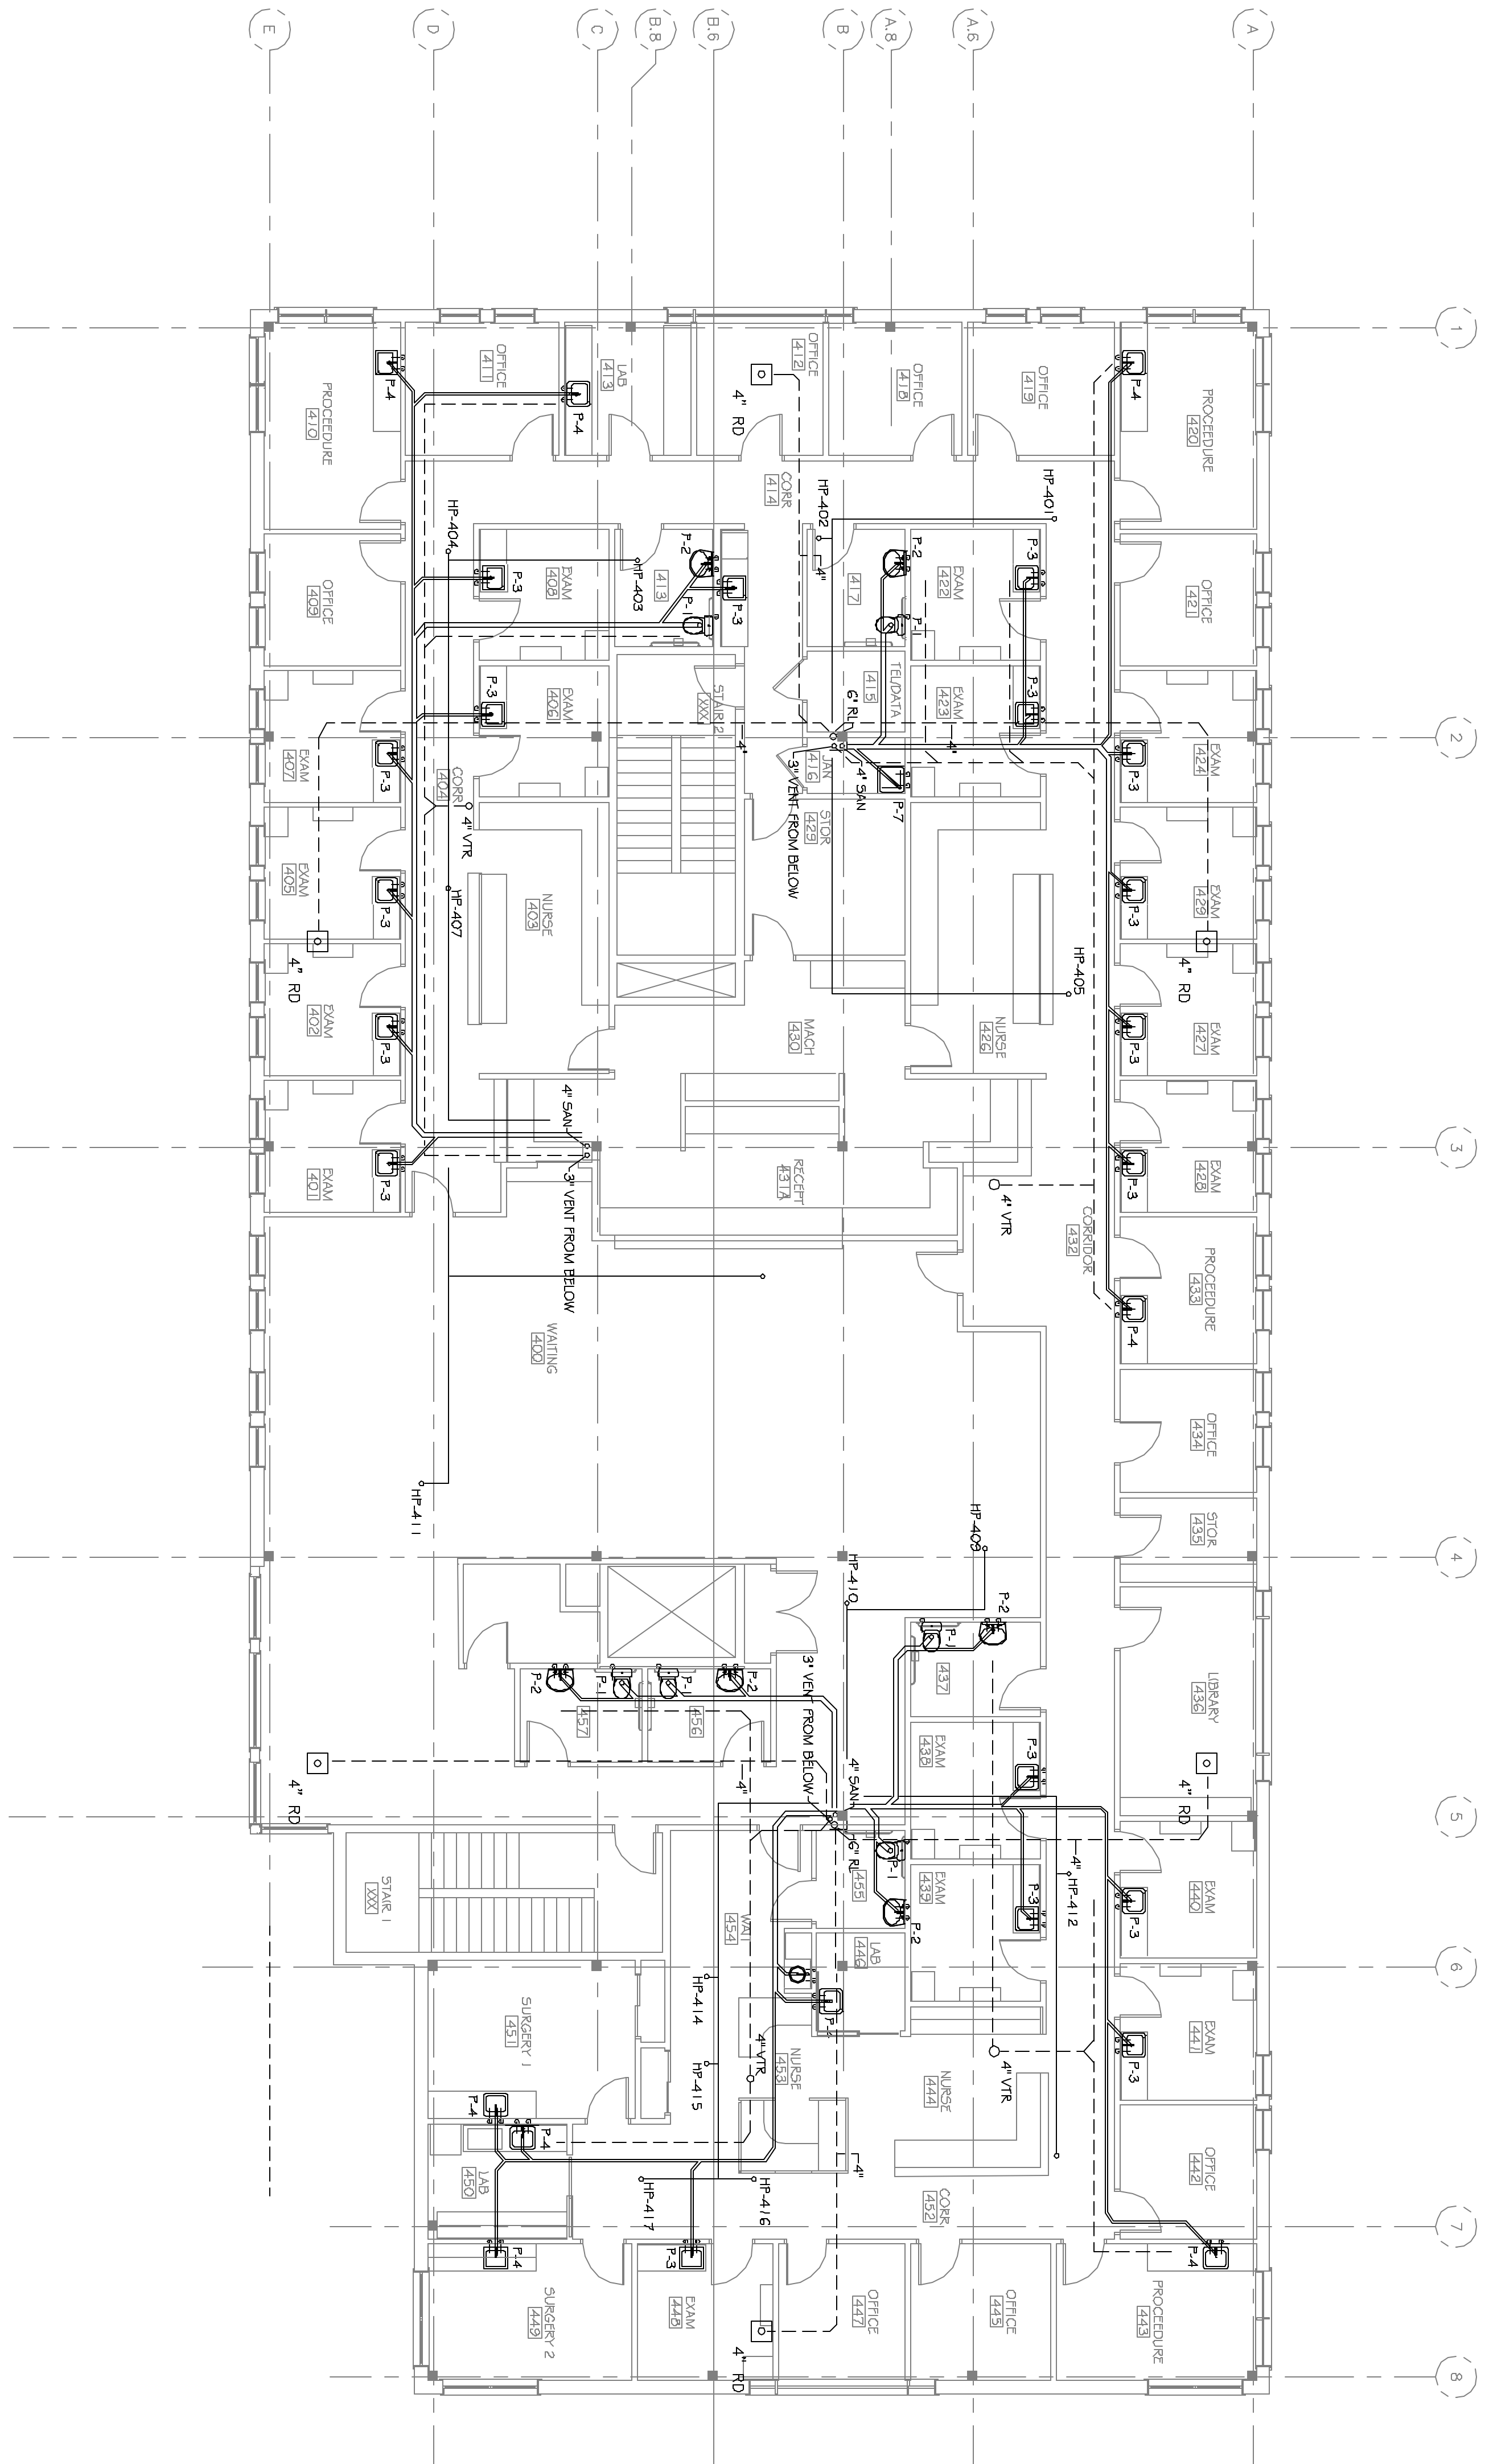

FOURTH FLOOR PLAN

SCALE 1/8"=1'-0"

SHEET #  
**M-10**  
 OF 10

PROJECT:  
**50 SEWALL STREET**  
 PORTLAND, MAINE

DRAWN: TLP	CHECKED: MPJ
SCALE: 1/8"=1'-0"	
DATE: 05-19-05	
PROJECT #: 05001	

DRAWINGS THIS SHEET:  
 MECHANICAL PLANS &  
 DETAILS

ISSUE:  
 PERMIT SET  
 05-19-05

**JOHNSON & JORDAN**  
 MECHANICAL CONTRACTORS  
 18 MUSSEY ROAD  
 SCARBOROUGH, MAINE 04074  
 TEL (207) 883-8345 • FAX (207) 883-8619

