

**JOHNSON & JORDAN**  
 MECHANICAL CONTRACTORS  
 18 MUSSEY ROAD  
 SCARBOROUGH, MAINE 04074  
 TEL. (207) 883-8345 \* FAX (207) 883-8619



ISSUE:  
**PERMIT SET**  
**5-19-05**

DRAWINGS THIS SHEET:  
**MECHANICAL PLANS & DETAILS**

DRAWN: MPJ  
 CHECKED: MPJ  
 SCALE: 1/8"=1'-0"  
 DATE: XX-XX-05  
 PROJECT #: 05001

PROJECT:  
**50 SEWALL STREET**  
 PORTLAND, MAINE

SHEET #  
**M-3**  
 OF 10

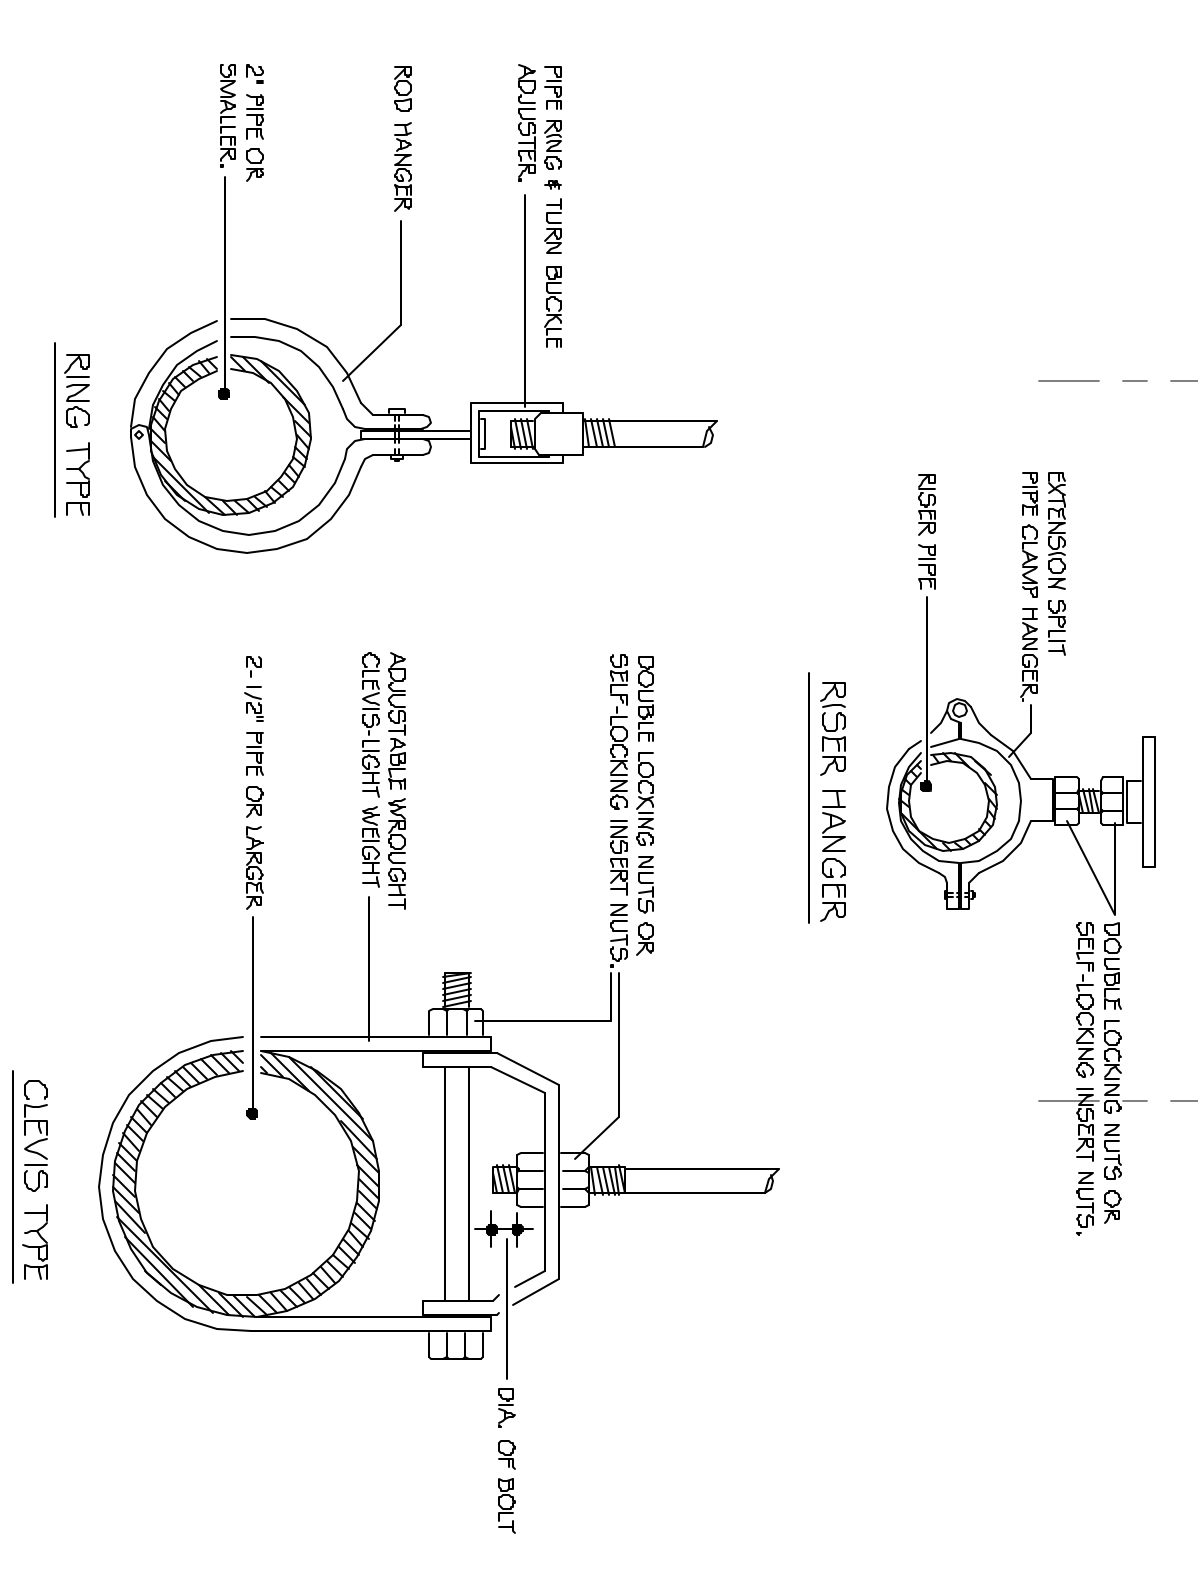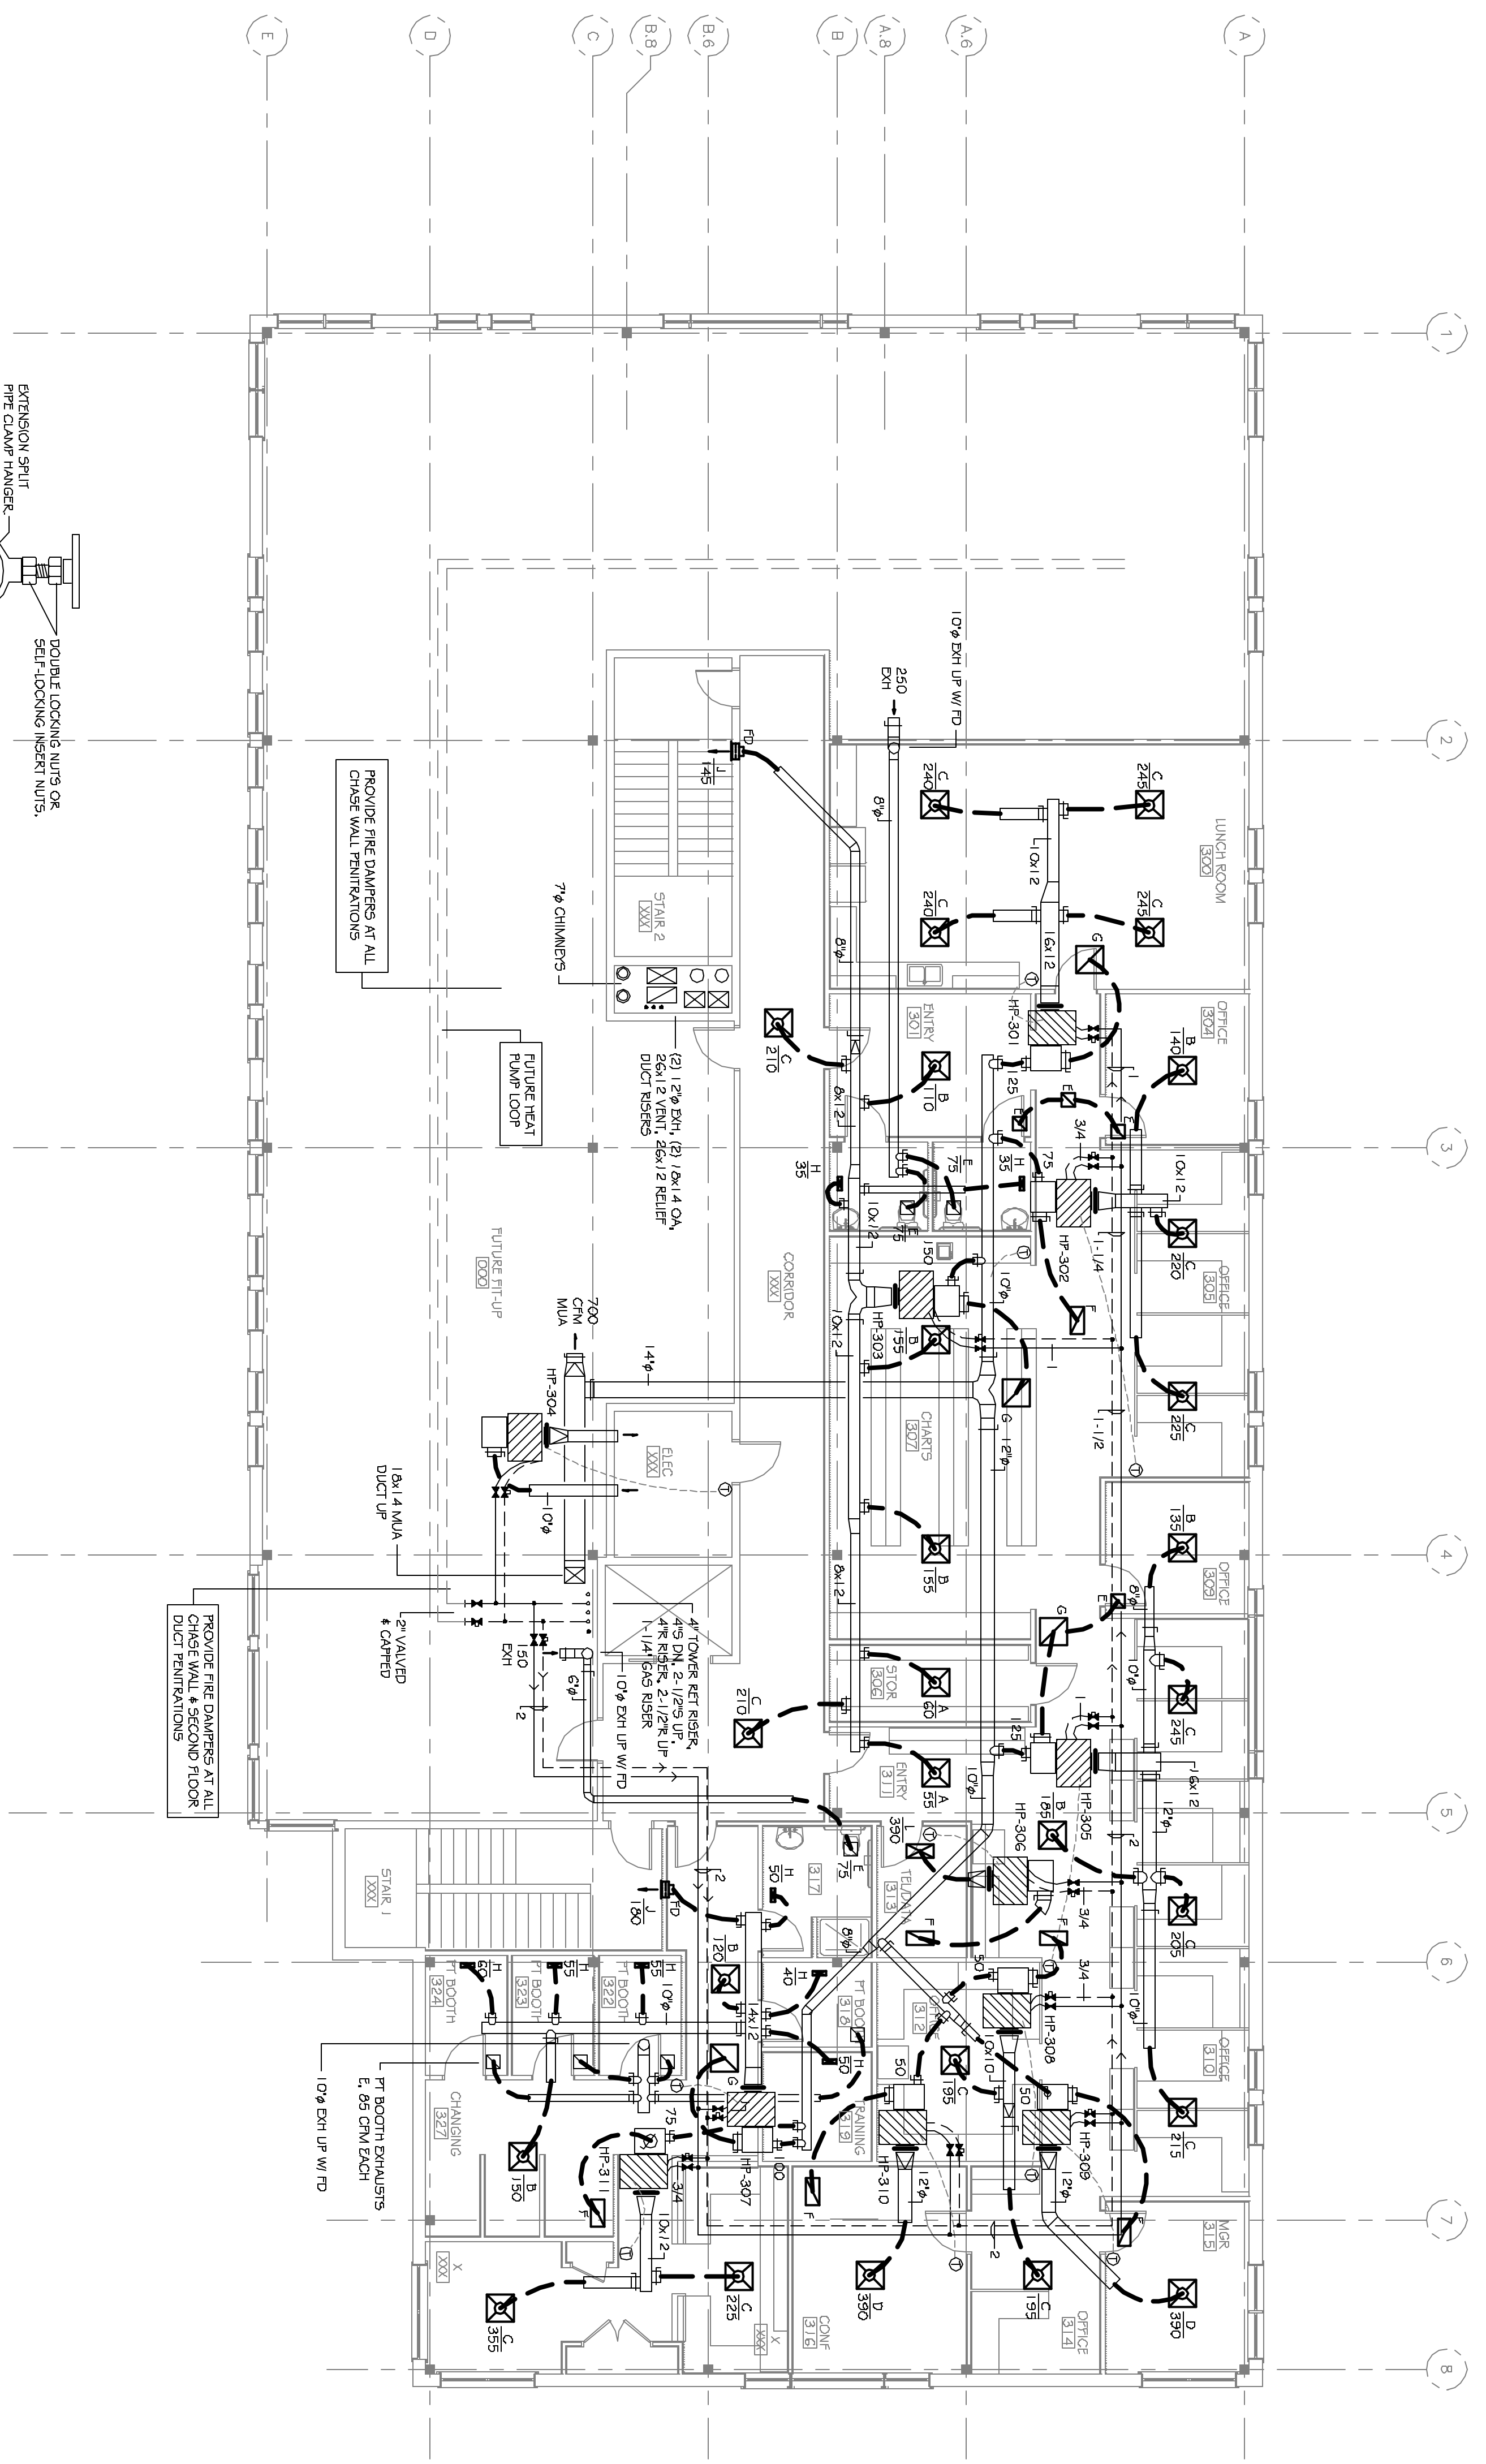

**HANGERS & SUPPORTS**