


FOURTH FLOOR PLAN

SCALE 1/8"=1'-0"

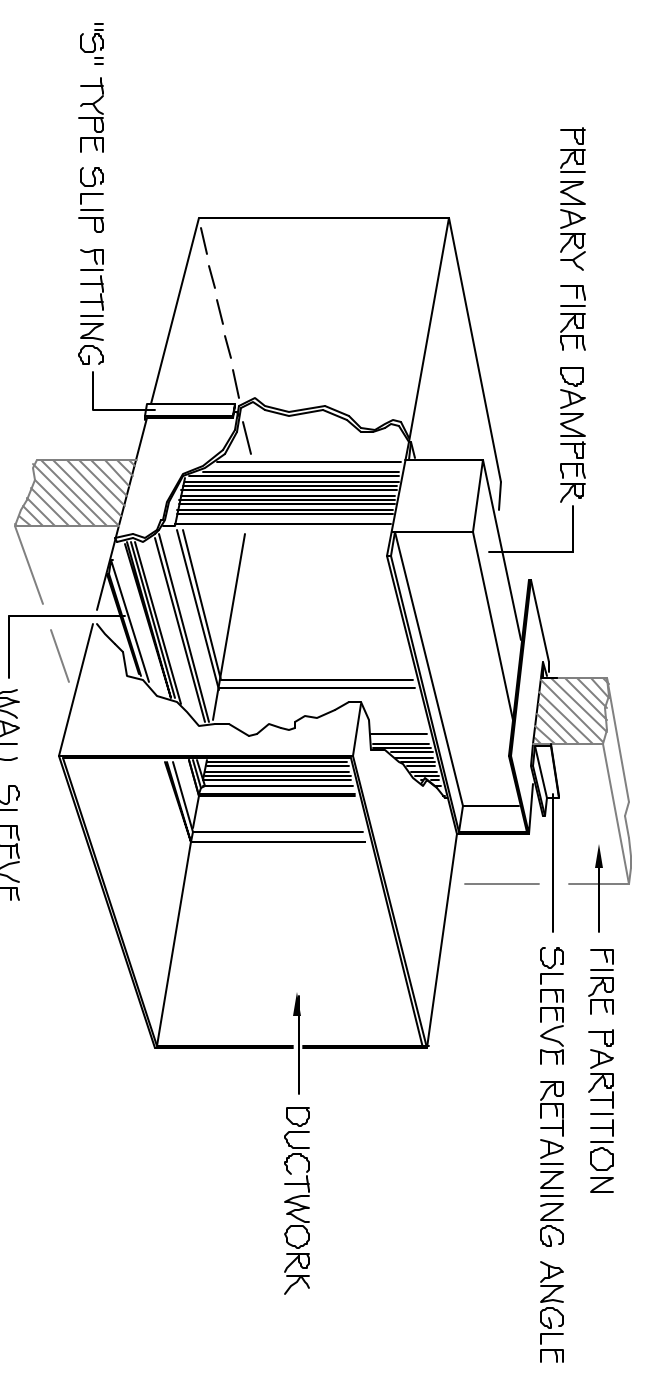

PRIMARY FIRE DAMPER DETAIL
TYPE "B" 100% FREE AREA

SHEET # M-4 OF 10	PROJECT: 50 SEWALL STREET PORTLAND, MAINE	DRAWN: MPJ	CHECKED: MPJ	DRAWINGS THIS SHEET: MECHANICAL PLANS & DETAILS	ISSUE: PERMIT SET 5-19-05		
		SCALE: 1/8"=1'-0"	DATE: XX-XX-05				