




ROOF PLAN
SCALE 1/8"=1'-0"

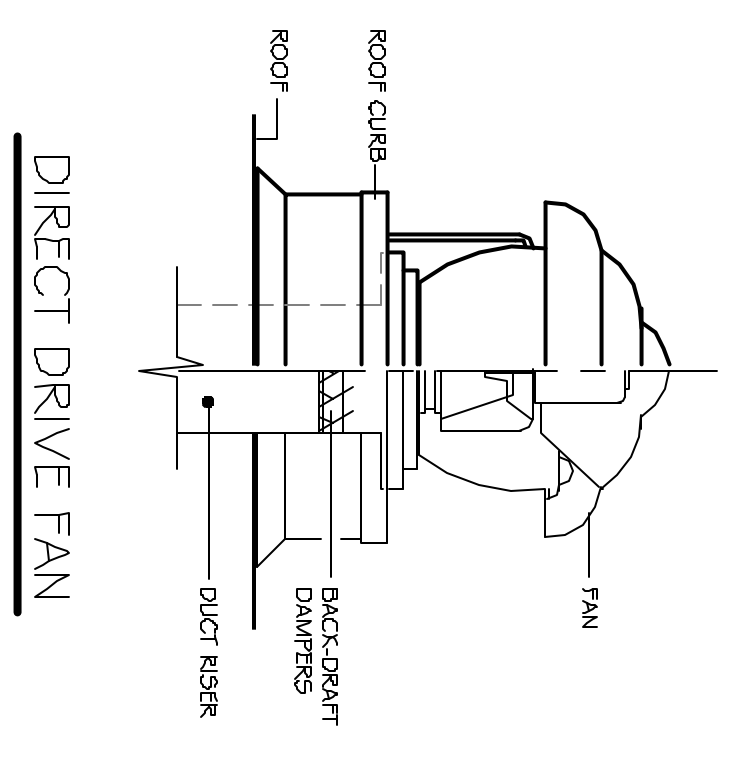

DIRECT DRIVE FAN

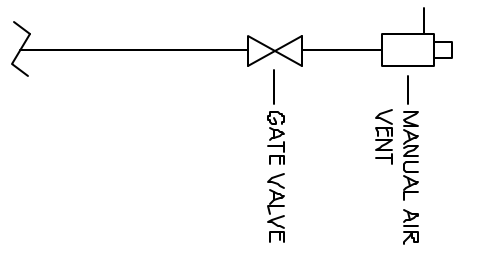

END OF MAIN AIR VENT DETAIL

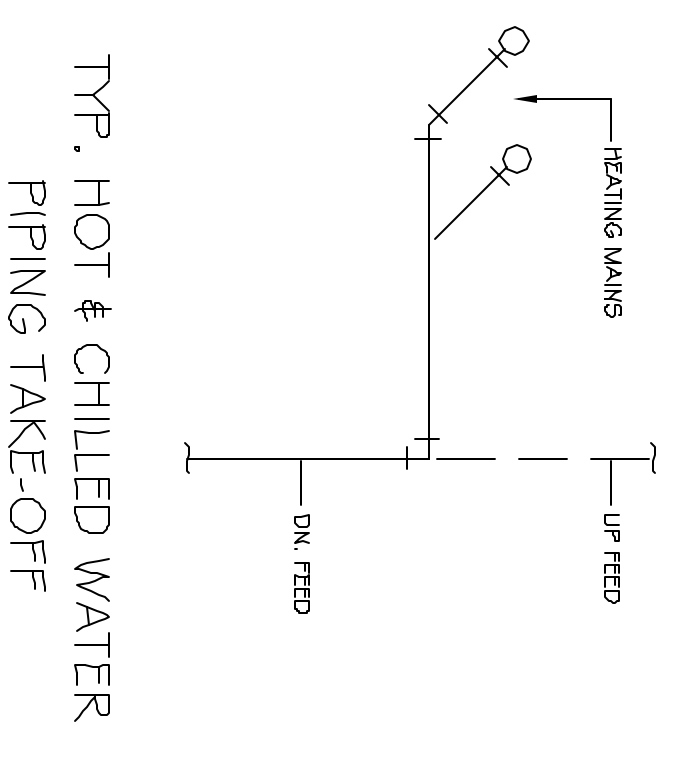

TYP. HOT & CHILLED WATER PIPING TAKE-OFF

SHEET #
M-5
OF 10

PROJECT:
50 SEWALL STREET
PORTLAND, MAINE

DRAWN: MPJ
CHECKED: MPJ
SCALE: 1/8"=1'-0"
DATE: XX-XX-05
PROJECT # 05001

DRAWINGS THIS SHEET:
MECHANICAL PLANS & DETAILS

ISSUE:
PERMIT SET 5-19-05

JOHNSON & JORDAN
MECHANICAL CONTRACTORS
18 MUSSEY ROAD
SCARBOROUGH, MAINE 04074
TEL. (207) 883-8345 * FAX (207) 883-8619

