

JOHNSON & JORDAN
 MECHANICAL CONTRACTORS
 18 MUSSEY ROAD
 SCARBOROUGH, MAINE 04074
 TEL. (207) 883-8345 * FAX (207) 883-8619


ISSUE:
 PERMIT SET
 05-19-05

DRAWINGS THIS SHEET:
 MECHANICAL PLANS &
 DETAILS

DRAWN: TLP
 CHECKED: MPJ
 SCALE: 1/8"=1'-0"
 DATE: 05-19-05
 PROJECT#: 05001

PROJECT:
50 SEWALL STREET
 PORTLAND, MAINE

SHEET #
M-8
 OF 10

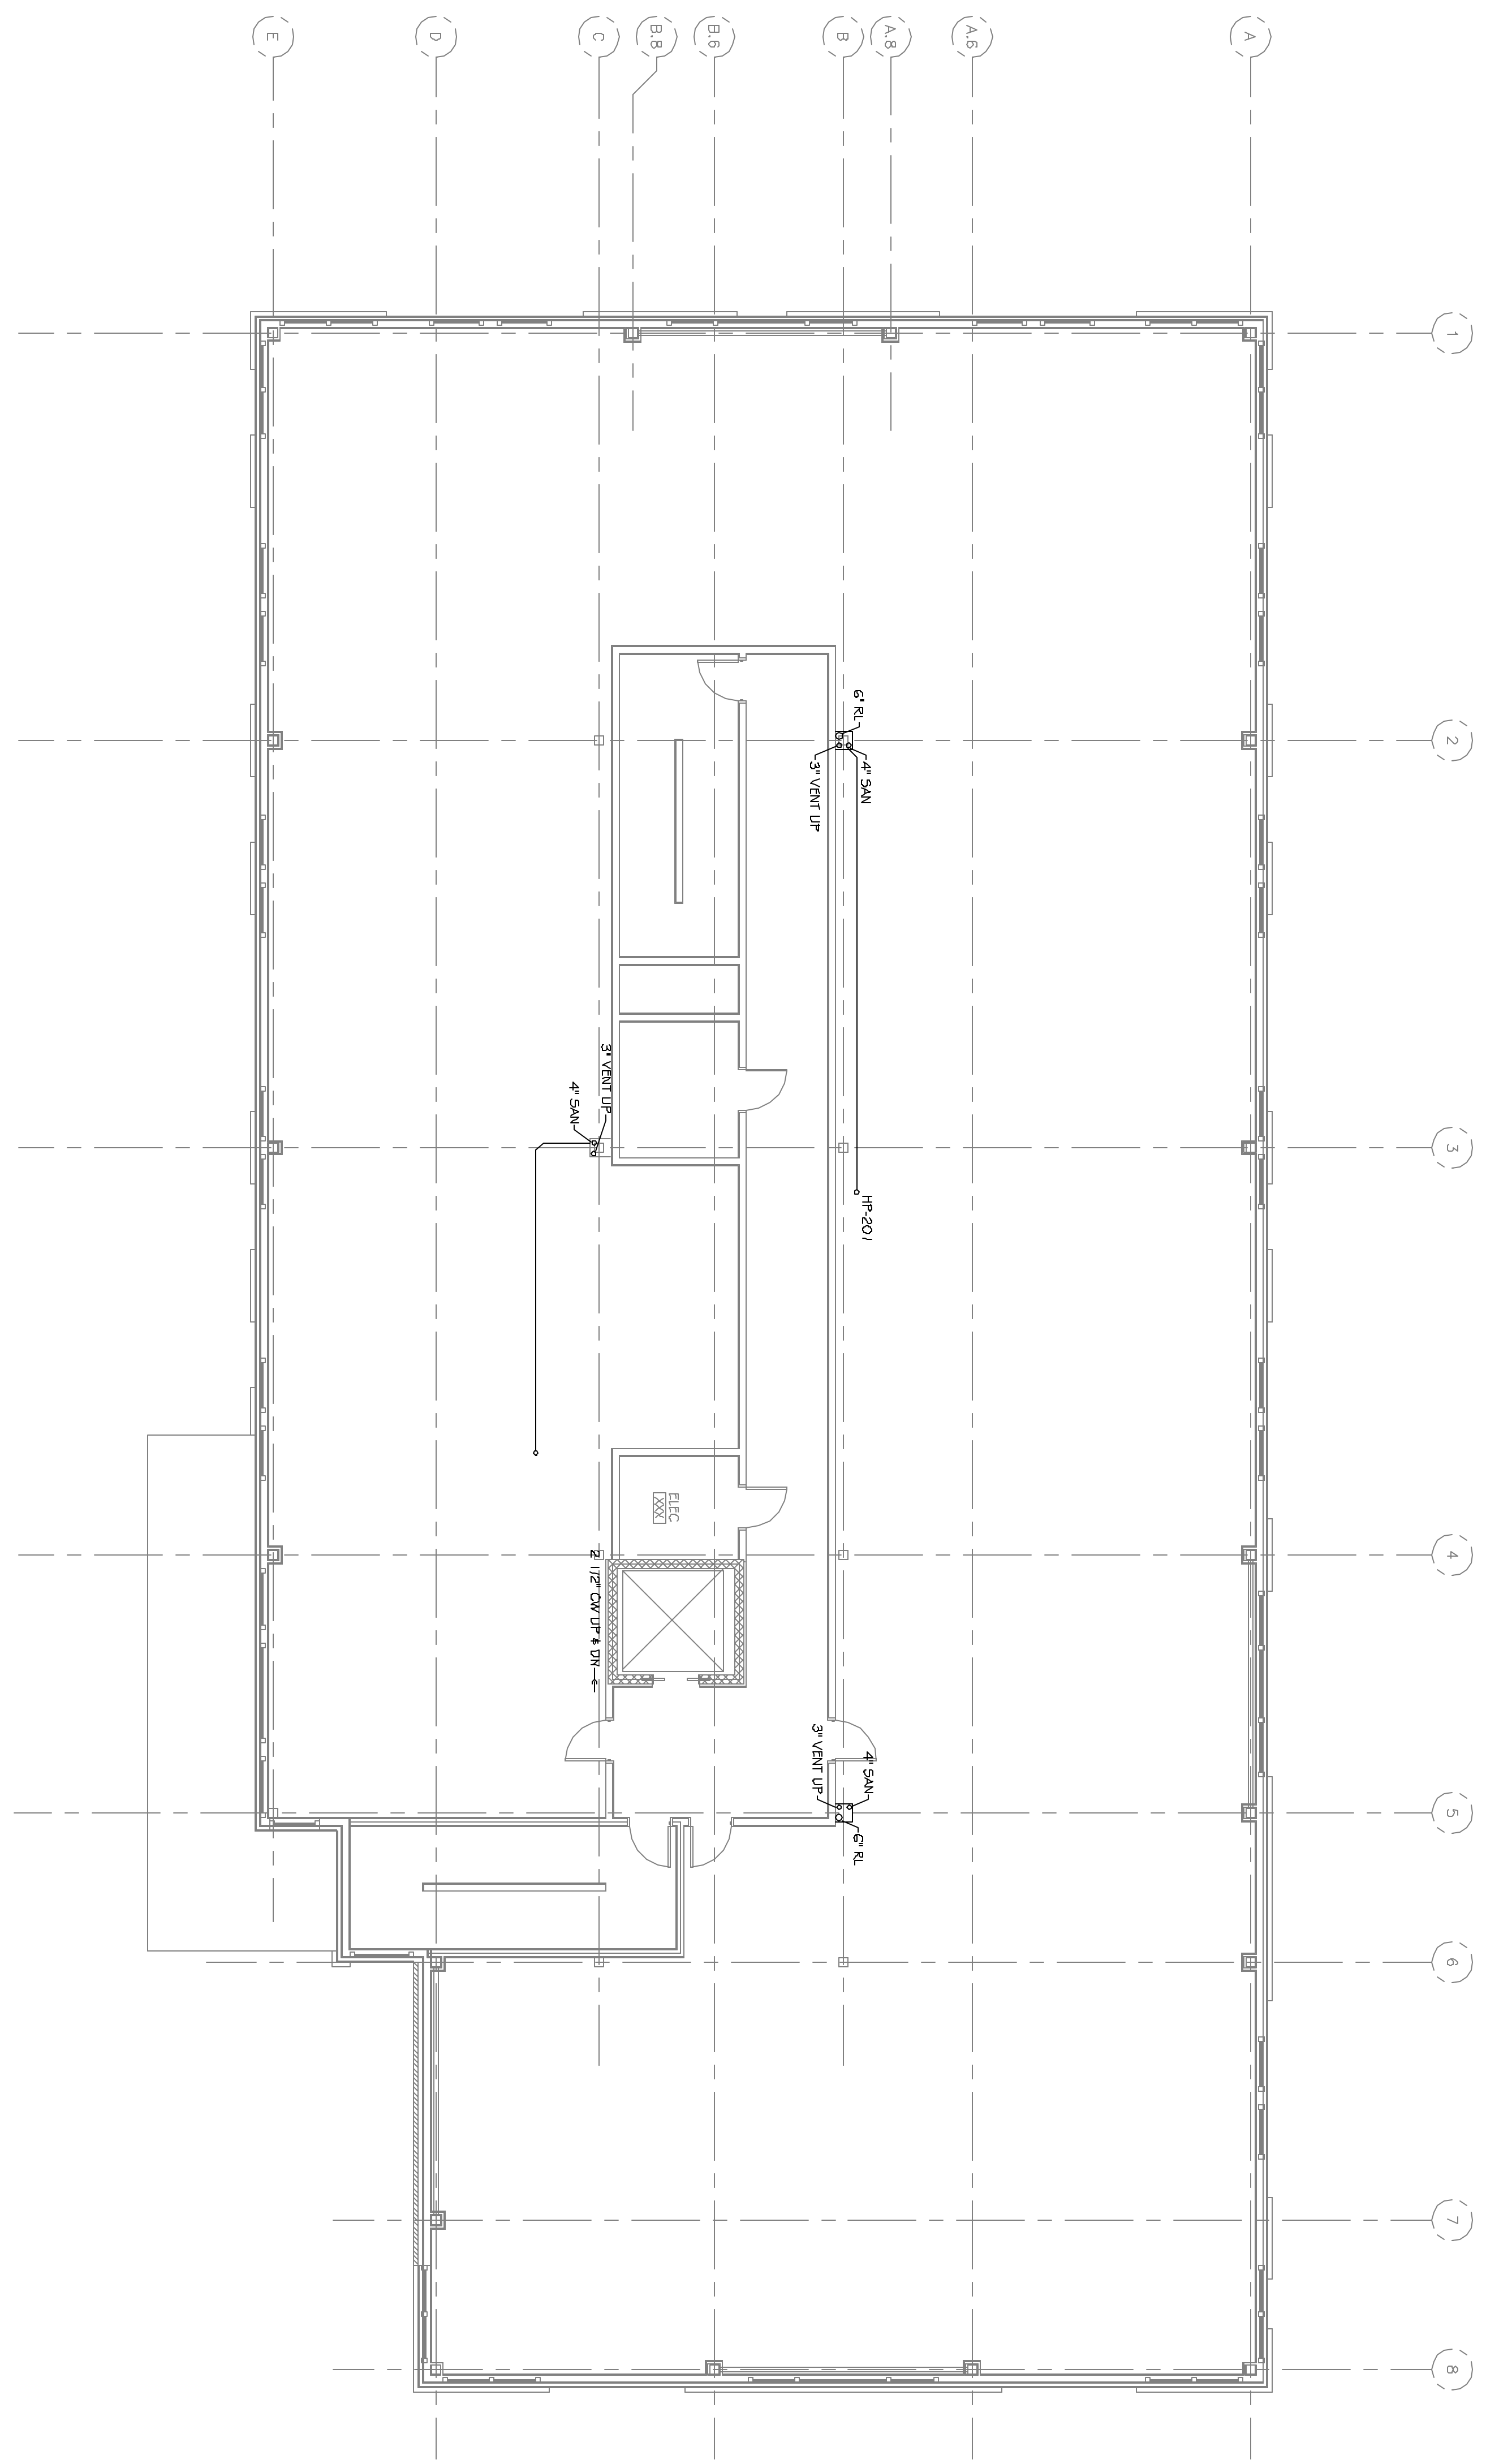

SECOND FLOOR PLAN
 SCALE 1/8"=1'-0"