
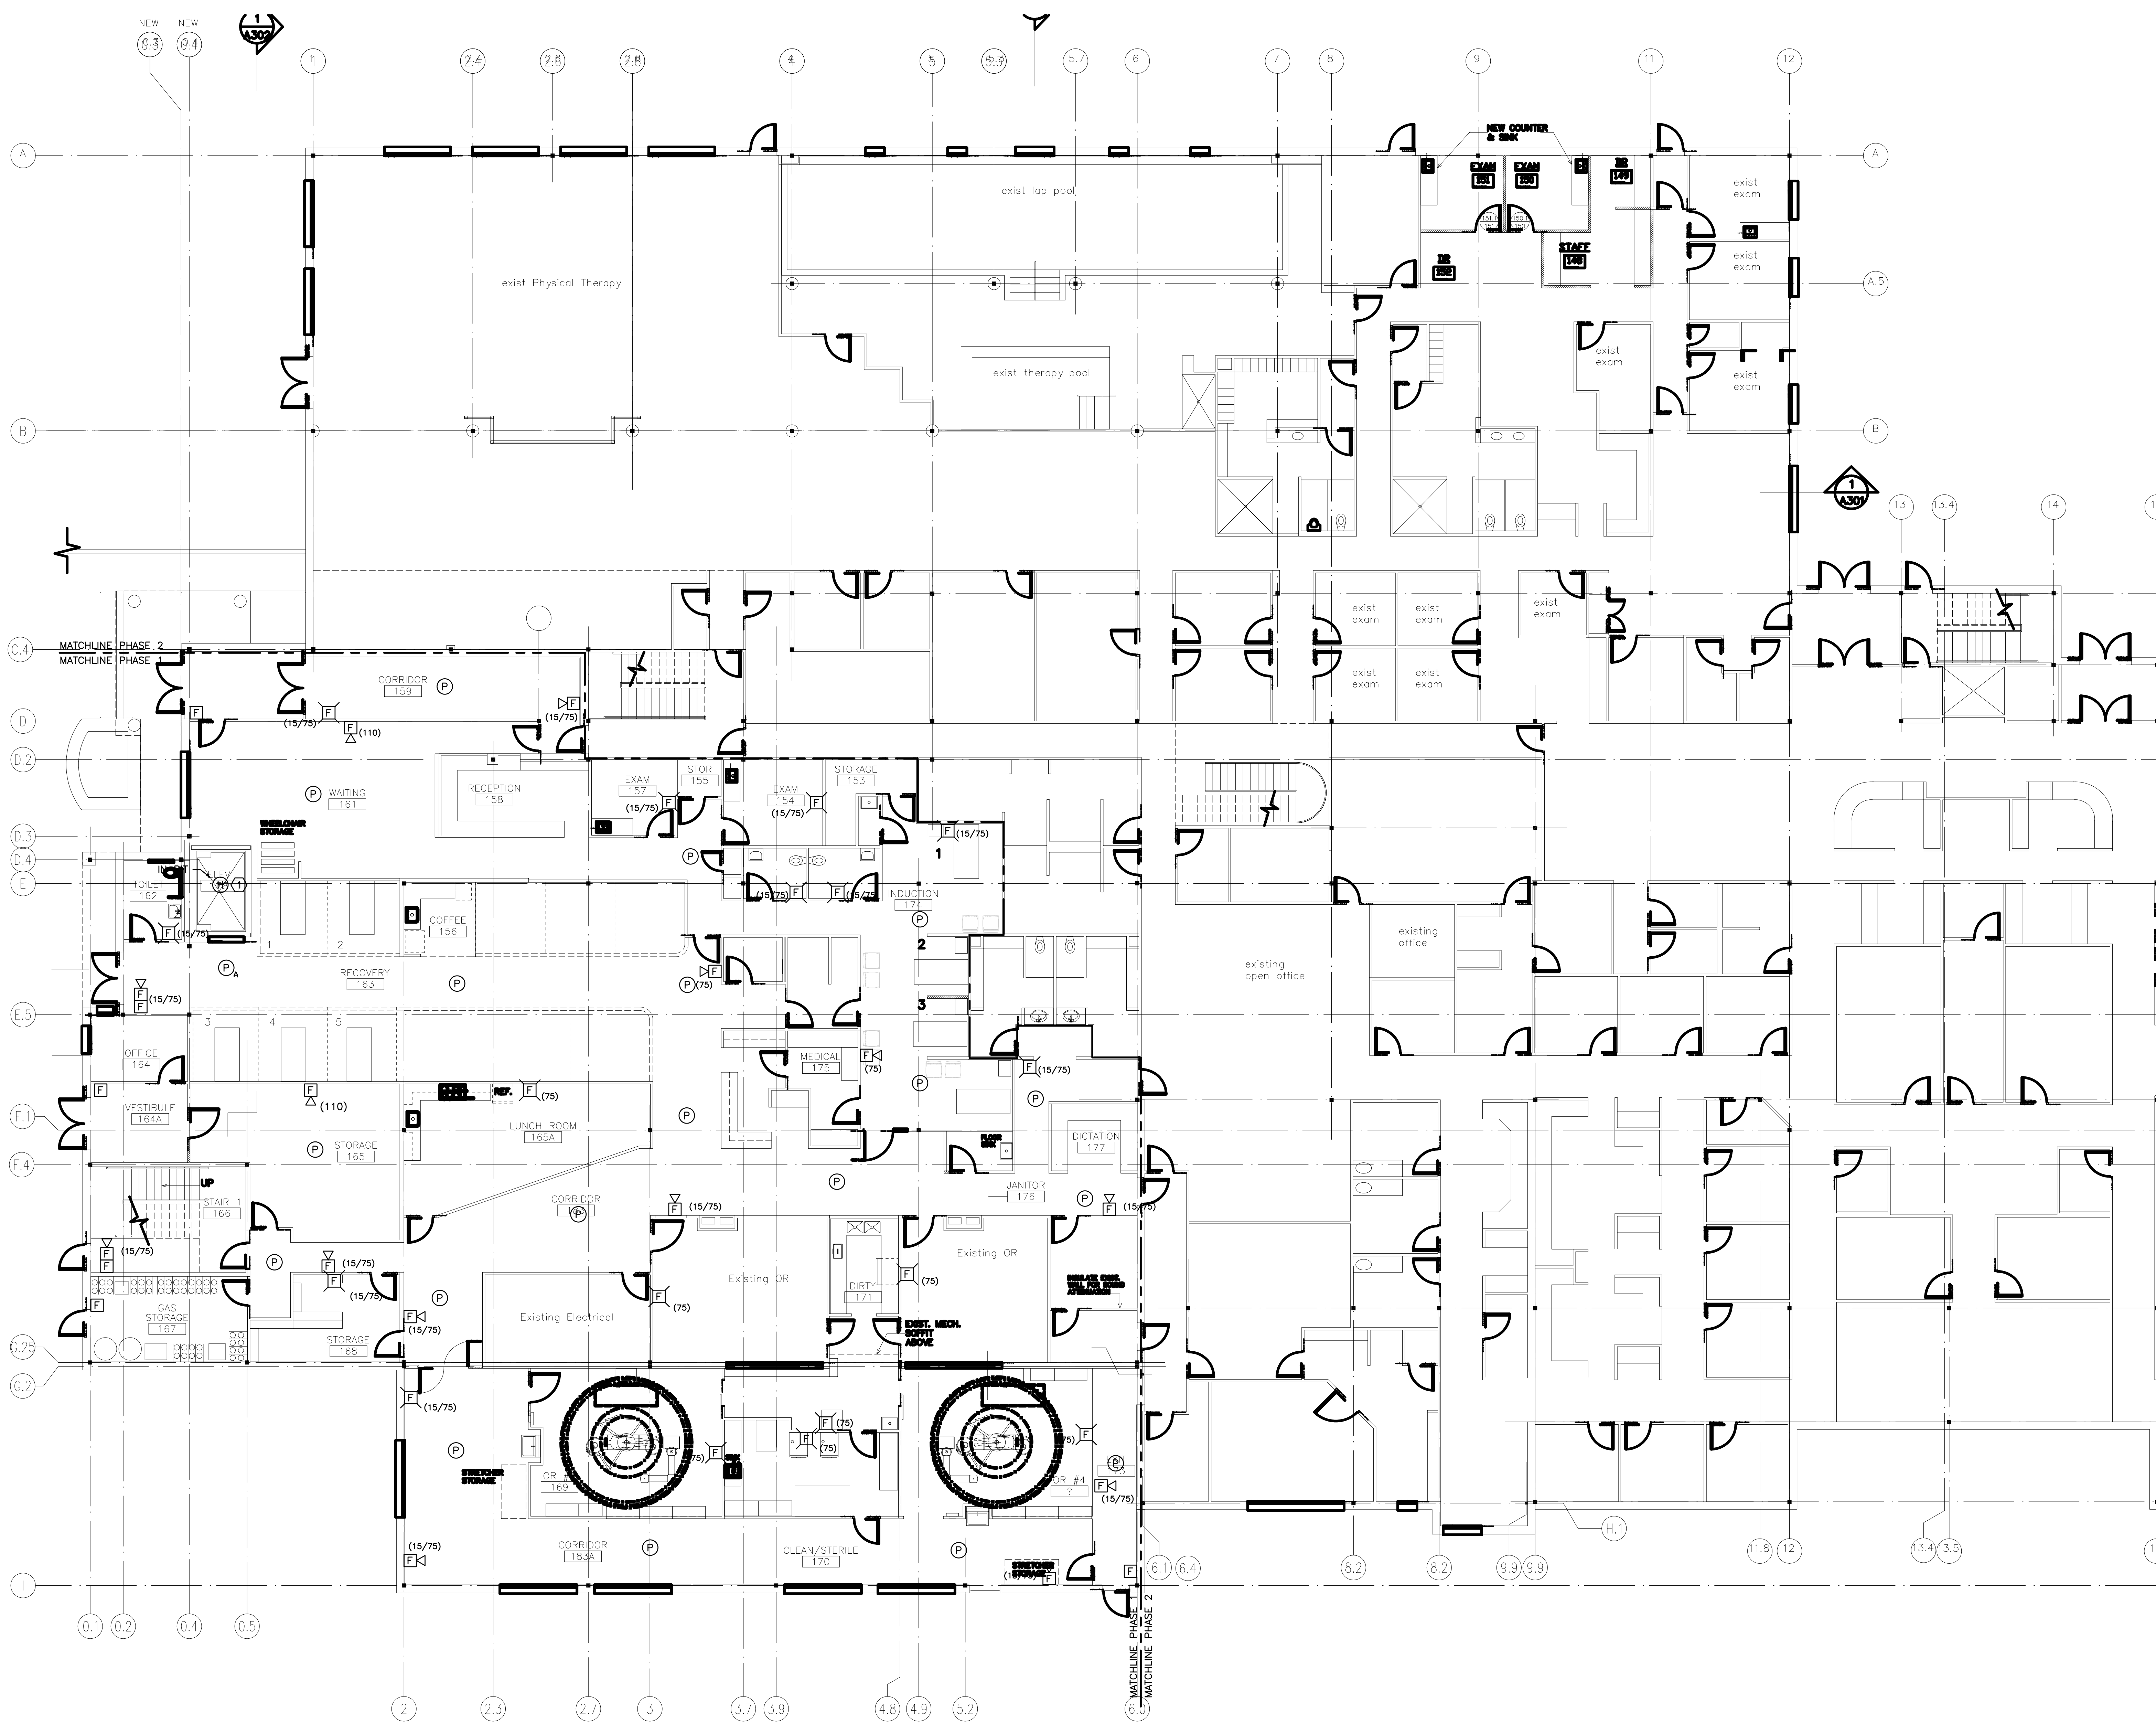


NOTE:
1. SEE SHEET E-001 FOR LEGEND AND GENERAL NOTES.

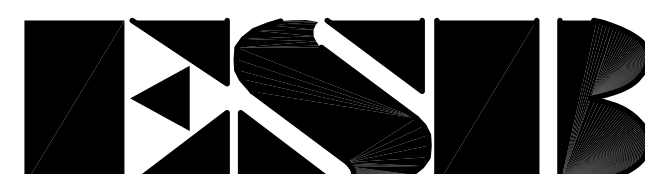

0	ISSUED FOR PERMITTING	5-20-03
REV.	DESCRIPTION	DATE
ISSUED FOR PERMITTING 5-20-03		
CURRENT ISSUE STATUS:		
 ESIB E.S. BOULOS CO ELECTRICAL CONTRACTORS		
ORTHOPAEDIC ASSOCIATES SEWALL STREET EXPANSION PROJECT: 22 SEWALL STREET, PORTLAND, MAINE		
FIRST FLOOR FIRE ALARM PLAN		
SHEET TITLE:		
SCALE: 1/8"=1'-0"	DATE: 5-20-03	
PROJECT MANAGER: DJT	GRAPHIC SCALE: 0" 1"	
JOB CAP/DRAWN: LAM		
A/E OF RECORD: DJT	SHEET No.	
SMRT CAD FILE: FA101-03018	FA101	
PROJECT No. 03018		

A1 FLOOR PLAN

1/8"=1'-0"