


NOTE:

1. SEE SHEET E-001 FOR LEGEND AND GENERAL NOTES.

KEYED NOTE:

① HEAT DETECTORS TO BE LOCATED WITHIN 2' FROM SPRINKLER HEAD. CONTRACTOR TO PROVIDE ADDITIONAL HEAT DETECTORS IF REQUIRED TO MEET DISTANCE REQUIREMENT.

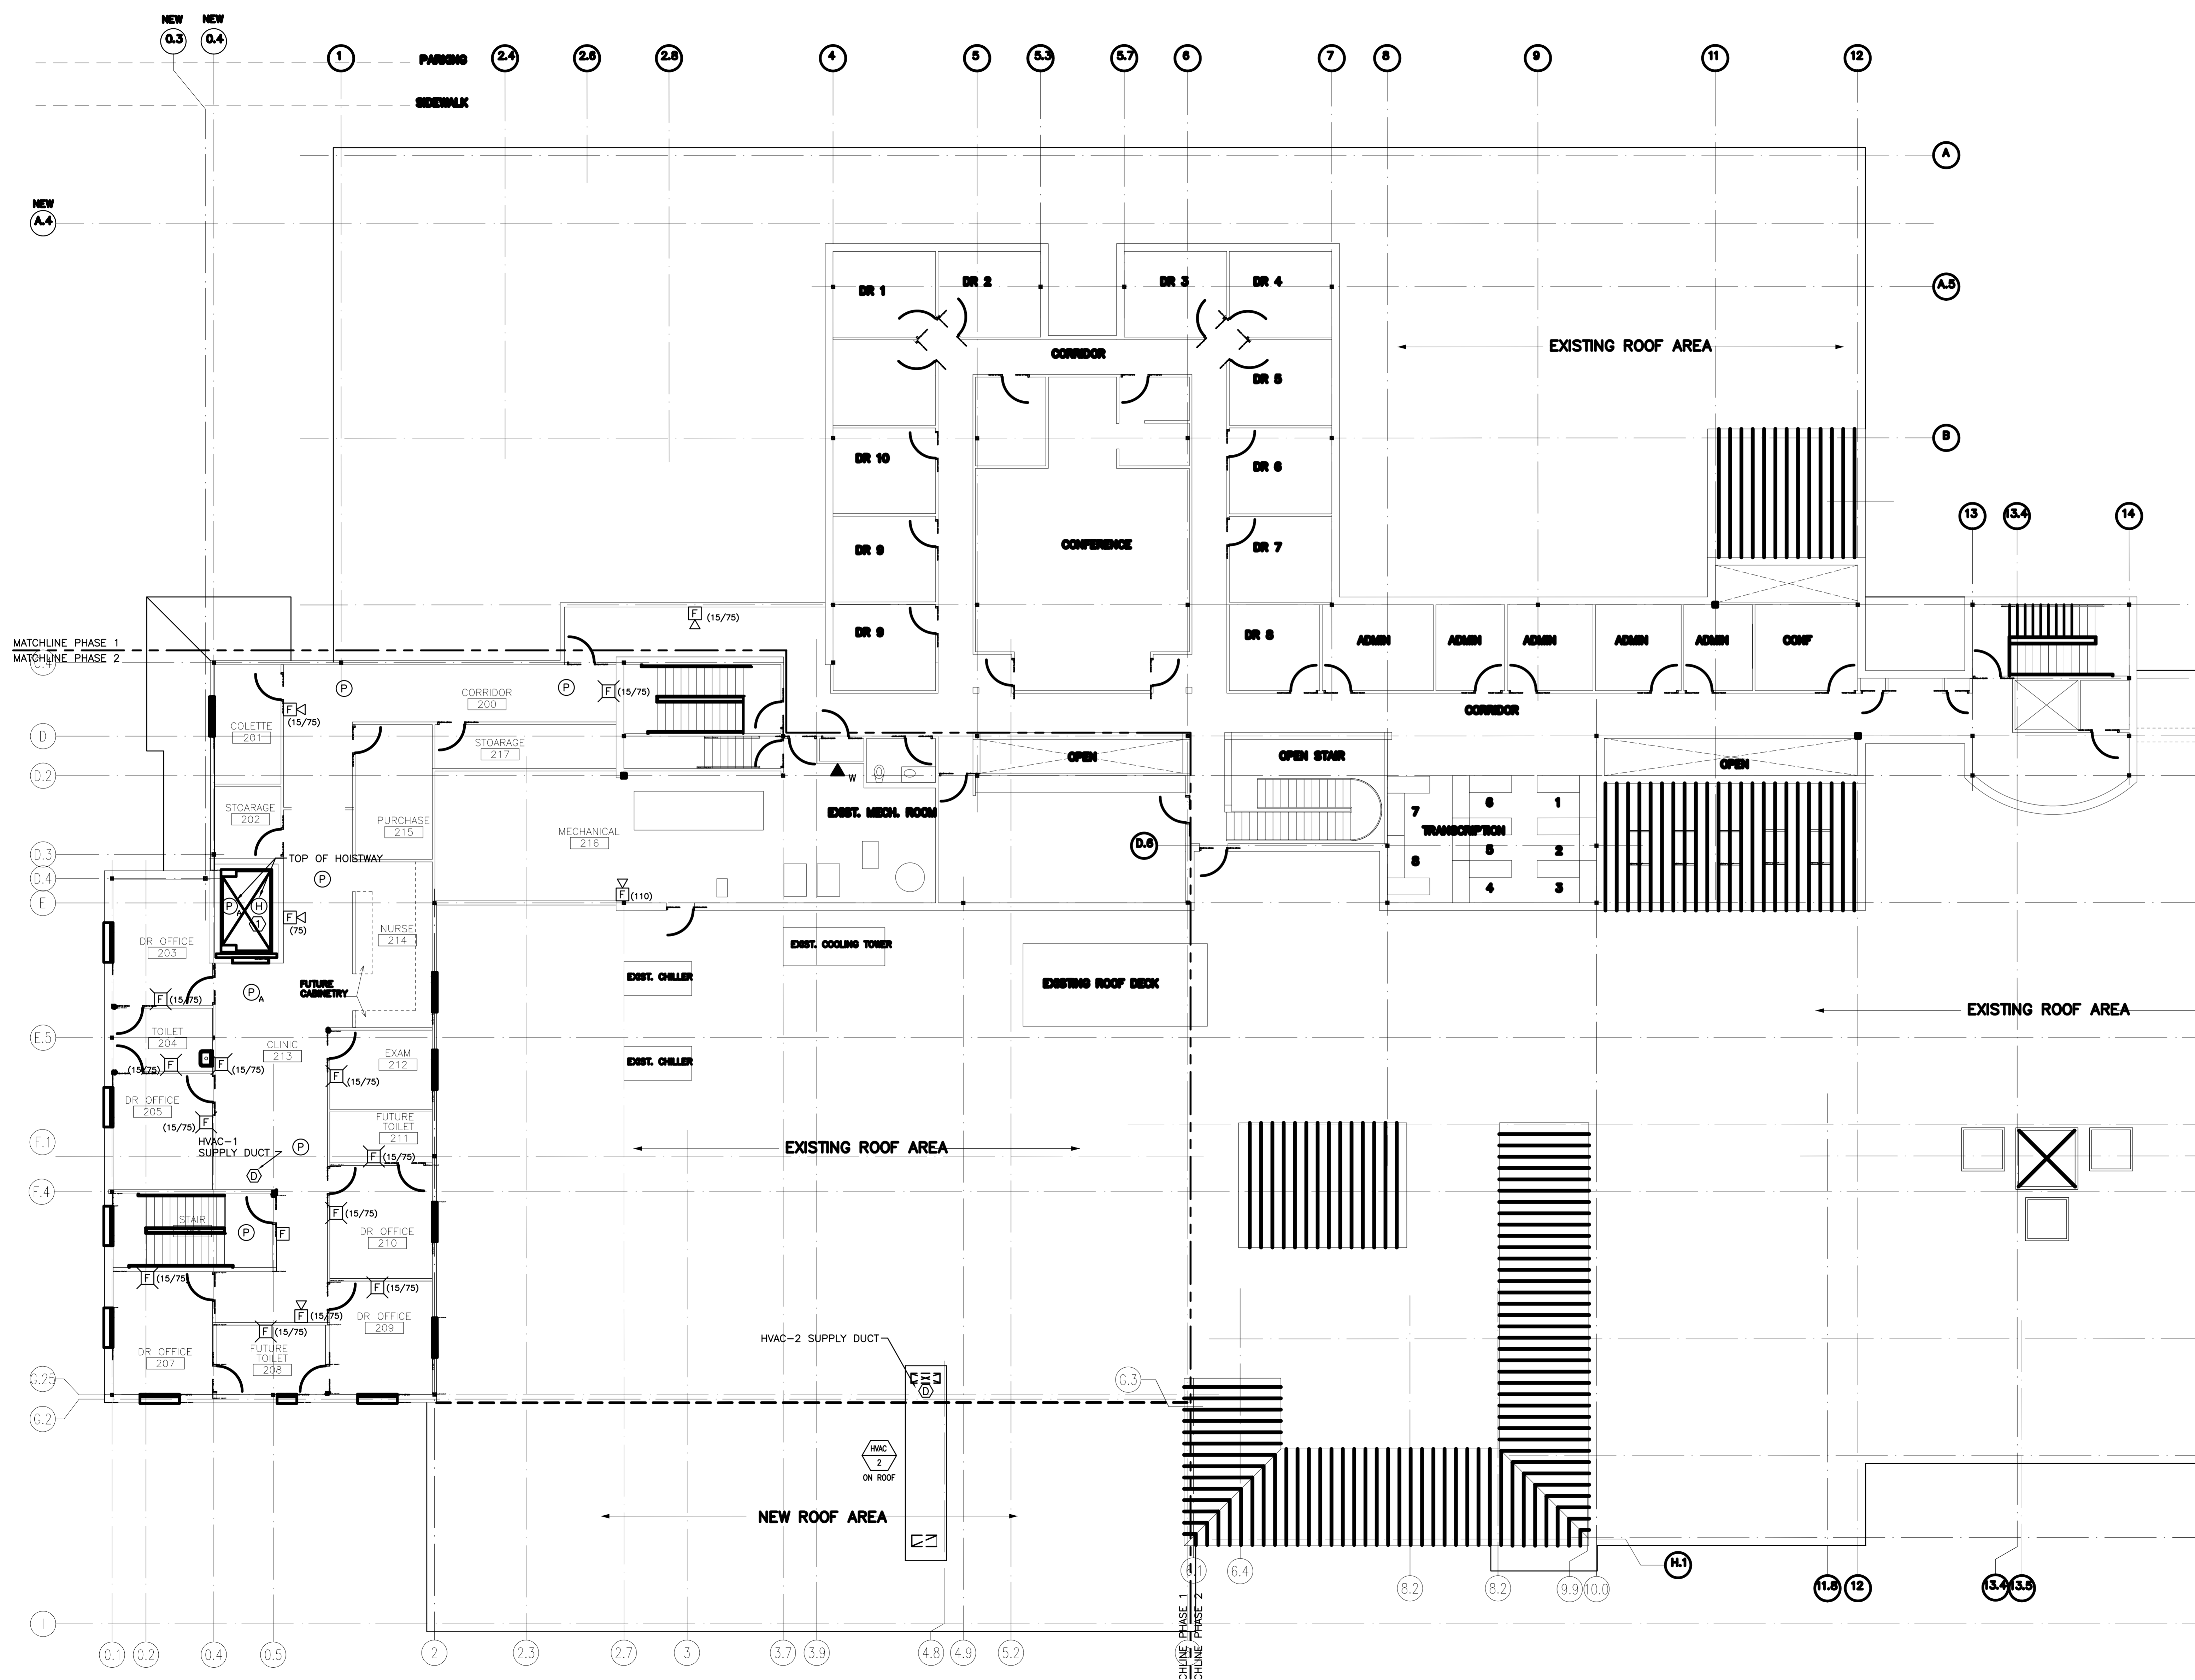

0	ISSUED FOR PERMITTING	5-20-03
REV.	DESCRIPTION	DATE

ISSUED FOR PERMITTING
5-20-03

CURRENT ISSUE STATUS:	



ORTHOPAEDIC ASSOCIATES
SEWALL STREET EXPANSION
PROJECT: 22 SEWALL STREET, PORTLAND, MAINE

**SECOND FLOOR
FIRE ALARM PLAN**

SHEET TITLE:	5-20-03
SCALE: 1/8"=1'-0"	DATE:
PROJECT MANAGER: DJT	GRAPHIC SCALE: 0" 1"
JOB CAP/DRAWN: LAM	SHEET No.
A/E OF RECORD: DJT	FA102
SMRT CAD FILE: FA102-03018	PROJECT No. 03018

A1 FLOOR PLAN

1/8"=1'-0"