


HEATING SYMBOLS LEGEND

	HOT WATER HEATING SUPPLY MAIN
	HOT WATER HEATING RETURN MAIN
	STEAM MAIN
	CONDENSATE RETURN
	CHILLED WATER SUPPLY
	CHILLED WATER RETURN
	GATE VALVE
	CHECK VALVE
	BALANCING COCK
	MOTORIZED CONTROL VALVE
	O.S. & Y. VALVE
	RELIEF VALVE
	THERMOSTAT
	THERMOSTAT W/ GAUGE
	PRESSURE GAUGE
	AIR PIPING
	GAS PIPING
	BALANCING DAMPER IN DUCT
	BUTTERFLY VALVE
	ECCENTRIC REDUCER
	AIR VENT
	PLUMBED CONDENSATE RETURN

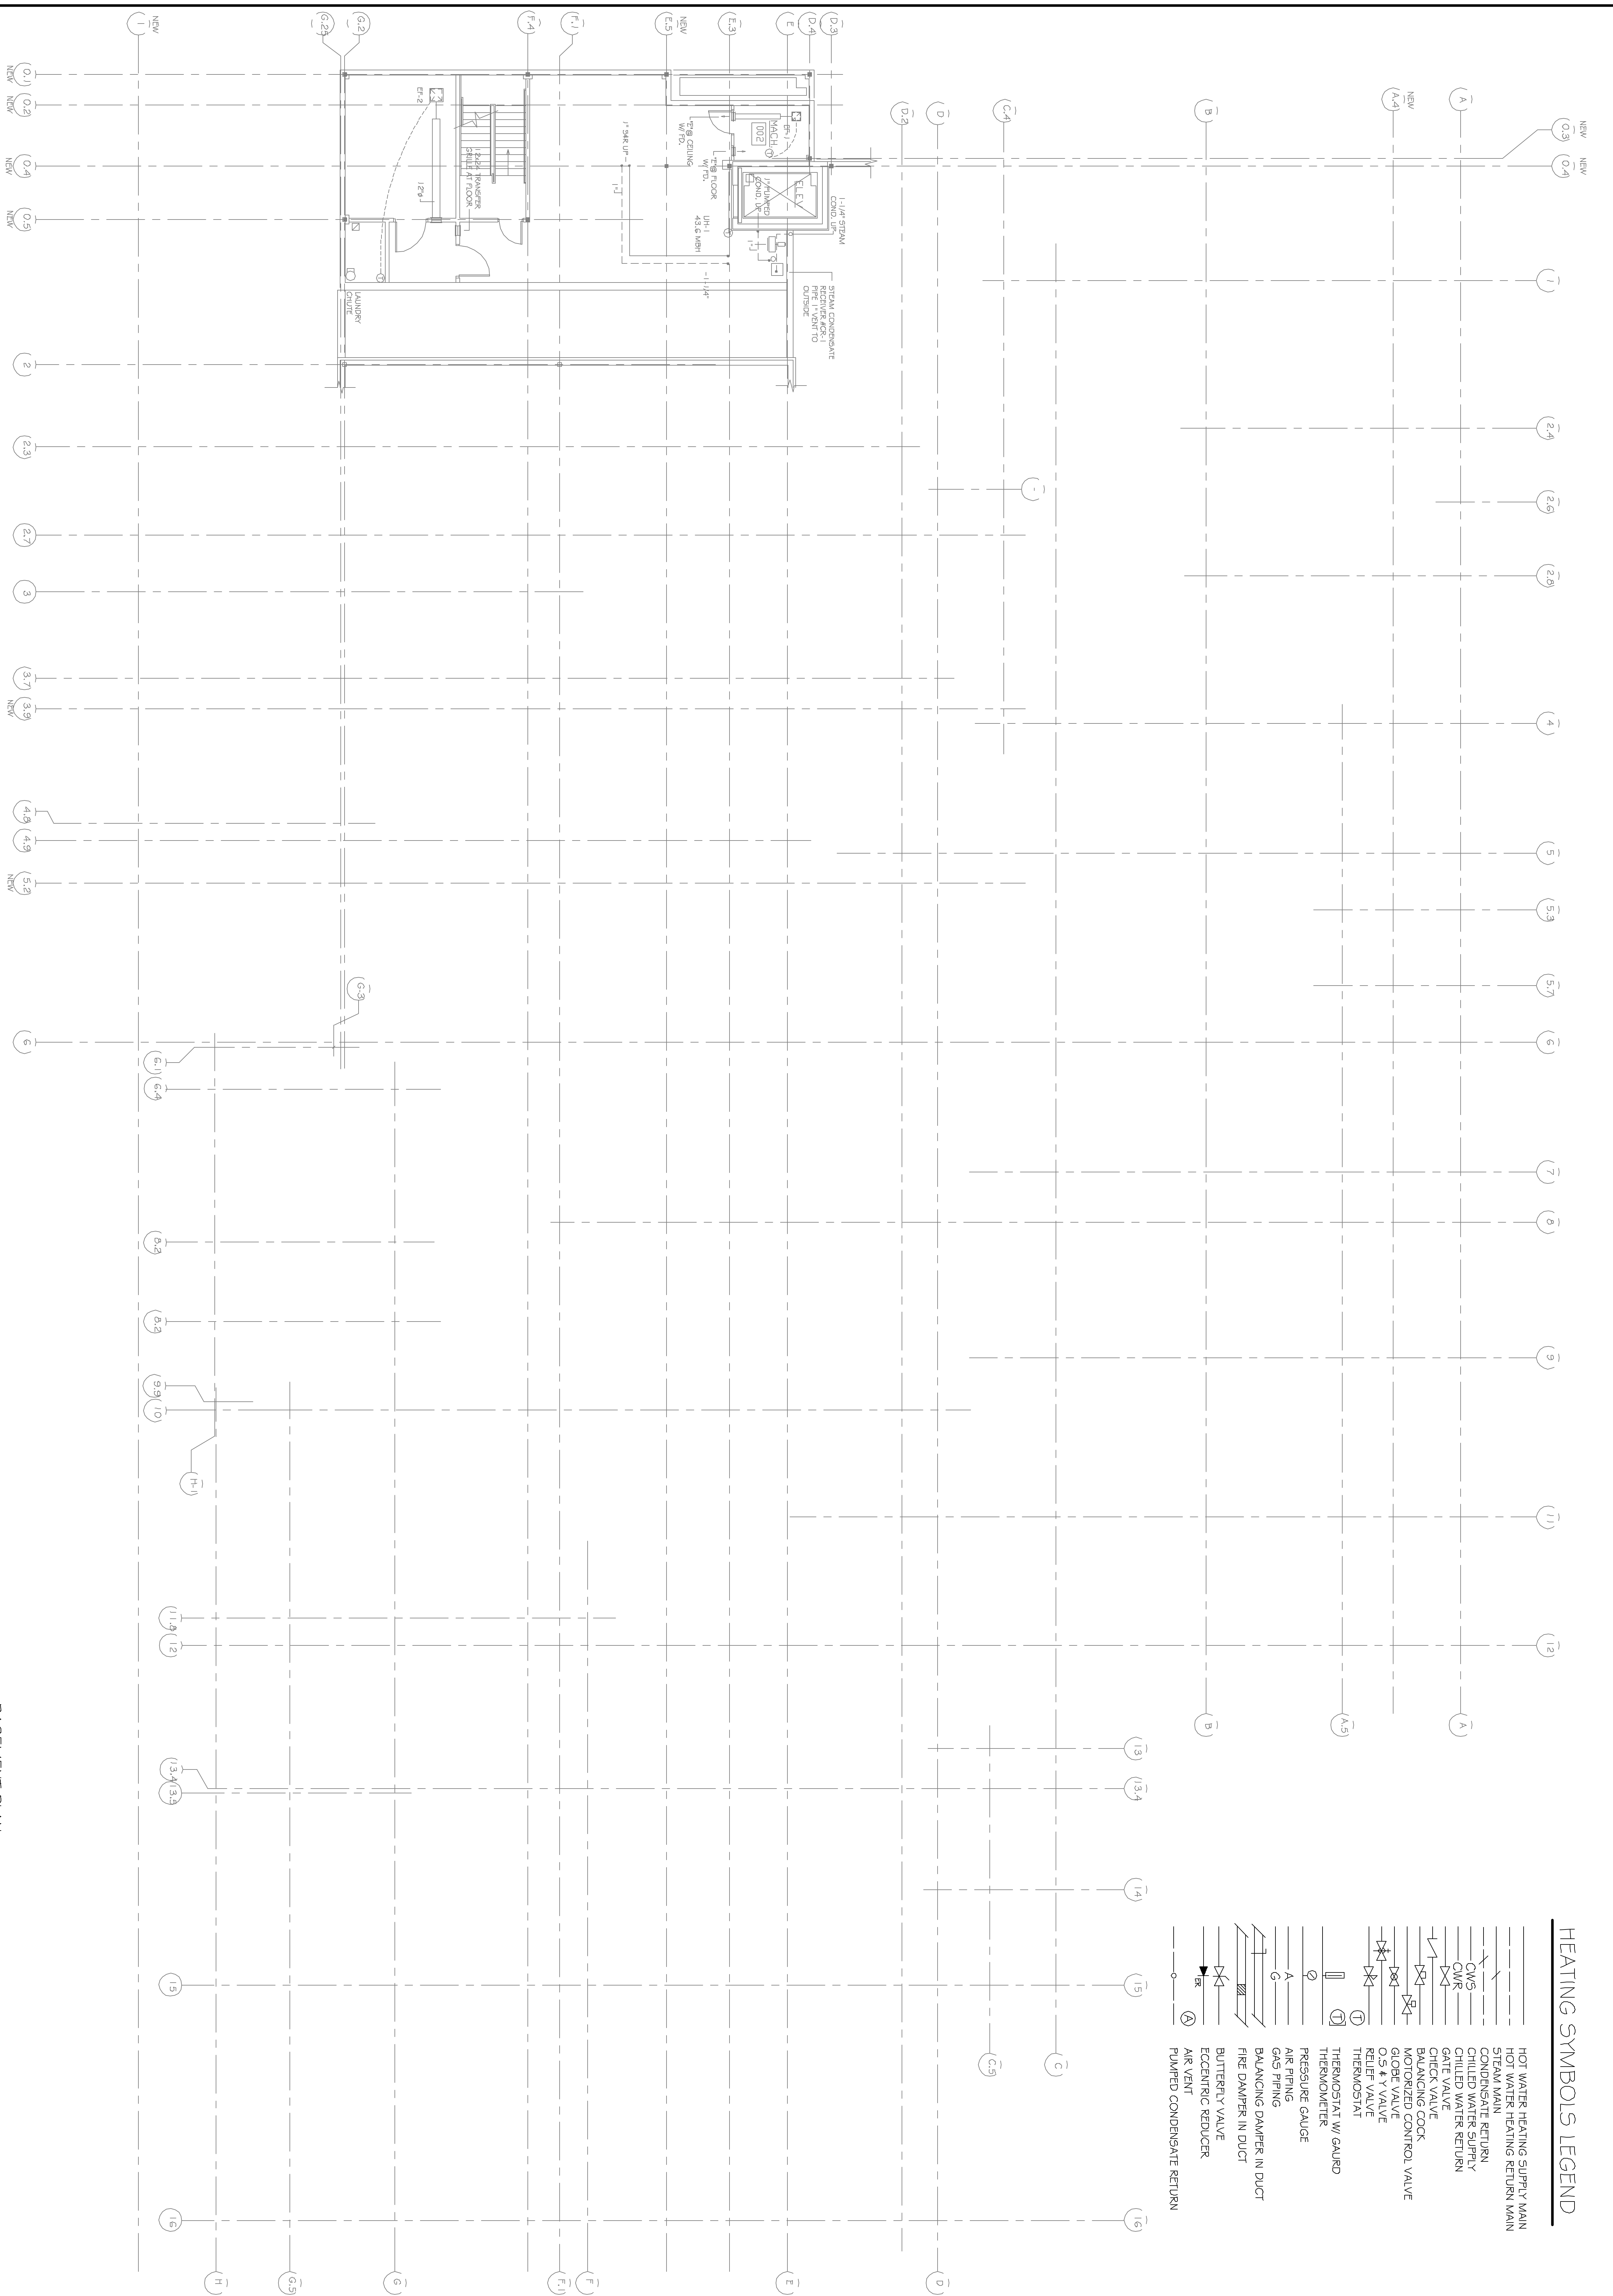

BASEMENT PLAN
SCALE 1/8"=1'-0"

<p>SHEET # M-1 OF 9</p>	<p>PROJECT: ORTHOPAEDIC ASSOCIATES, PA BUILDING EXPANSION 33 SEWALL STREET PORTLAND, MAINE</p>	<table border="1" style="width:100%; border-collapse: collapse;"> <tr> <td style="font-size: 8px;">DRAWN: XXX</td> <td style="font-size: 8px;">CHECKED: MPJ</td> </tr> <tr> <td colspan="2" style="font-size: 8px;">SCALE: 1/8"=1'-0"</td> </tr> <tr> <td colspan="2" style="font-size: 8px;">DATE: 02/25/05</td> </tr> <tr> <td colspan="2" style="font-size: 8px;">PROJECT #: 02305</td> </tr> </table>	DRAWN: XXX	CHECKED: MPJ	SCALE: 1/8"=1'-0"		DATE: 02/25/05		PROJECT #: 02305		<p>DRAWINGS THIS SHEET BASMENT MECHANICAL PLAN & DETAILS</p>	<p>REVISIONS: PERMIT SET 02/25/05</p>	<p style="text-align: center;">JOHNSON JORDAN & MECHANICAL CONTRACTORS 18 MURSEY ROAD SCARBOROUGH, MAINE 04074 TEL. (207) 883-8845 * FAX (207) 883-8619</p> <div style="text-align: right;"> </div>
DRAWN: XXX	CHECKED: MPJ												
SCALE: 1/8"=1'-0"													
DATE: 02/25/05													
PROJECT #: 02305													