


NOTE: FINISH SHOWING TOP CABINET, FINISH SHOWN RUN IN HORIZONTAL PIPE CHASE ALONG BACK SEE ARCHITECTURAL PLANS FOR CHASE DETAIL

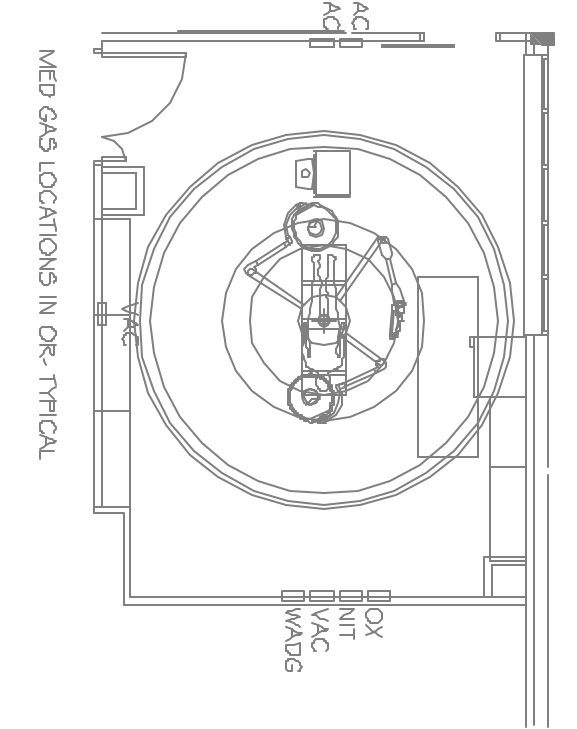

FIRST FLOOR PLAN

SCALE: 1/8" = 1'-0"

SHEET # M-8 OF 9	PROJECT: ORTHOPAEDIC ASSOCIATES, PA BUILDING EXPANSION 33 SEWALL STREET PORTLAND, MAINE	DRAWN: XXX	CHECKED: MPJ	DRAWINGS THIS SHEET FIRST FLOOR PLUMBING PLAN- WATER & GAS	REVISIONS: PERMIT SET 02/25/05	
		SCALE: 1/8" = 1'-0"	DATE: 02/25/05			